

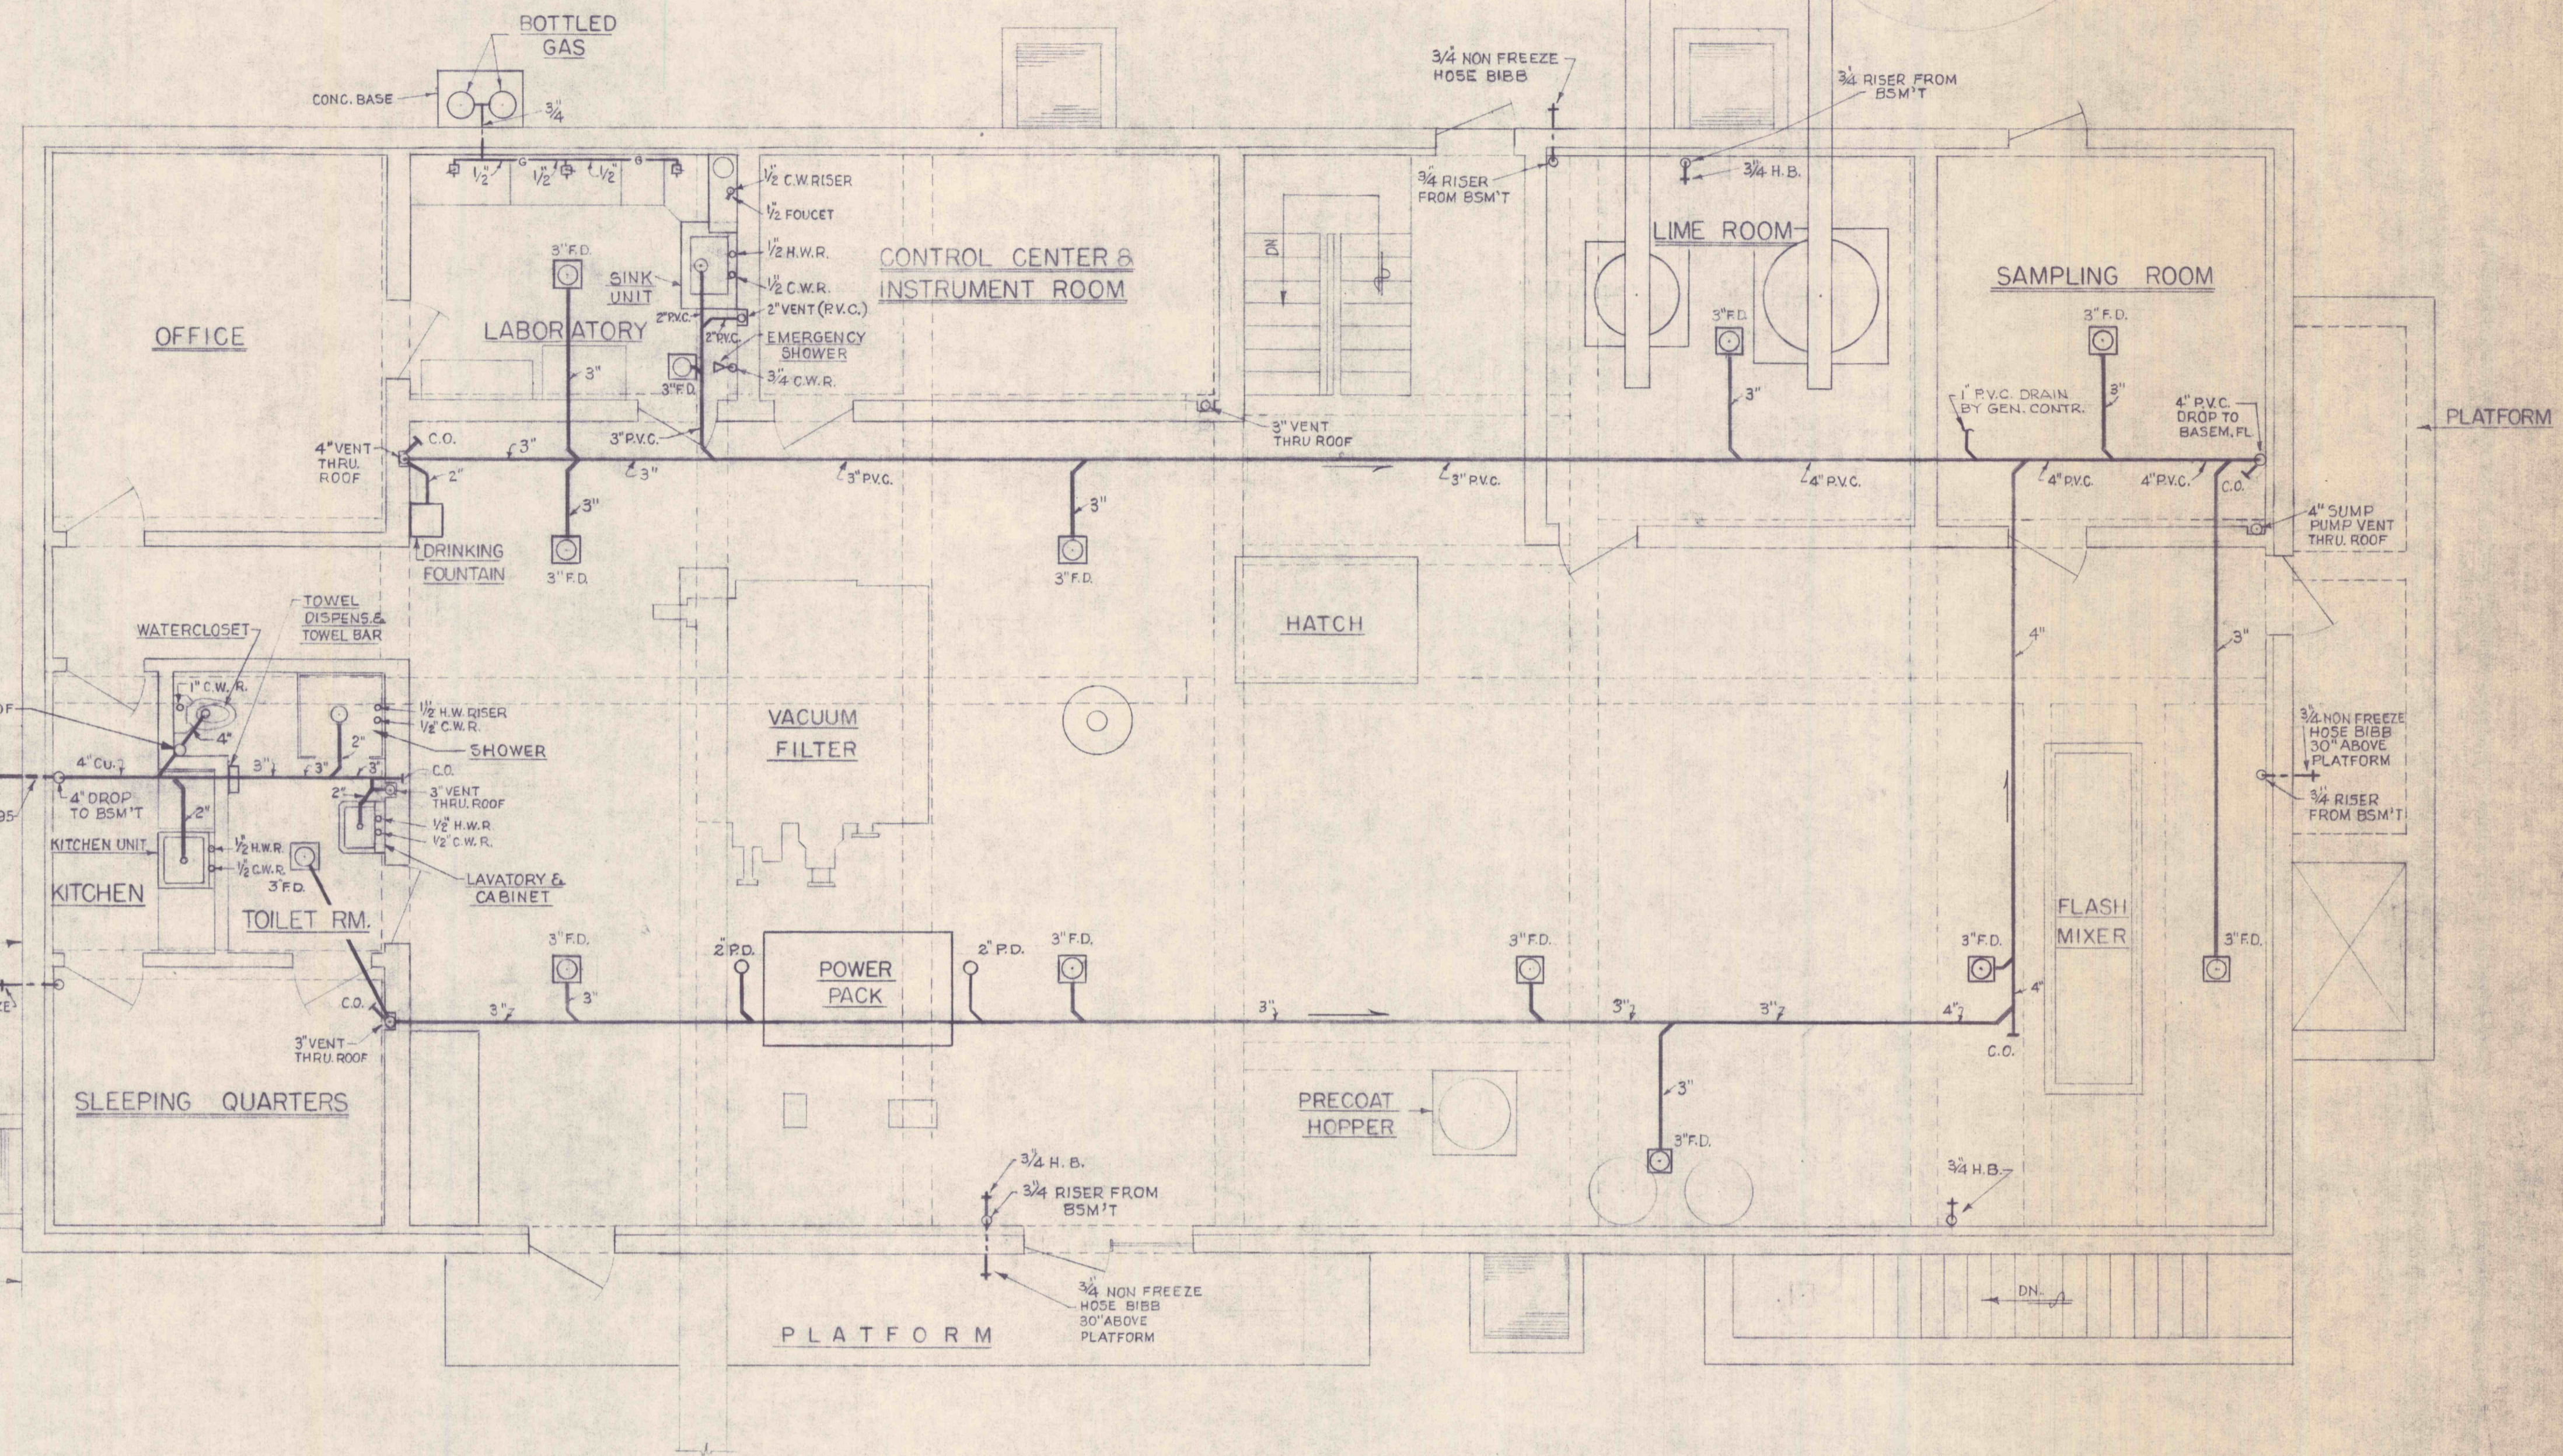



SECTION A-A  
SCALE 1/2" = 1'-0"

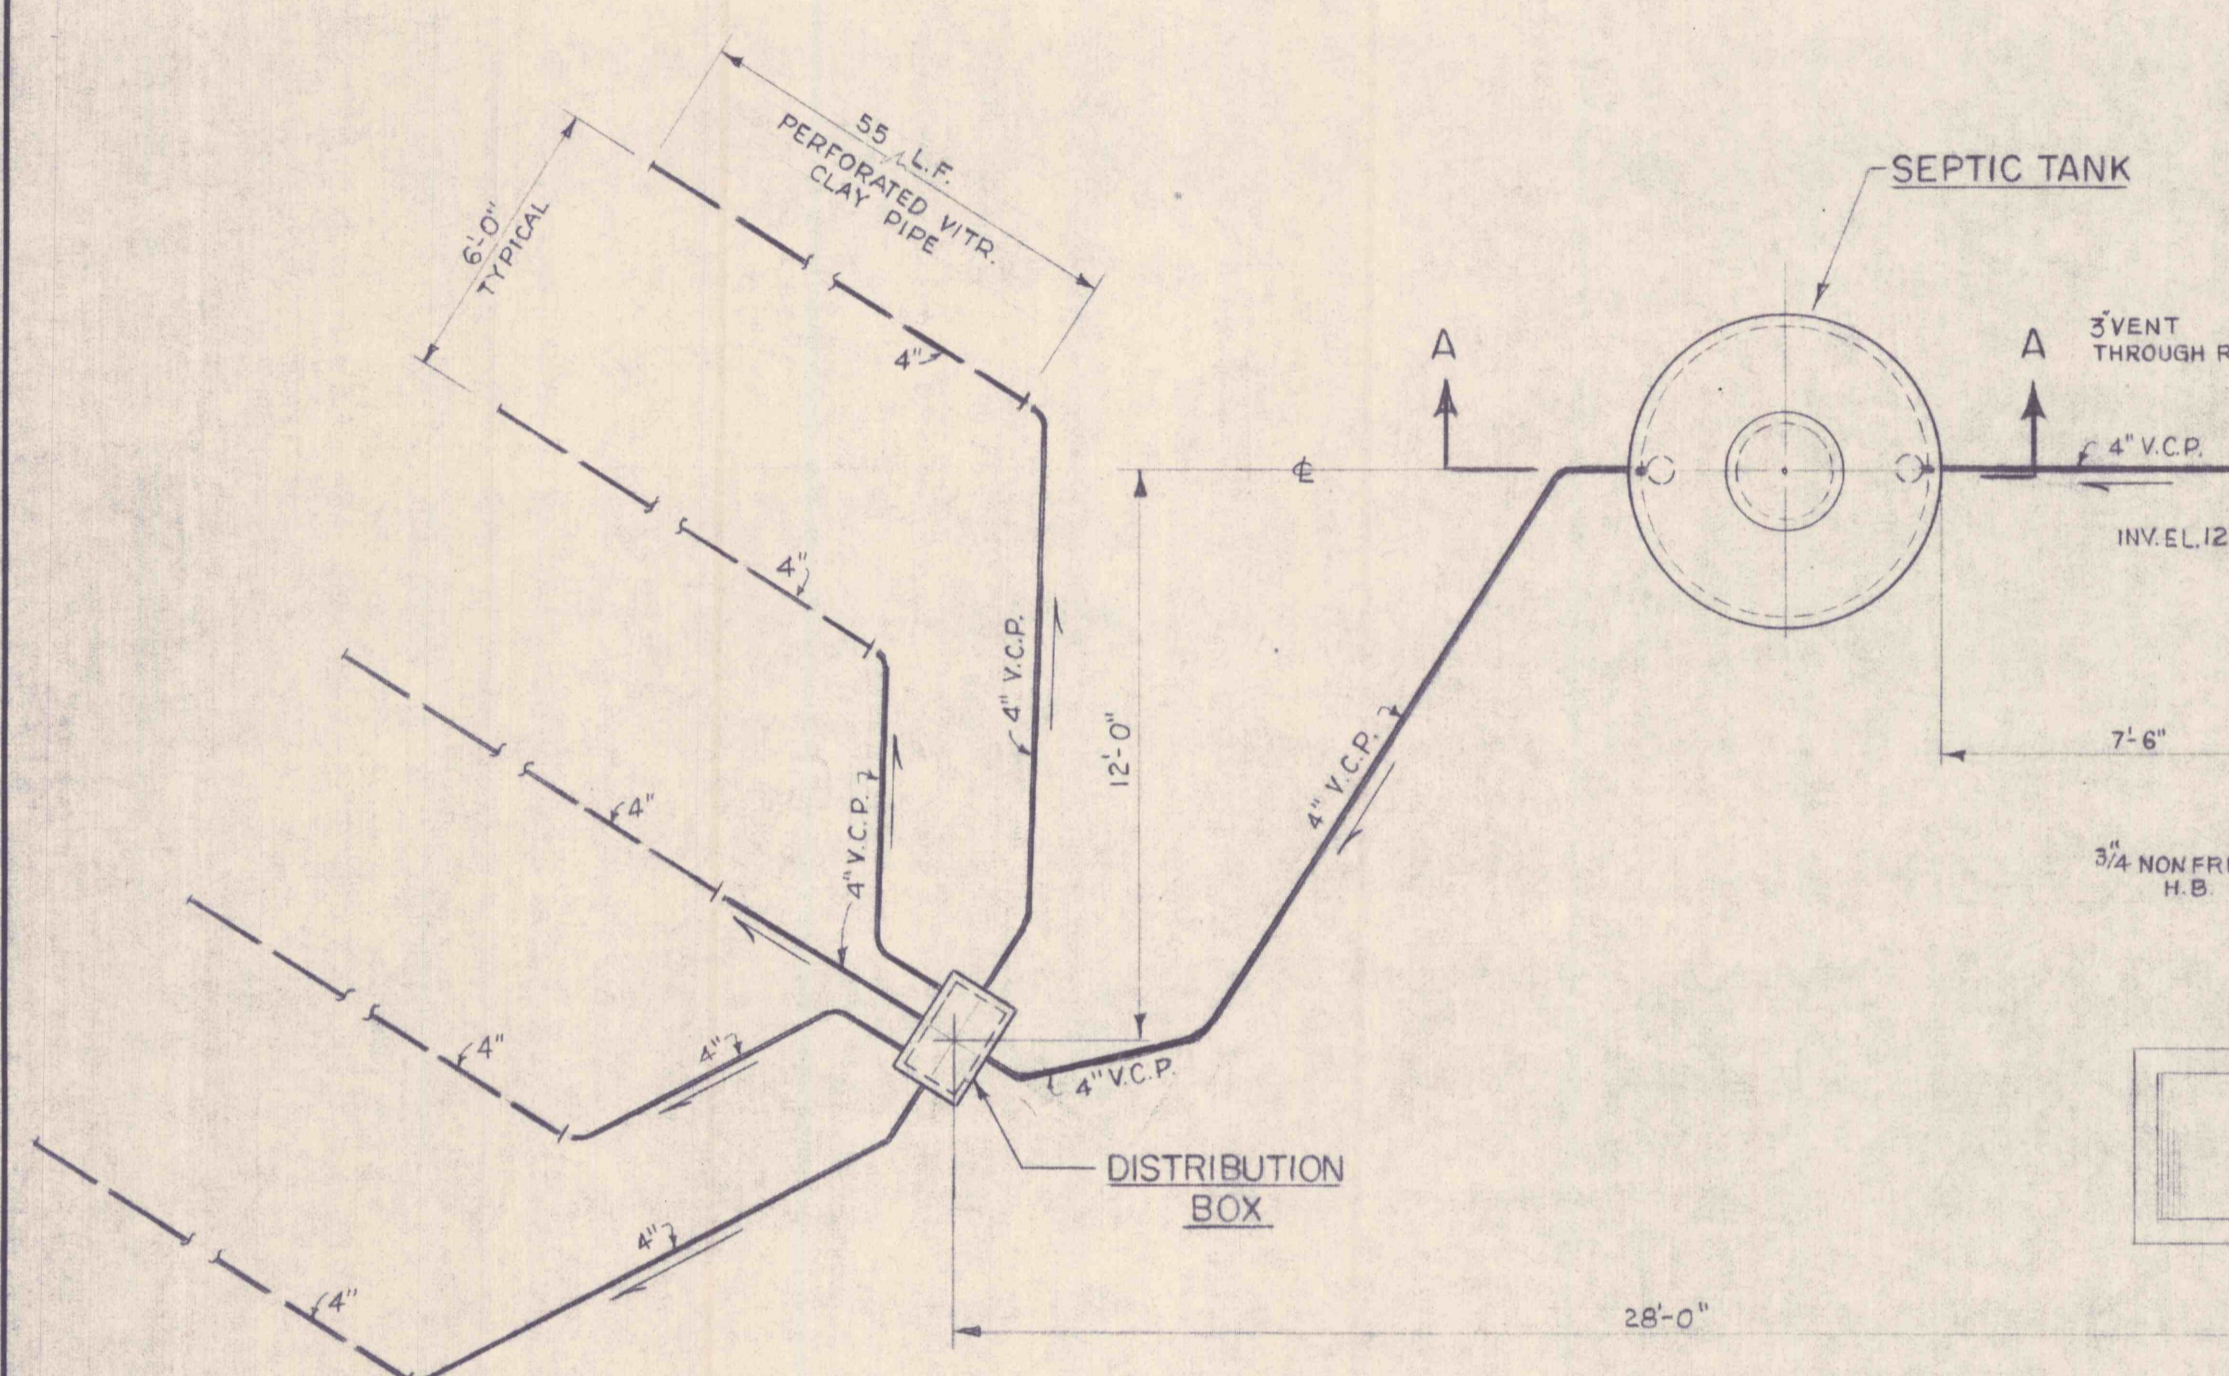


GROUND FLOOR PLAN  
SCALE 1/4" = 1'-0"

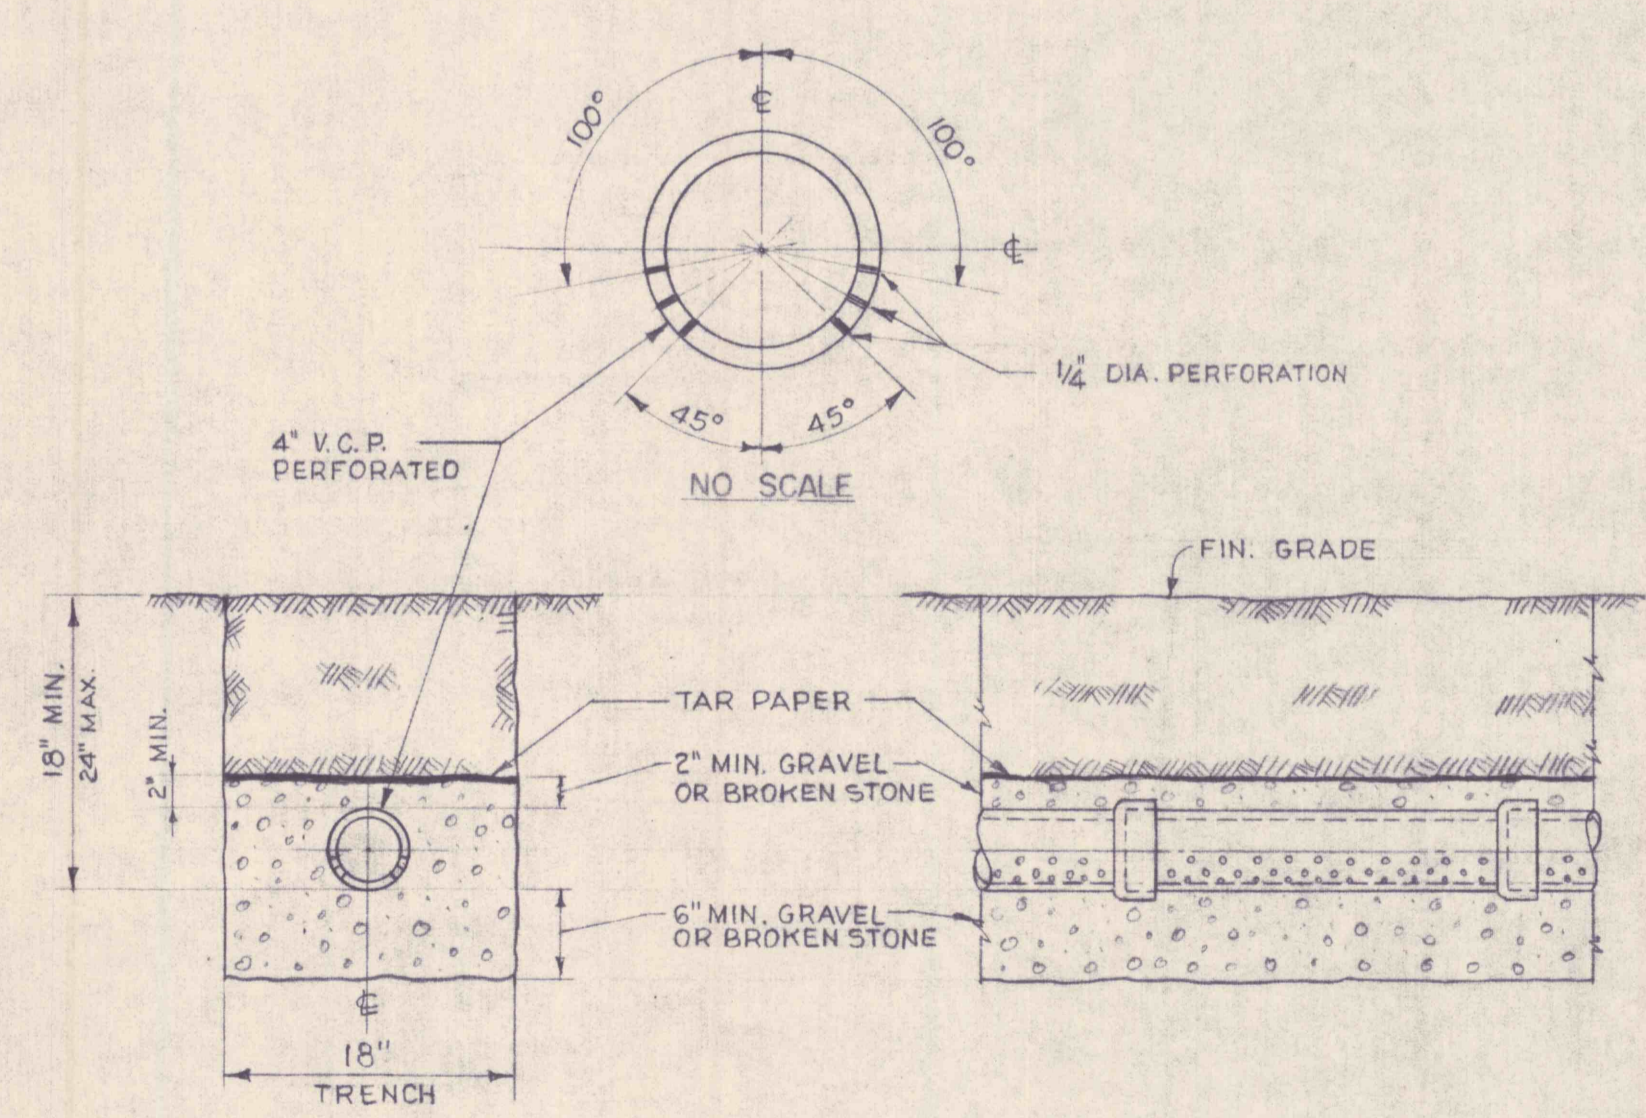

TILE FIELD TRENCH DETAILS  
SCALE 1" = 1'-0"

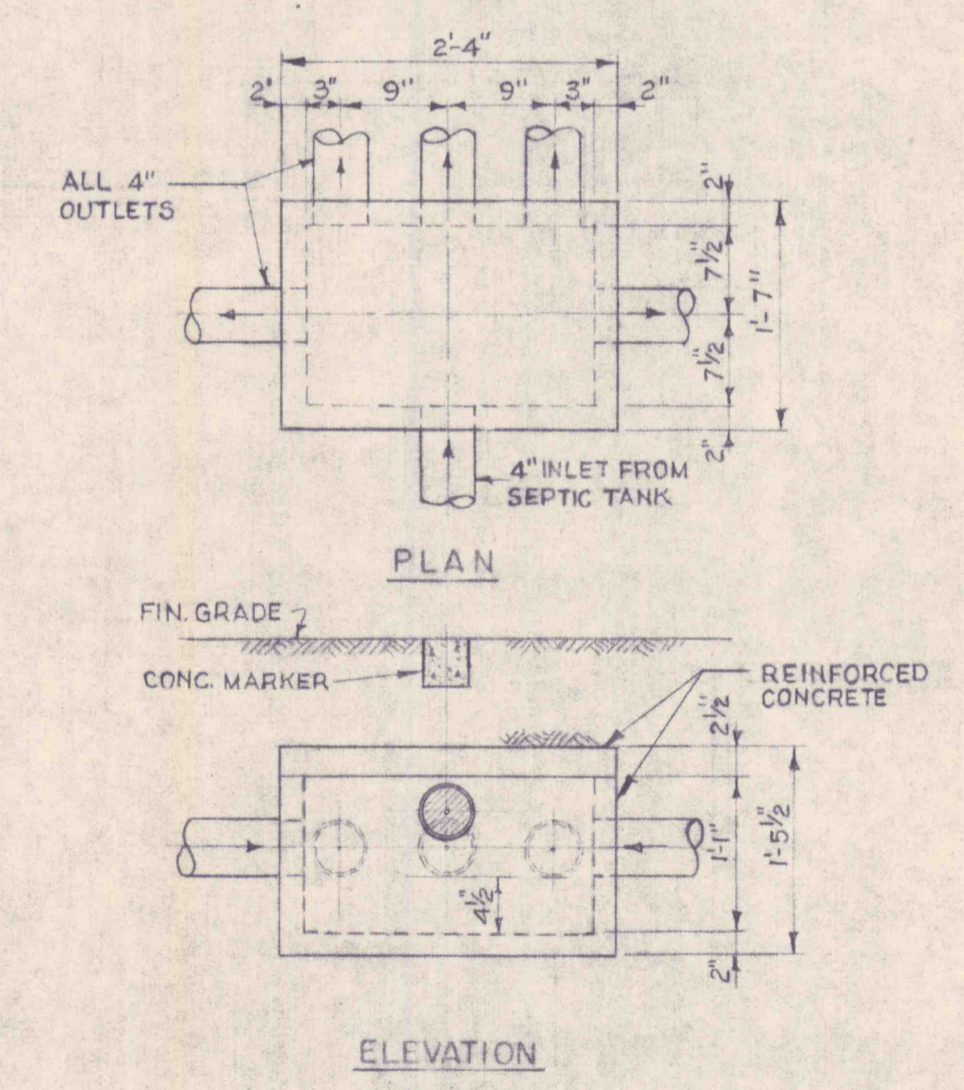


DISTRIBUTION BOX DETAIL  
SCALE 3/4" = 1'-0"

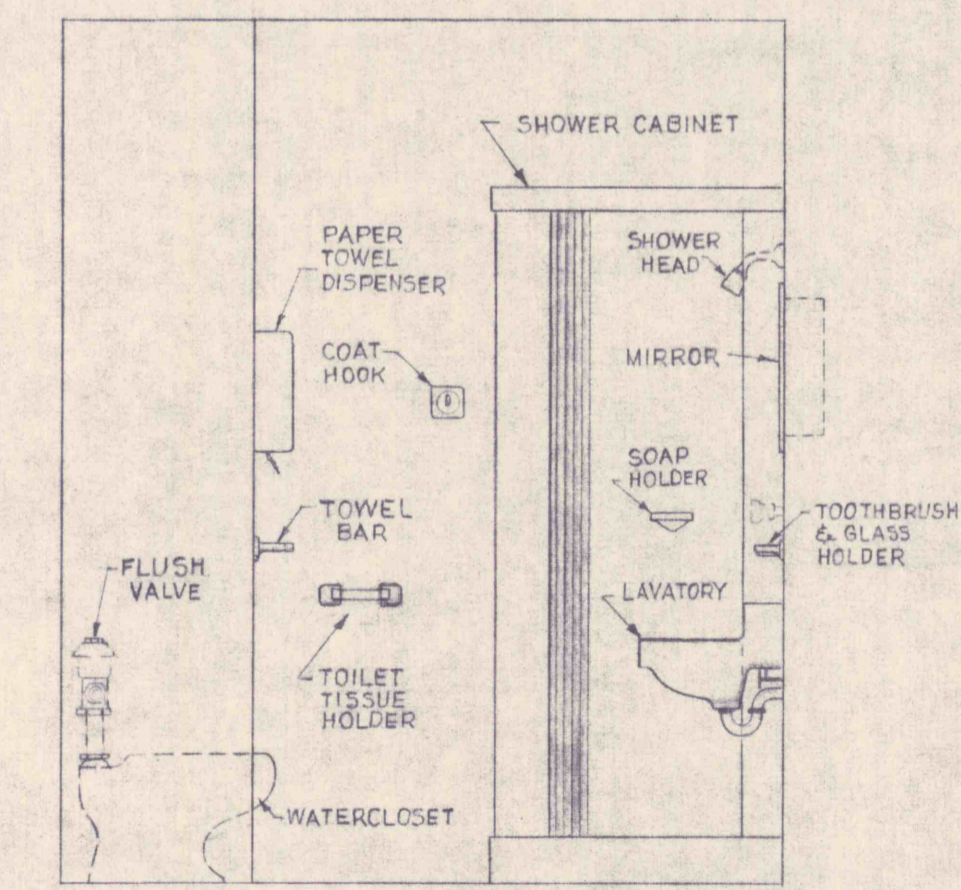

SECTION THRU TOILET RM.  
SCALE 1/2" = 1'-0"

- LEGEND**
- 3/4" H.B. HOSE BIBB
  - 3" F.D. FLOOR DRAIN
  - C.O. CLEAN OUT
  - C.W. COLD WATER POTABLE
  - H.W. HOT WATER
  - G. GAS COCK
  - G.V. GLOBE VALVE
  - G.V. GATE VALVE
  - C.V. CHECK VALVE
  - P.D. PUMP DRAIN
  - R.V. RELIEF VALVE
  - G L.P. GAS
  - A COMPRESSED AIR
  - H.W.R. HOT WATER RISER
  - C.W.R. COLD WATER RISER

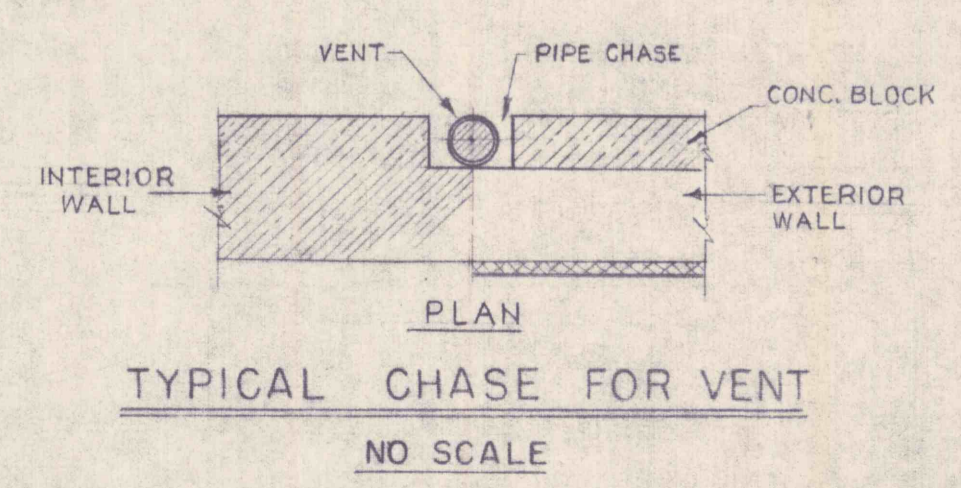

TYPICAL CHASE FOR VENT  
NO SCALE

REVISIONS			
NO.	DESCRIPTION	DATE	BY



DRAWN J. A. TRACED J. A. CHECKED C. K. M. APPROVED G. G. B. APPROVED	<b>GANNETT FLEMING CORDDRY &amp; CARPENTER, INC.</b> ENGINEERS 600 N. SECOND ST. HARRISBURG, PENNA.	JOB No. 4590	THE PENNSYLVANIA STATE UNIVERSITY CONSTRUCTION OF A MINE DRAINAGE TREATMENT PLANT HUSTON TOWNSHIP, CLEARFIELD CO., PA.	SHEET No. 22
		SCALE AS SHOWN	CONTROL BUILDING GROUND FLOOR PLUMBING & SEPTIC SYSTEM	DRAWING No. I-17531