

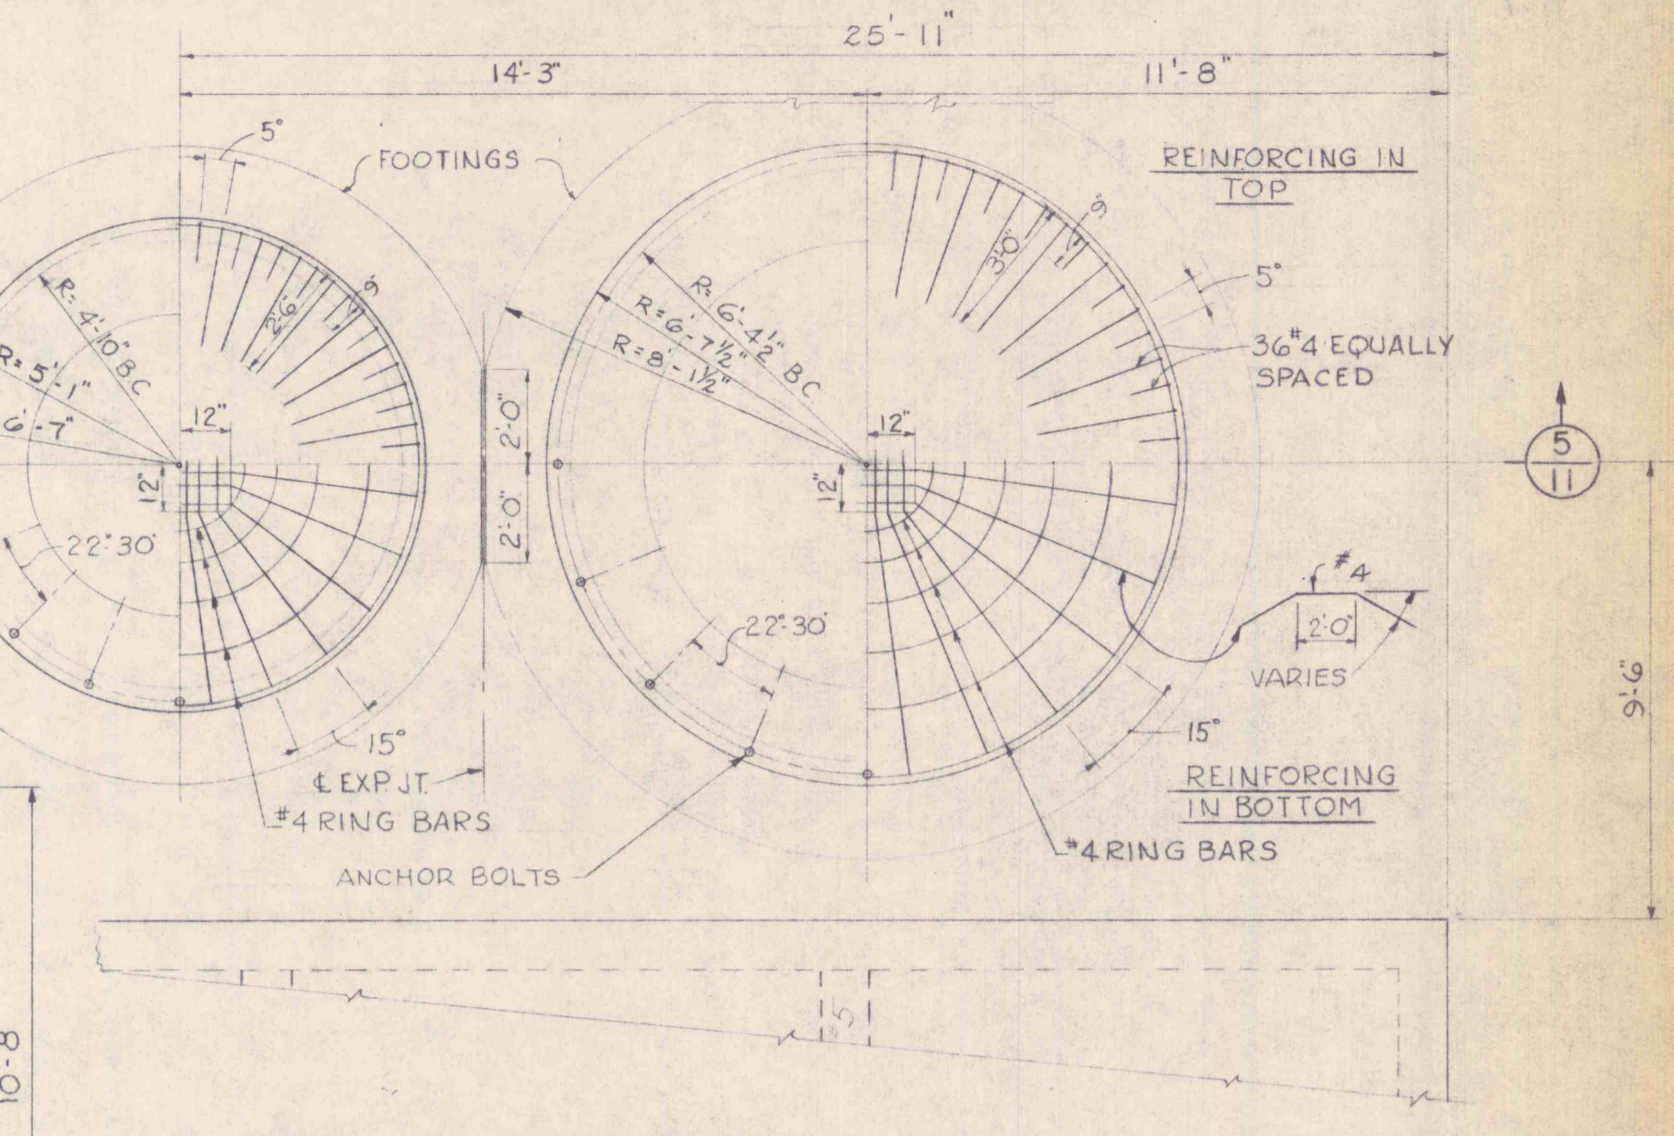



GROUND FLOOR PLAN

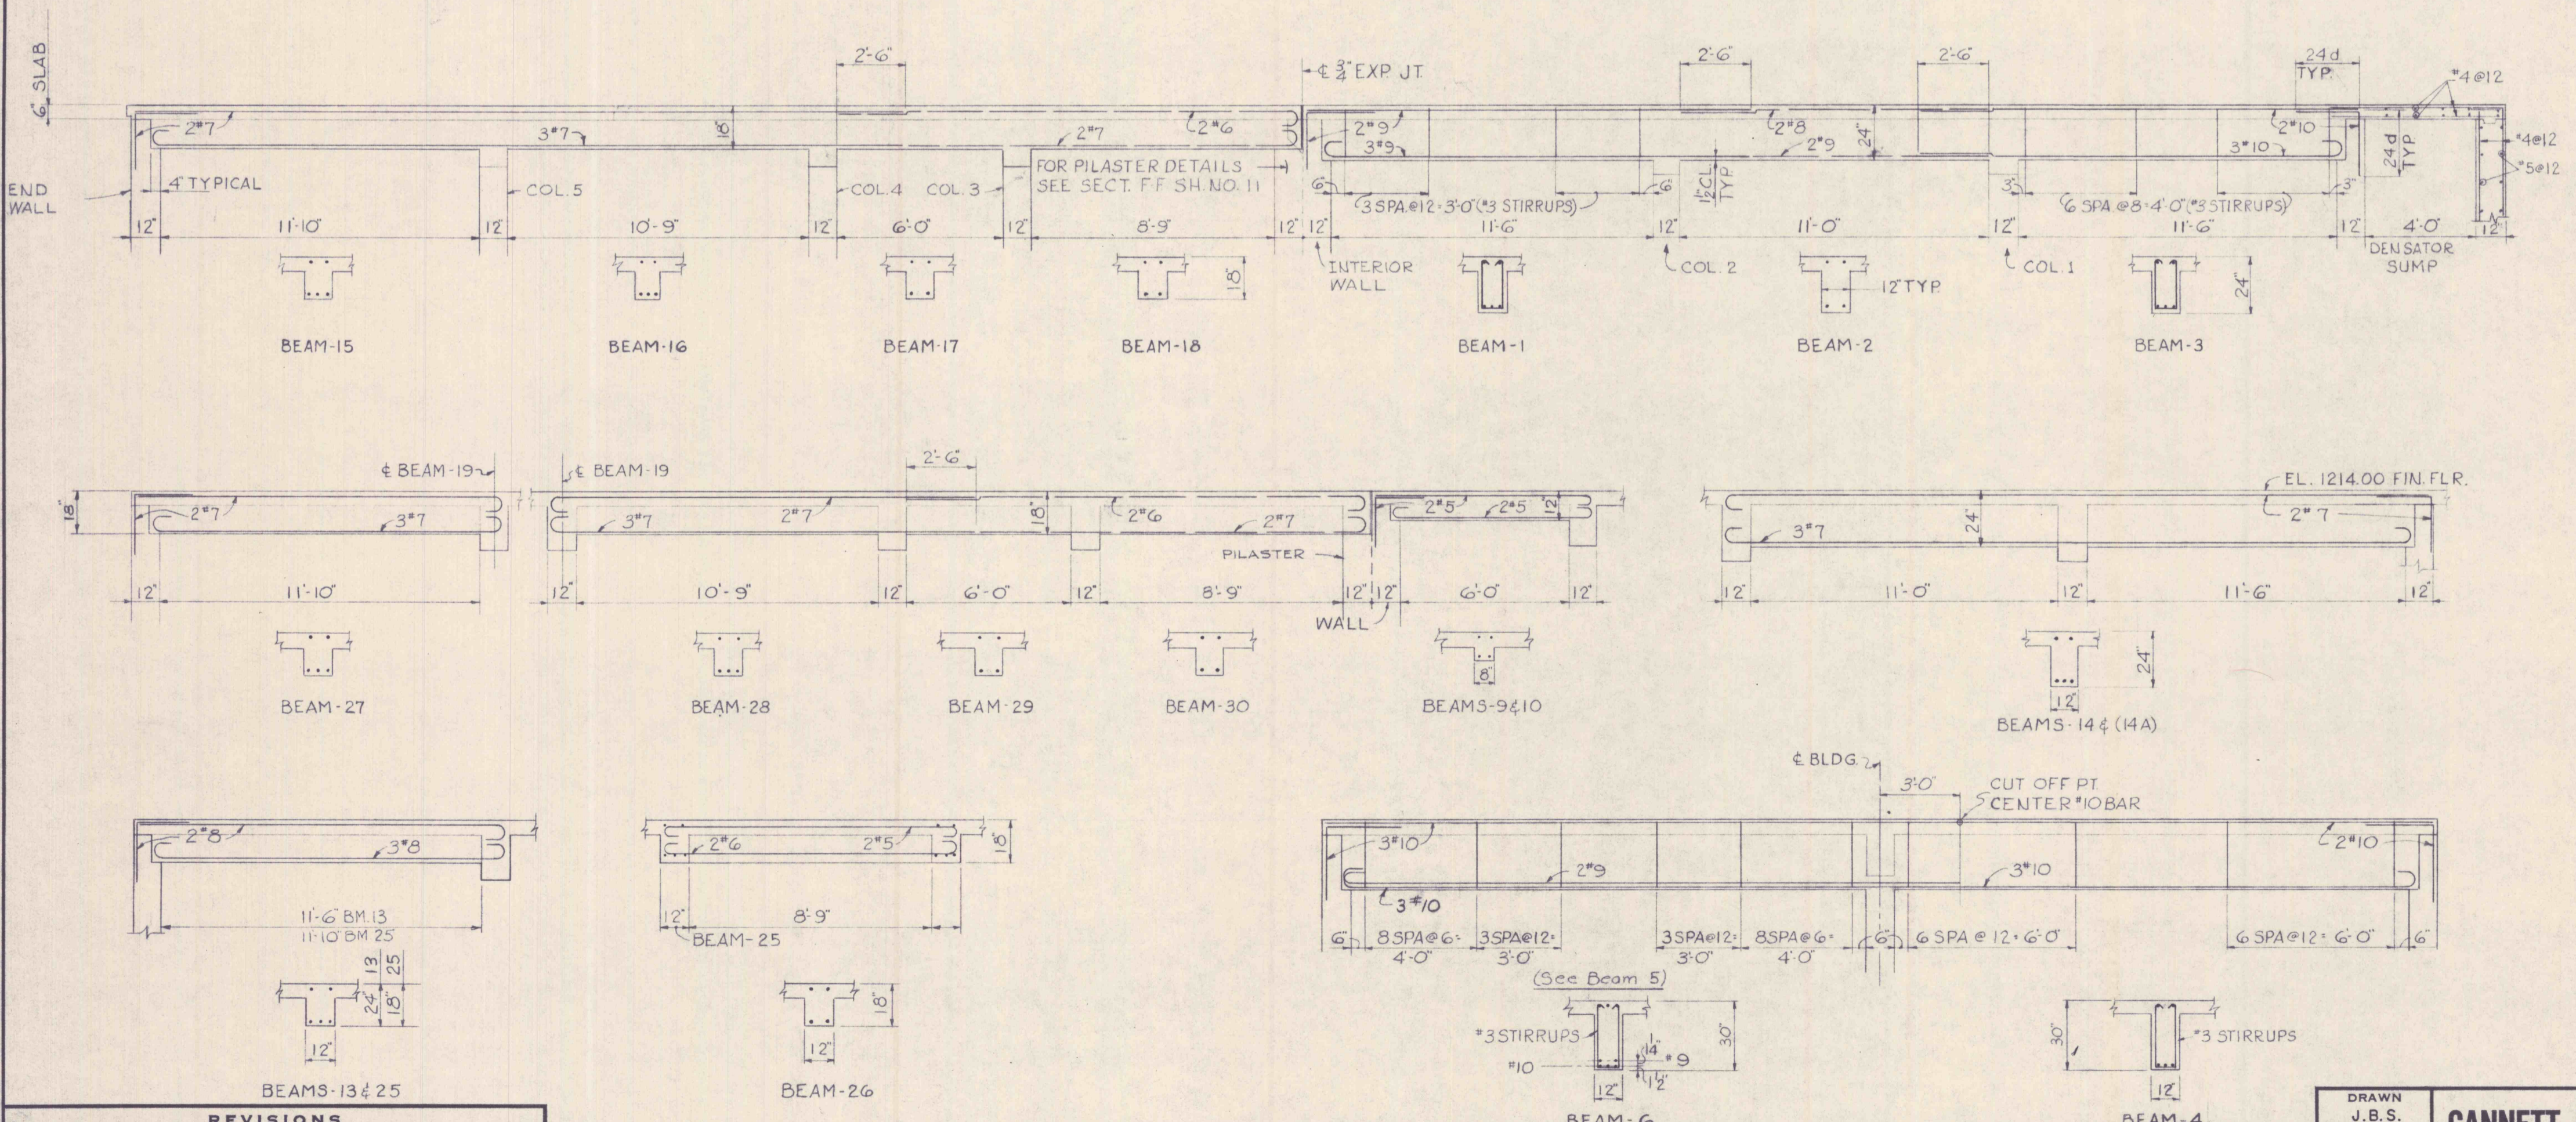

LIME STORAGE TANK FOUNDATION PLANS

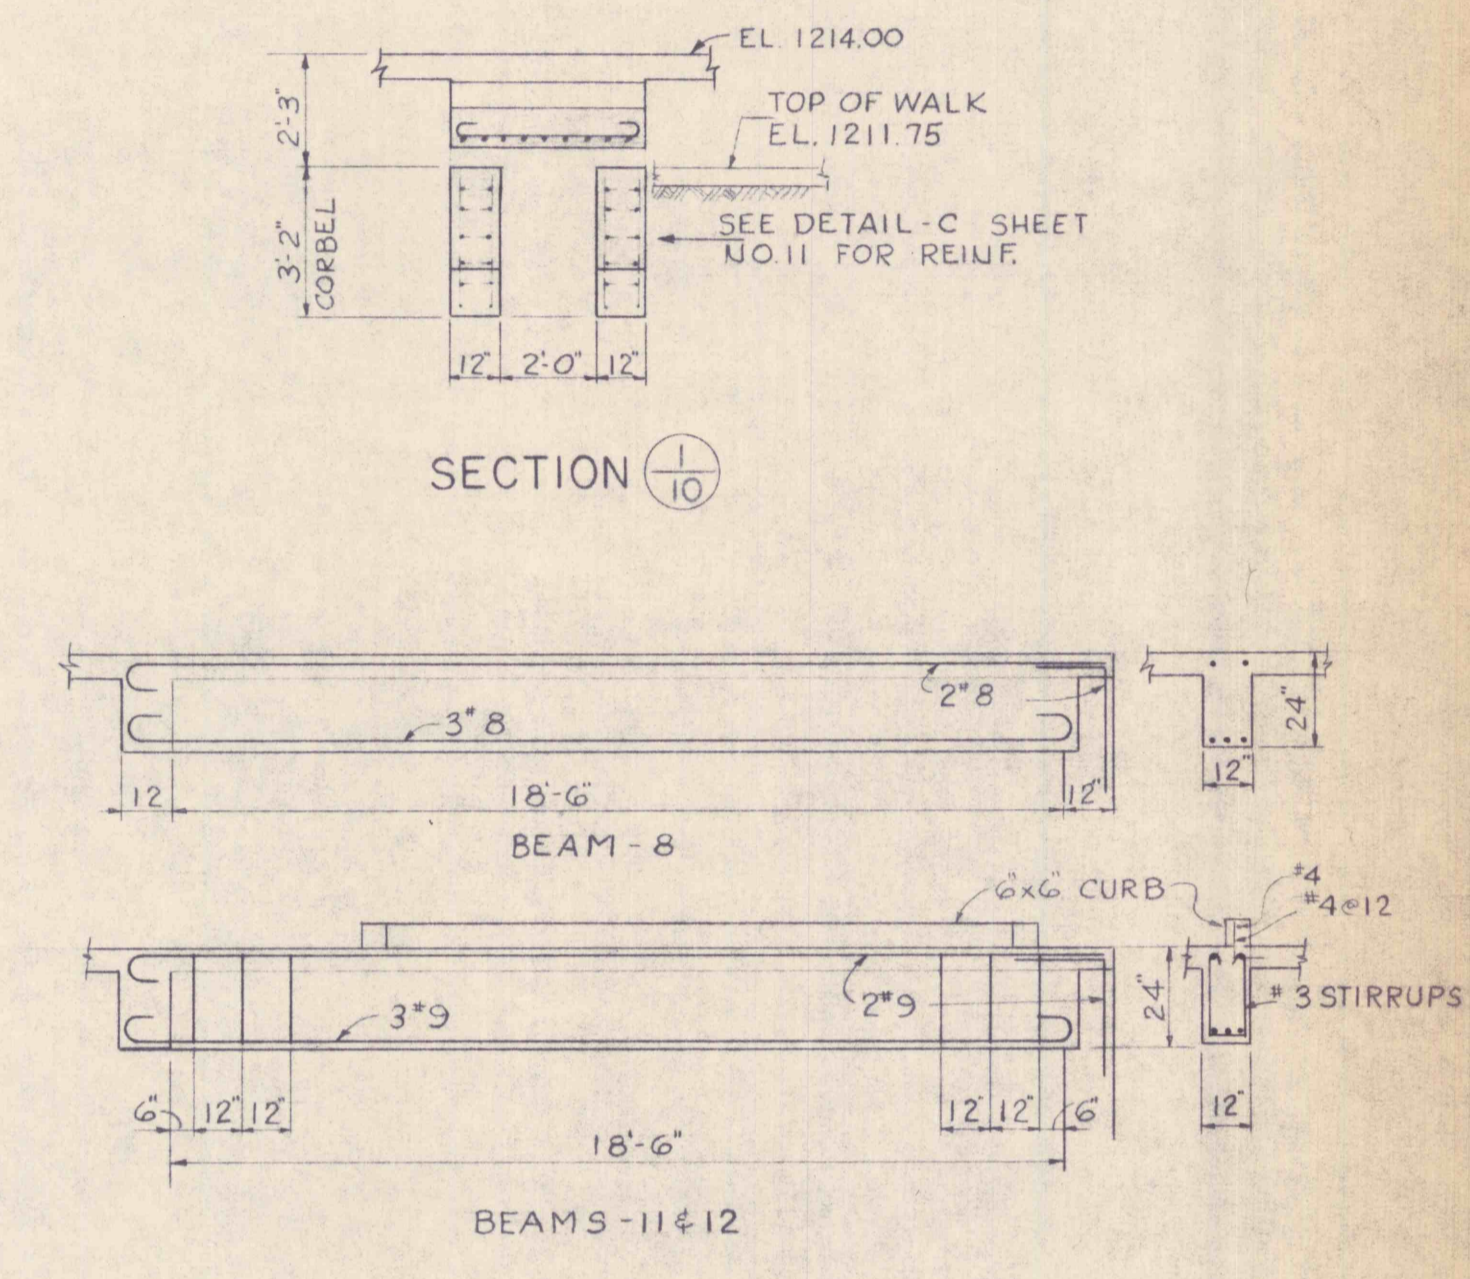

BEAM DETAILS

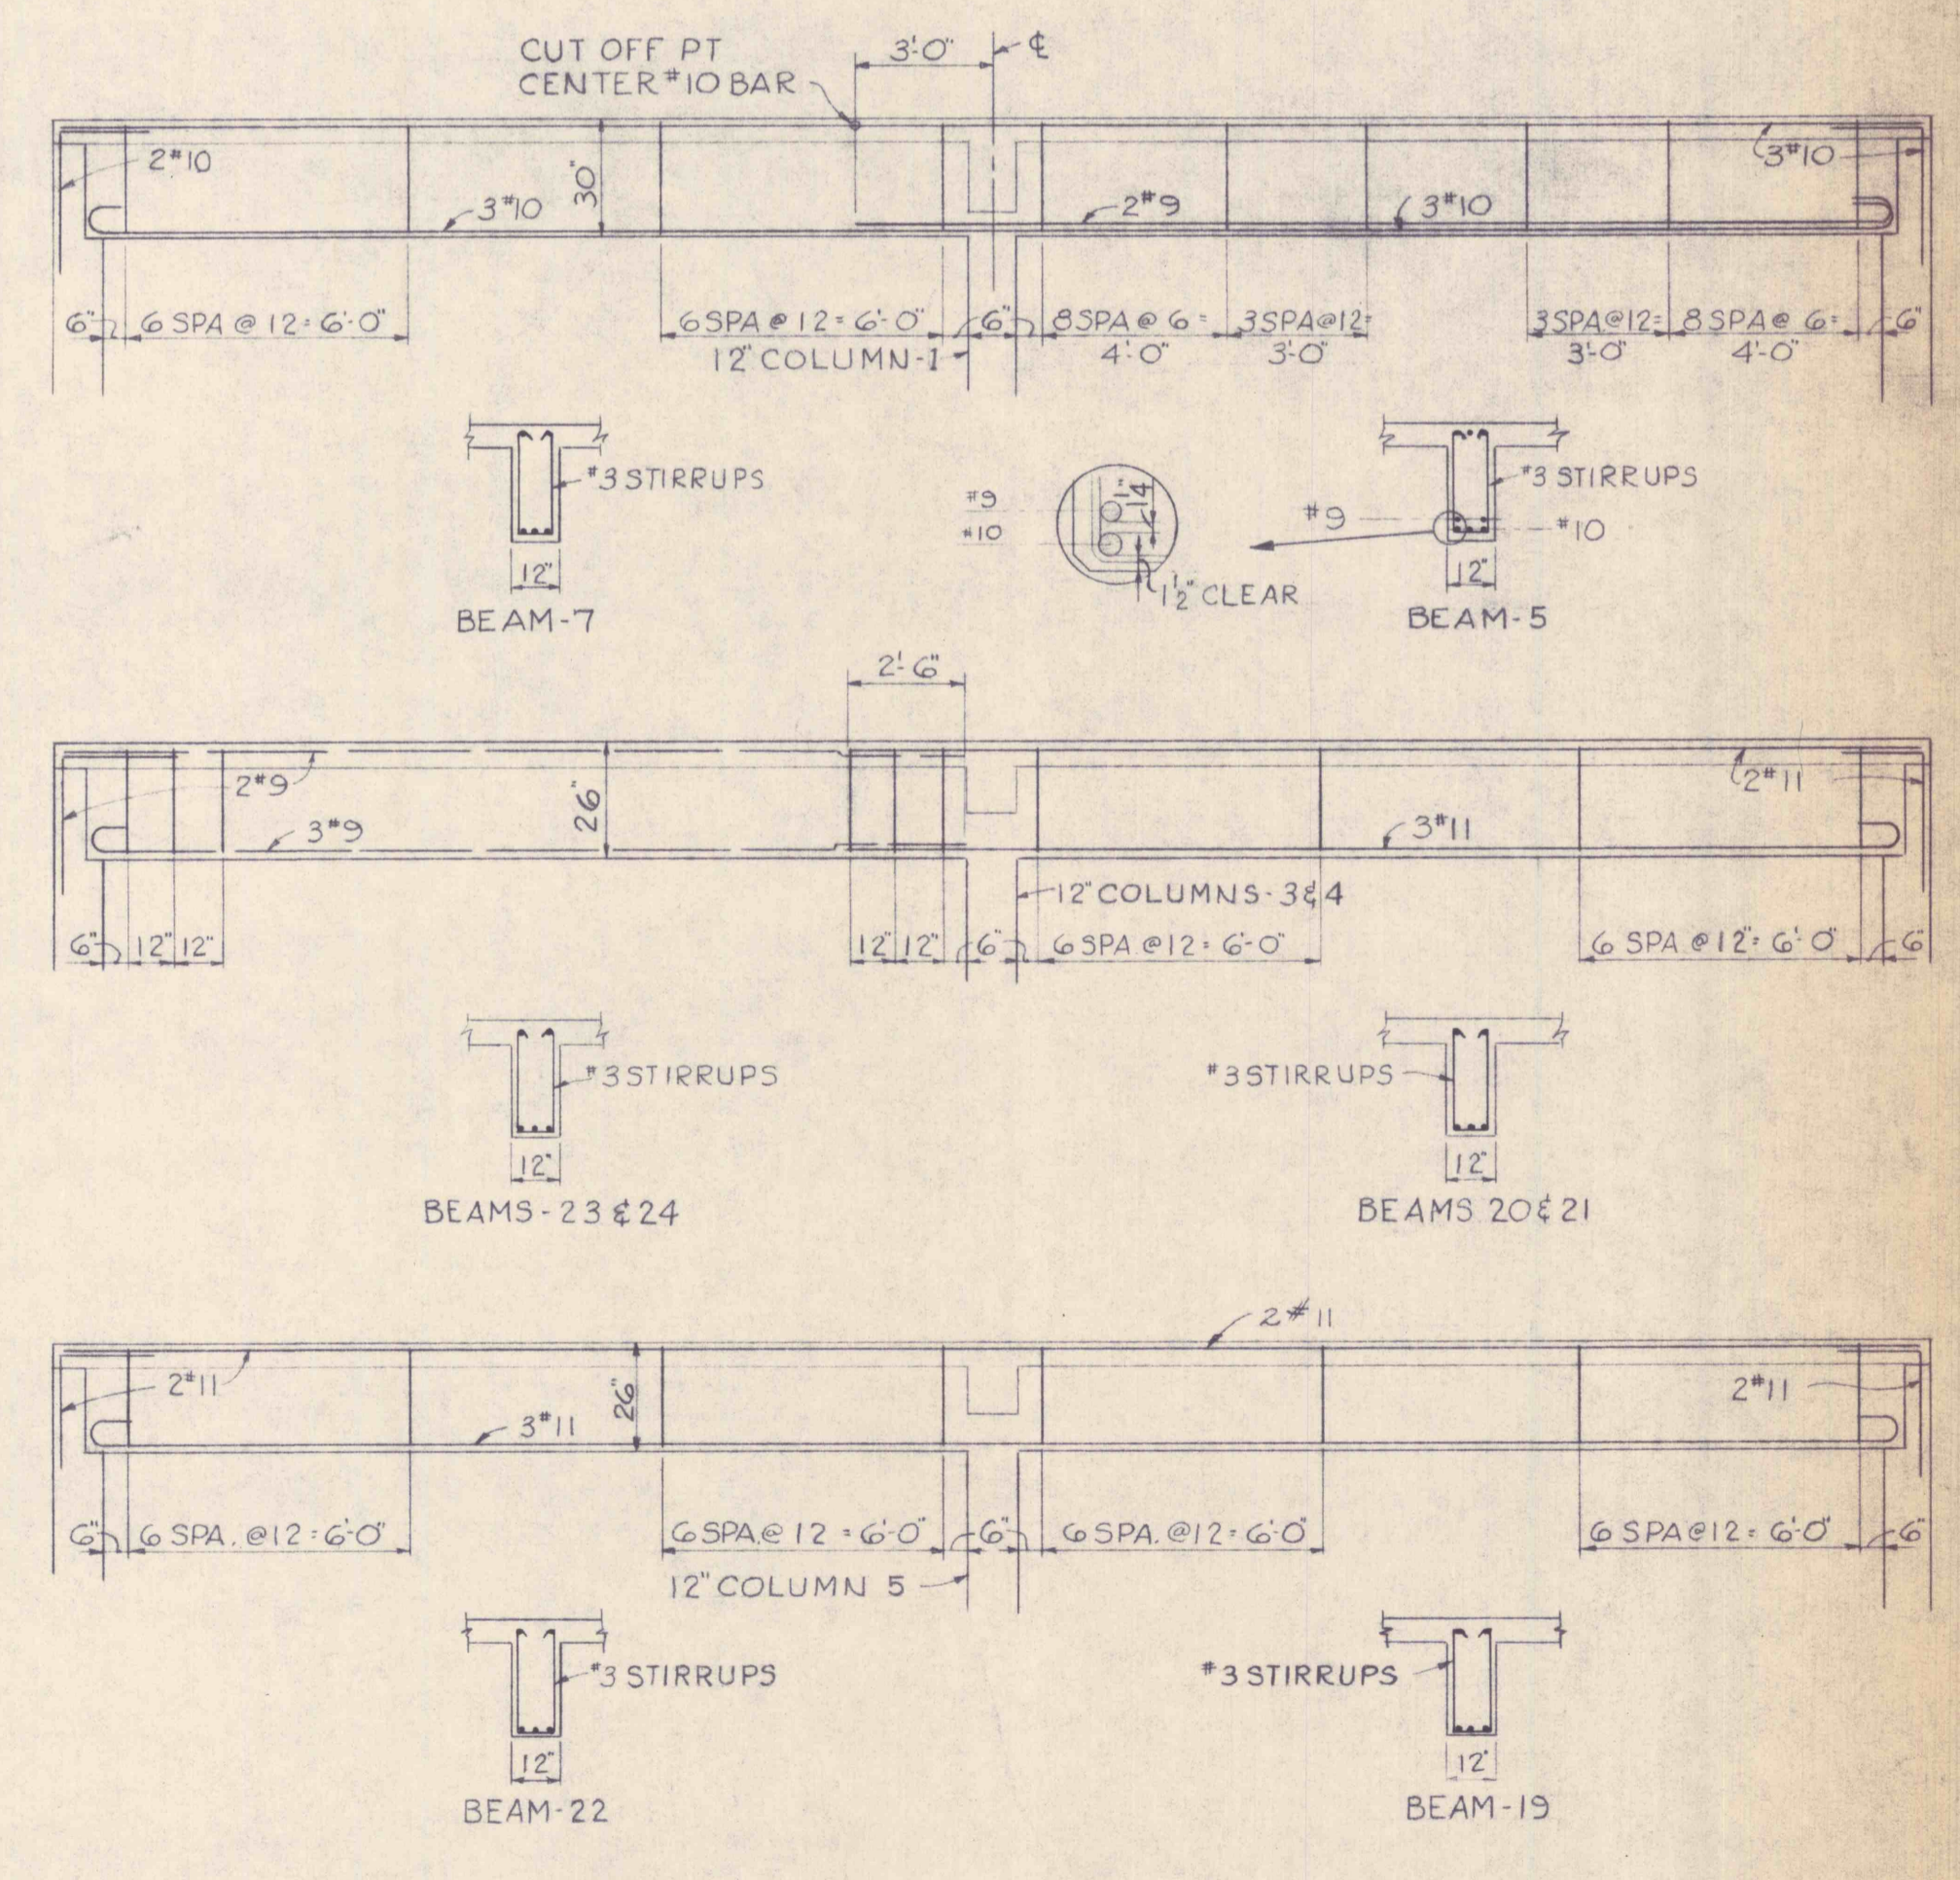

REVISIONS			
NO.	DESCRIPTION	DATE	BY



DRAWN J.B.S. TRACED J.B.S. CHECKED C.K.M. APPROVED G.G.B. APPROVED	GANNETT FLEMING CORDDRY & CARPENTER, INC. ENGINEERS		JOB No. 4590	THE PENNSYLVANIA STATE UNIVERSITY CONSTRUCTION OF A MINE DRAINAGE TREATMENT PLANT HUSTON TOWNSHIP, CLEARFIELD CO., PA.	SHEET No. 10
	600 N. SECOND ST. HARRISBURG, PENNA.		SCALE 1/4" = 1'-0"	CONTROL BUILDING STRUCTURAL	DRAWING No. I-17519
	DATE JUNE 1967		DATE JUNE 1967		
	APPROVED <i>(Signature)</i>		APPROVED <i>(Signature)</i>		APPROVED <i>(Signature)</i>