




PUMPING STATION
GROUND FLOOR PLAN
STRUCTURAL
SCALE 3/8"=1'-0"

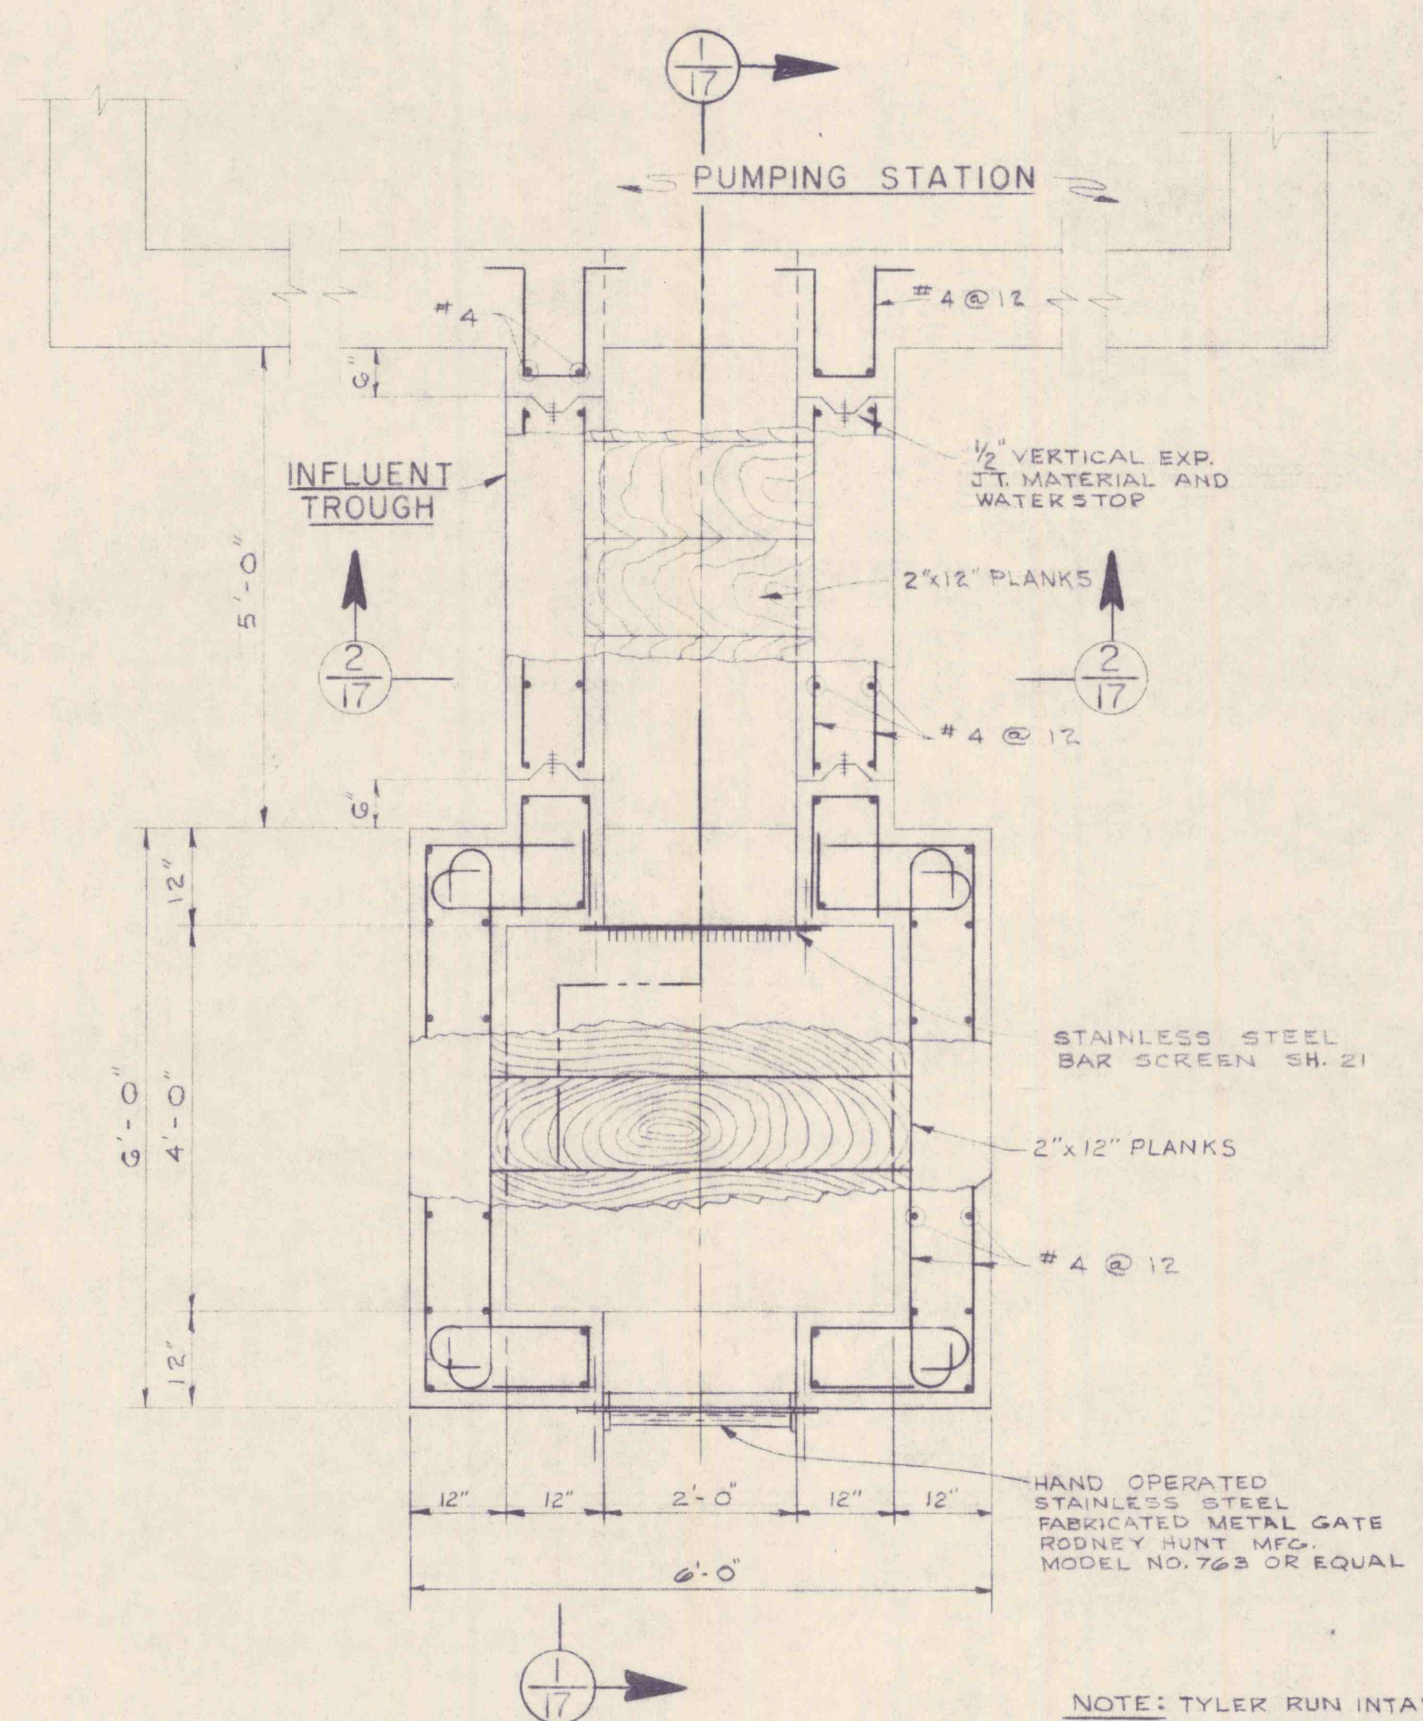


PLAN-PROCTOR NO. 2
INTAKE STRUCTURE
SCALE 1/2"=1'-0"

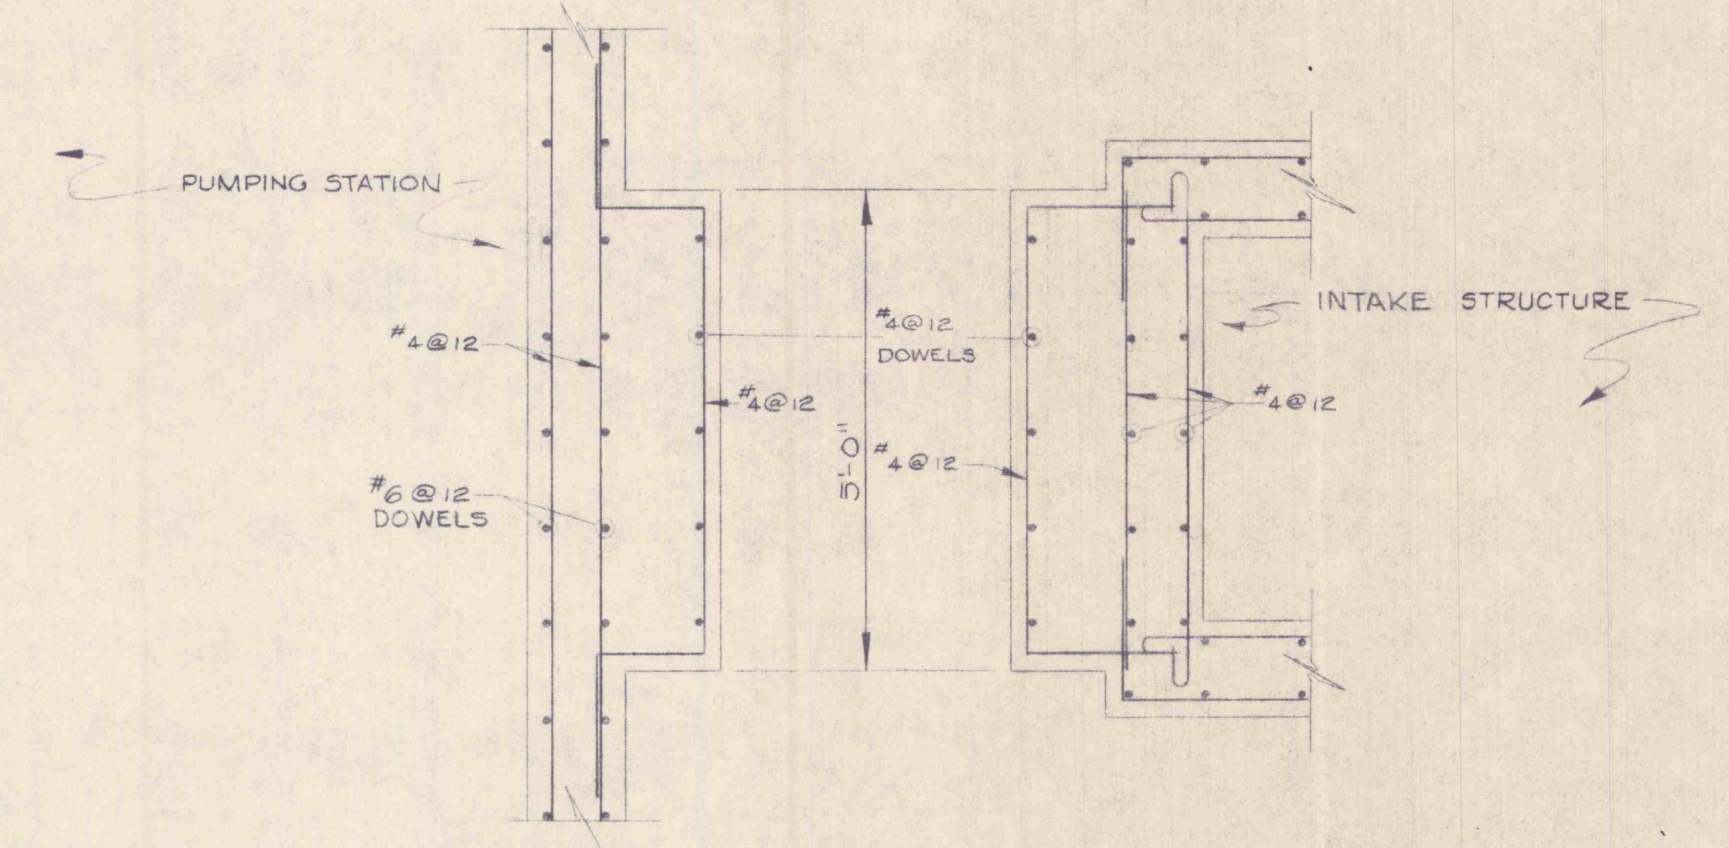


PLAN AT ELEV. 1195.0
SCALE 1/2"=1'-0"

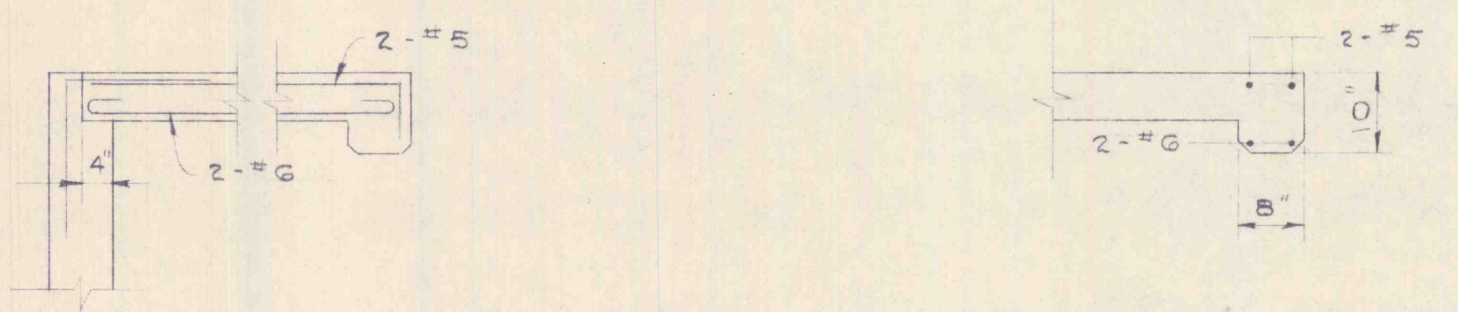


8" x 10" BEAM DETAILS
NO SCALE

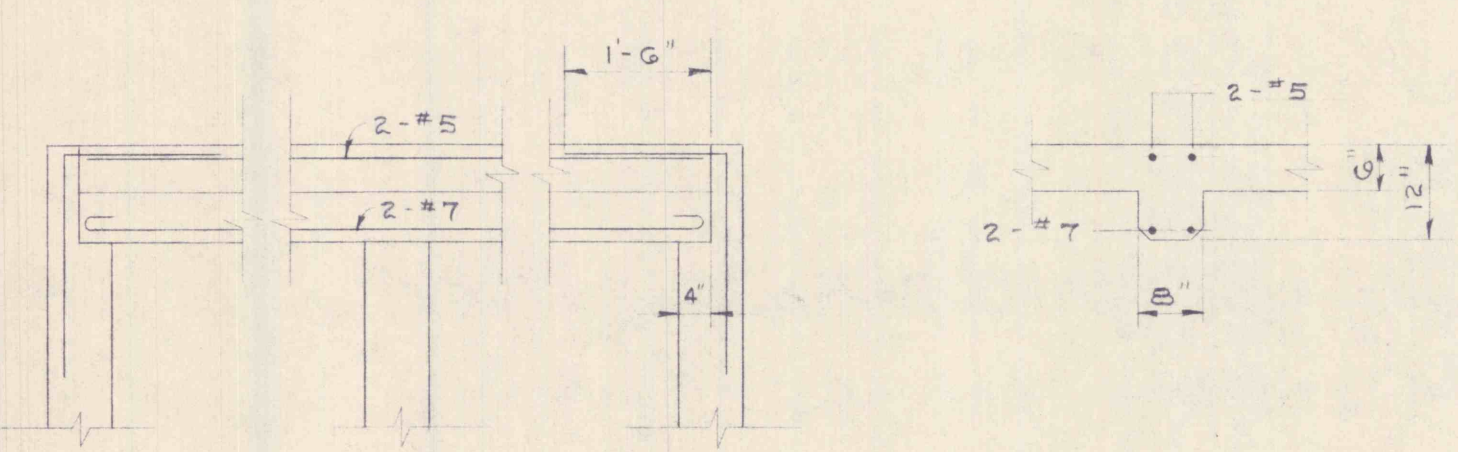


8" x 12" BEAM DETAILS
NO SCALE

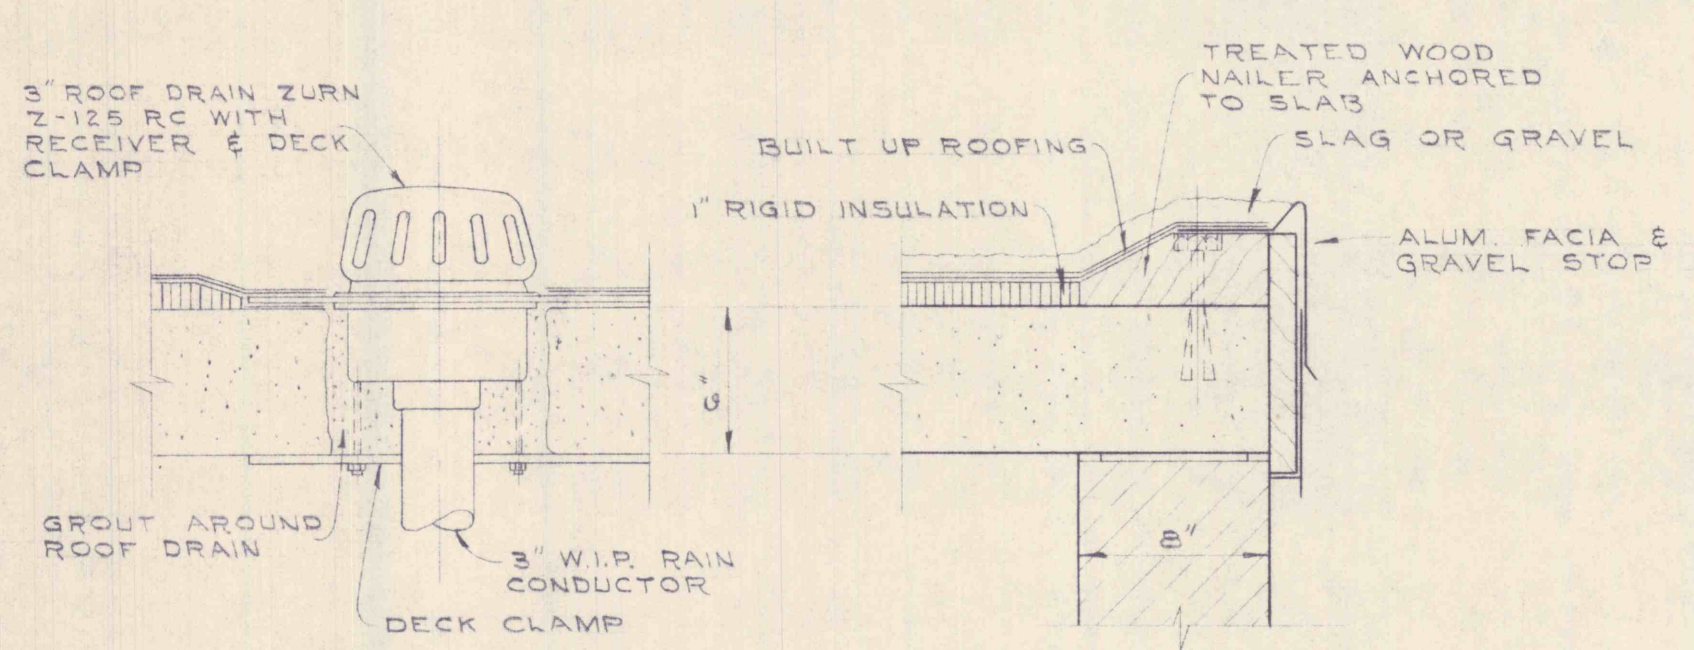


FACIA GRAVEL STOP
& ROOF DRAIN DETAIL

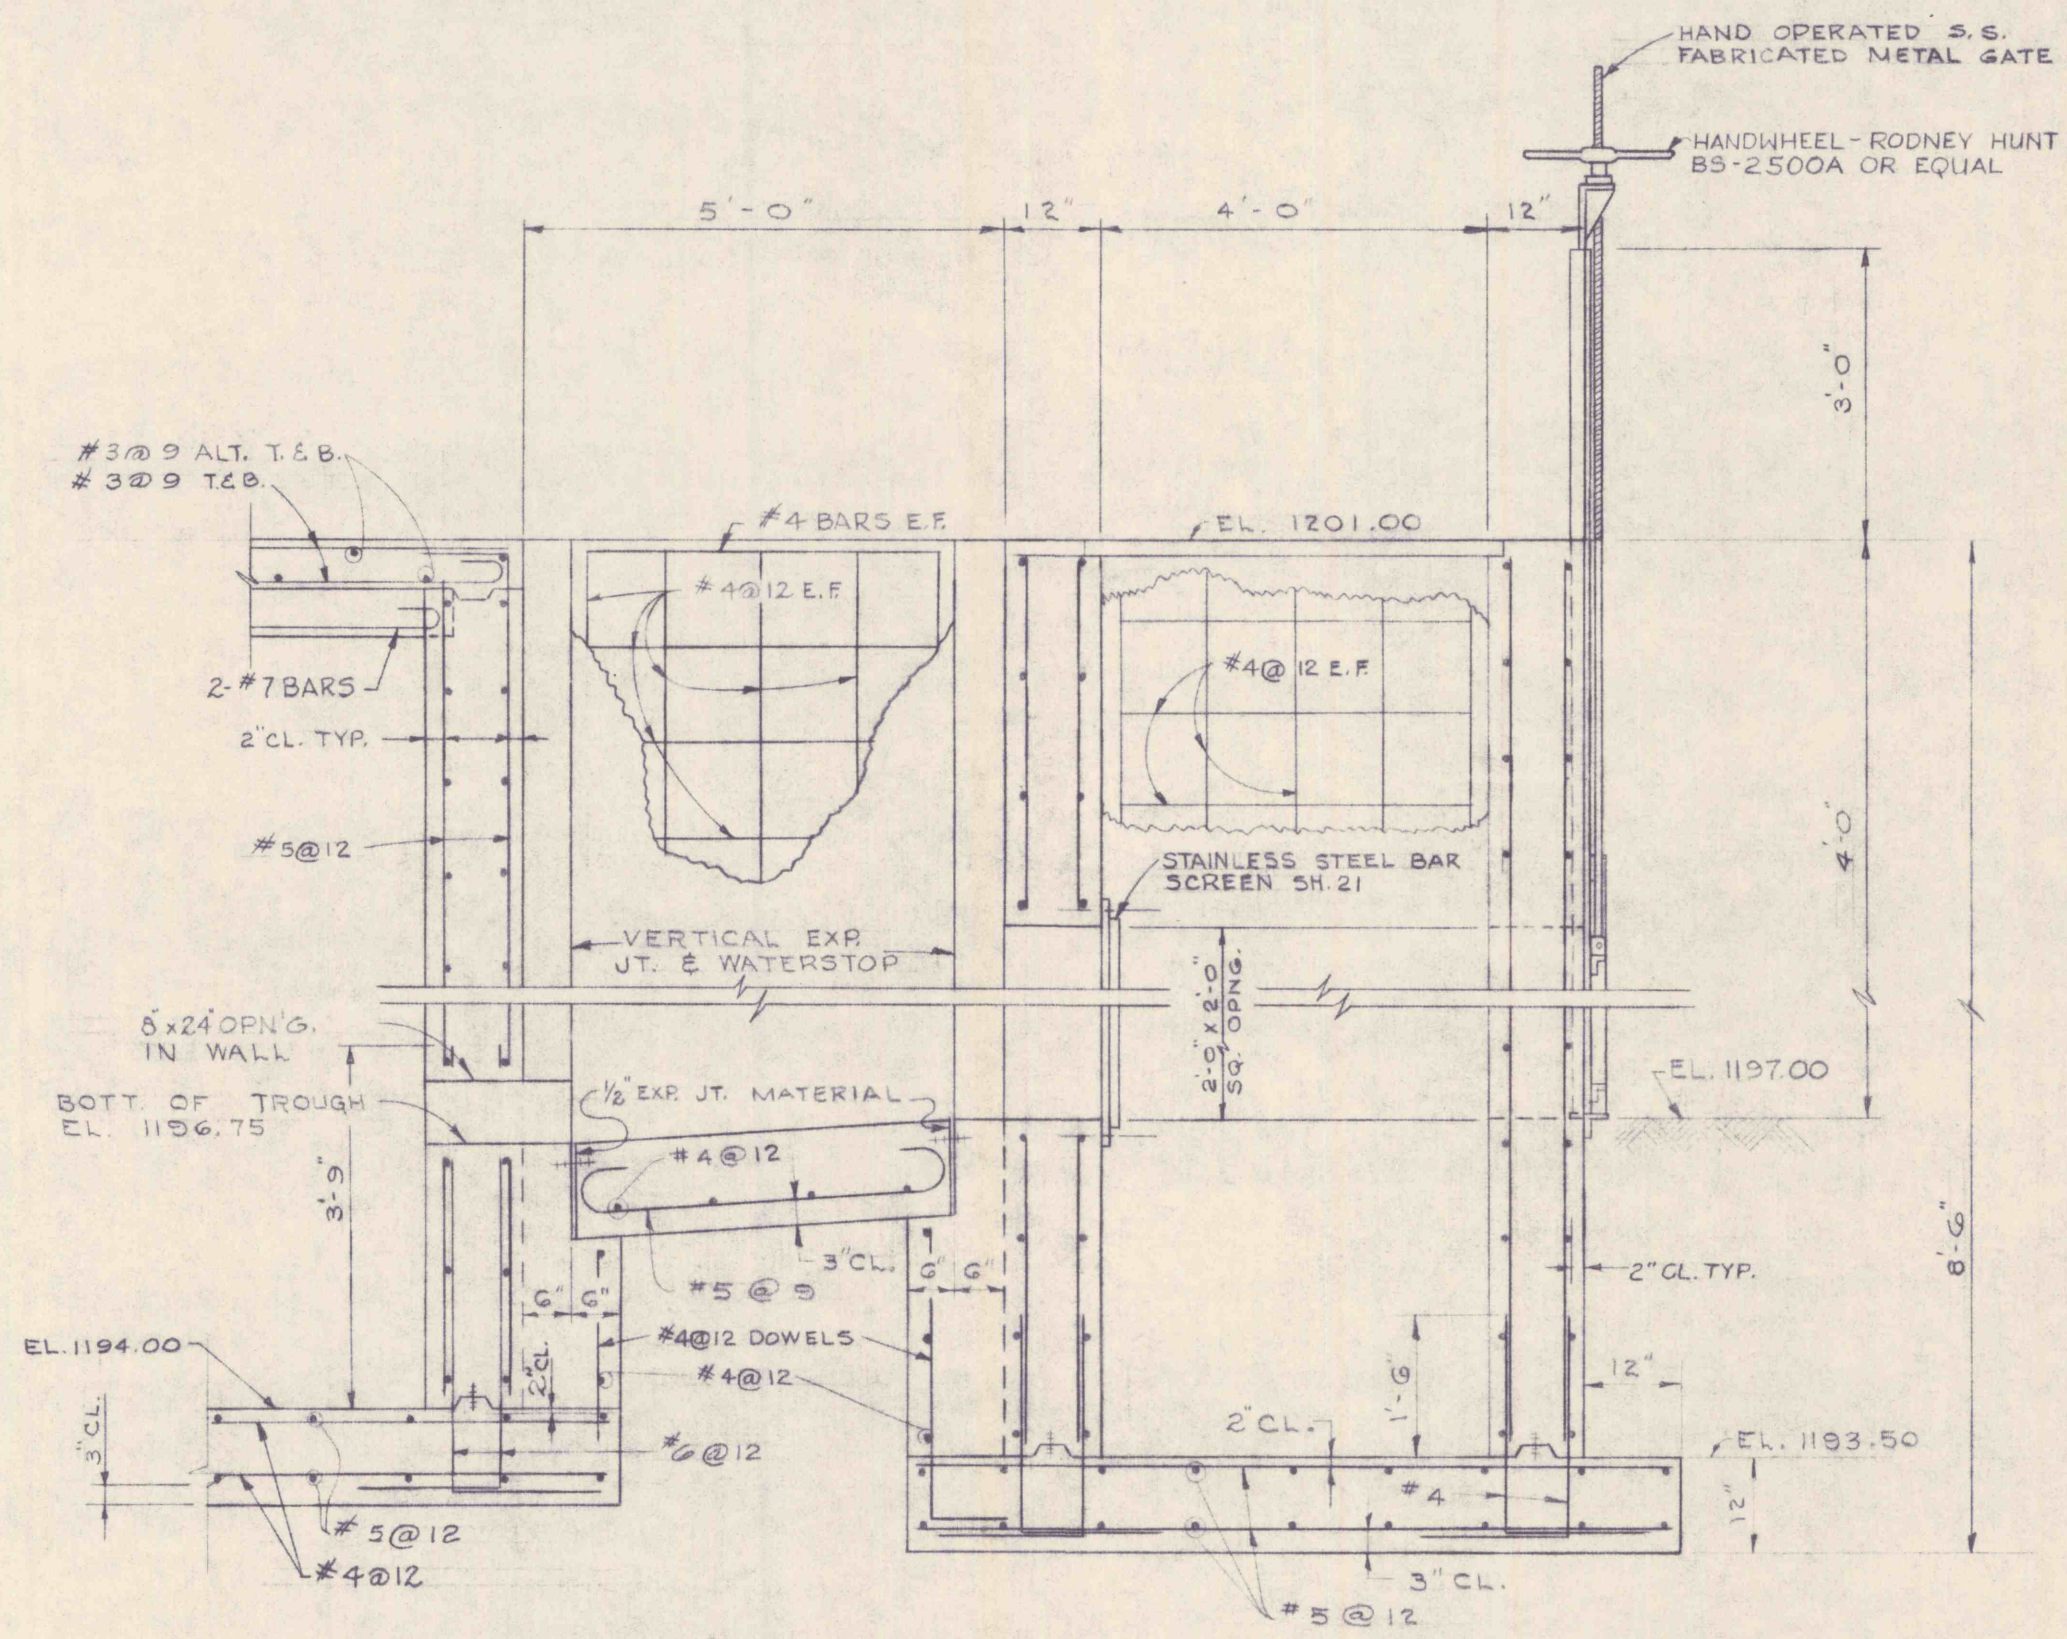

SECTION 1/17
SCALE 1/2"=1'-0"

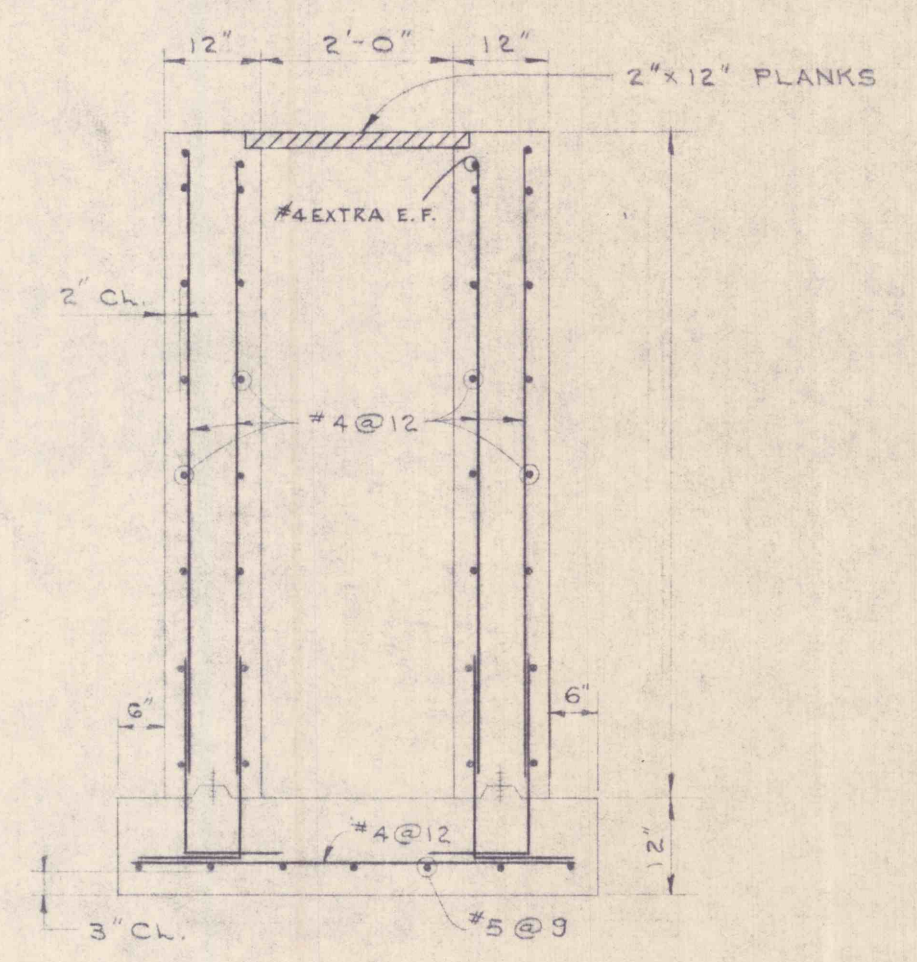

SECTION 2/17
SCALE 1/2"=1'-0"

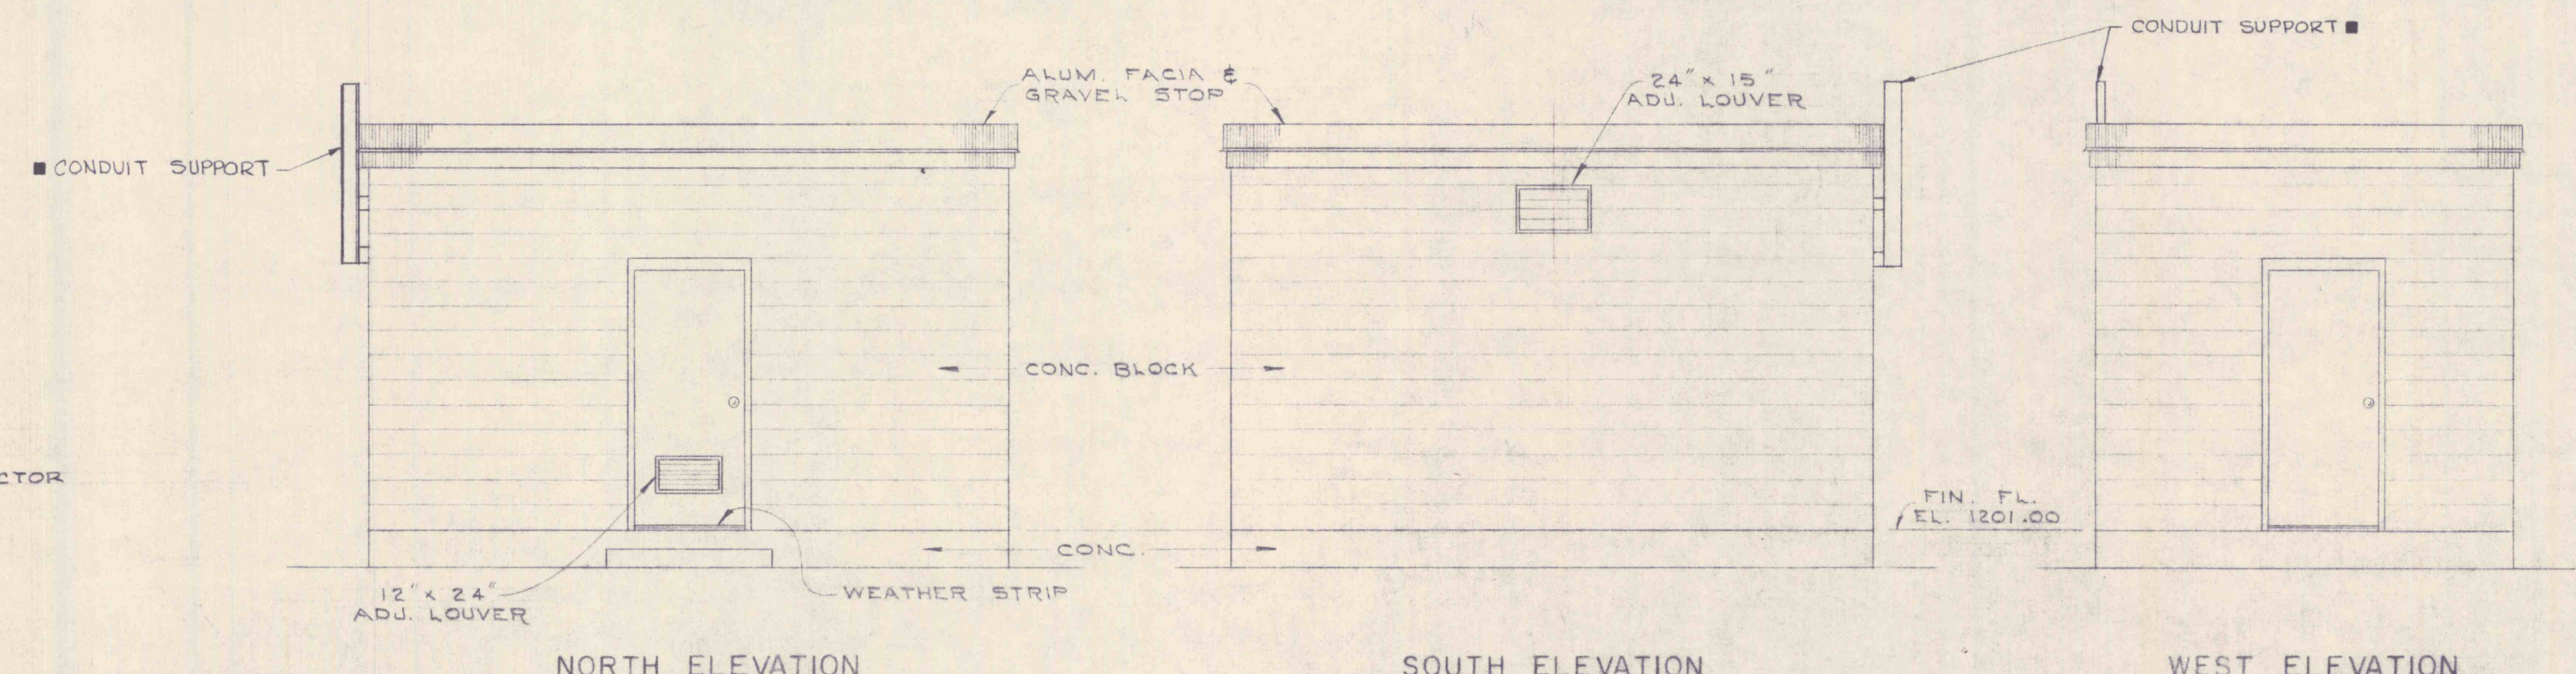

NORTH ELEVATION

SOUTH ELEVATION
SCALE 1/4"=1'-0"

WEST ELEVATION

LEGEND
■ BY ELECTRICAL CONTRACTOR

REVISIONS			
NO.	DESCRIPTION	DATE	BY



DRAWN G.E. TRACED G.E. CHECKED C.K.M. APPROVED G.G.B. APPROVED	GANNETT FLEMING CORDDRY & CARPENTER, INC. ENGINEERS 600 N. SECOND ST. HARRISBURG, PENNA.	JOB NO. 4590	THE PENNSYLVANIA STATE UNIVERSITY CONSTRUCTION OF A MINE DRAINAGE TREATMENT PLANT HUSTON TOWNSHIP, CLEARFIELD CO., PA.	SHEET NO. 17
		SCALE AS SHOWN		DATE JUNE 1967