

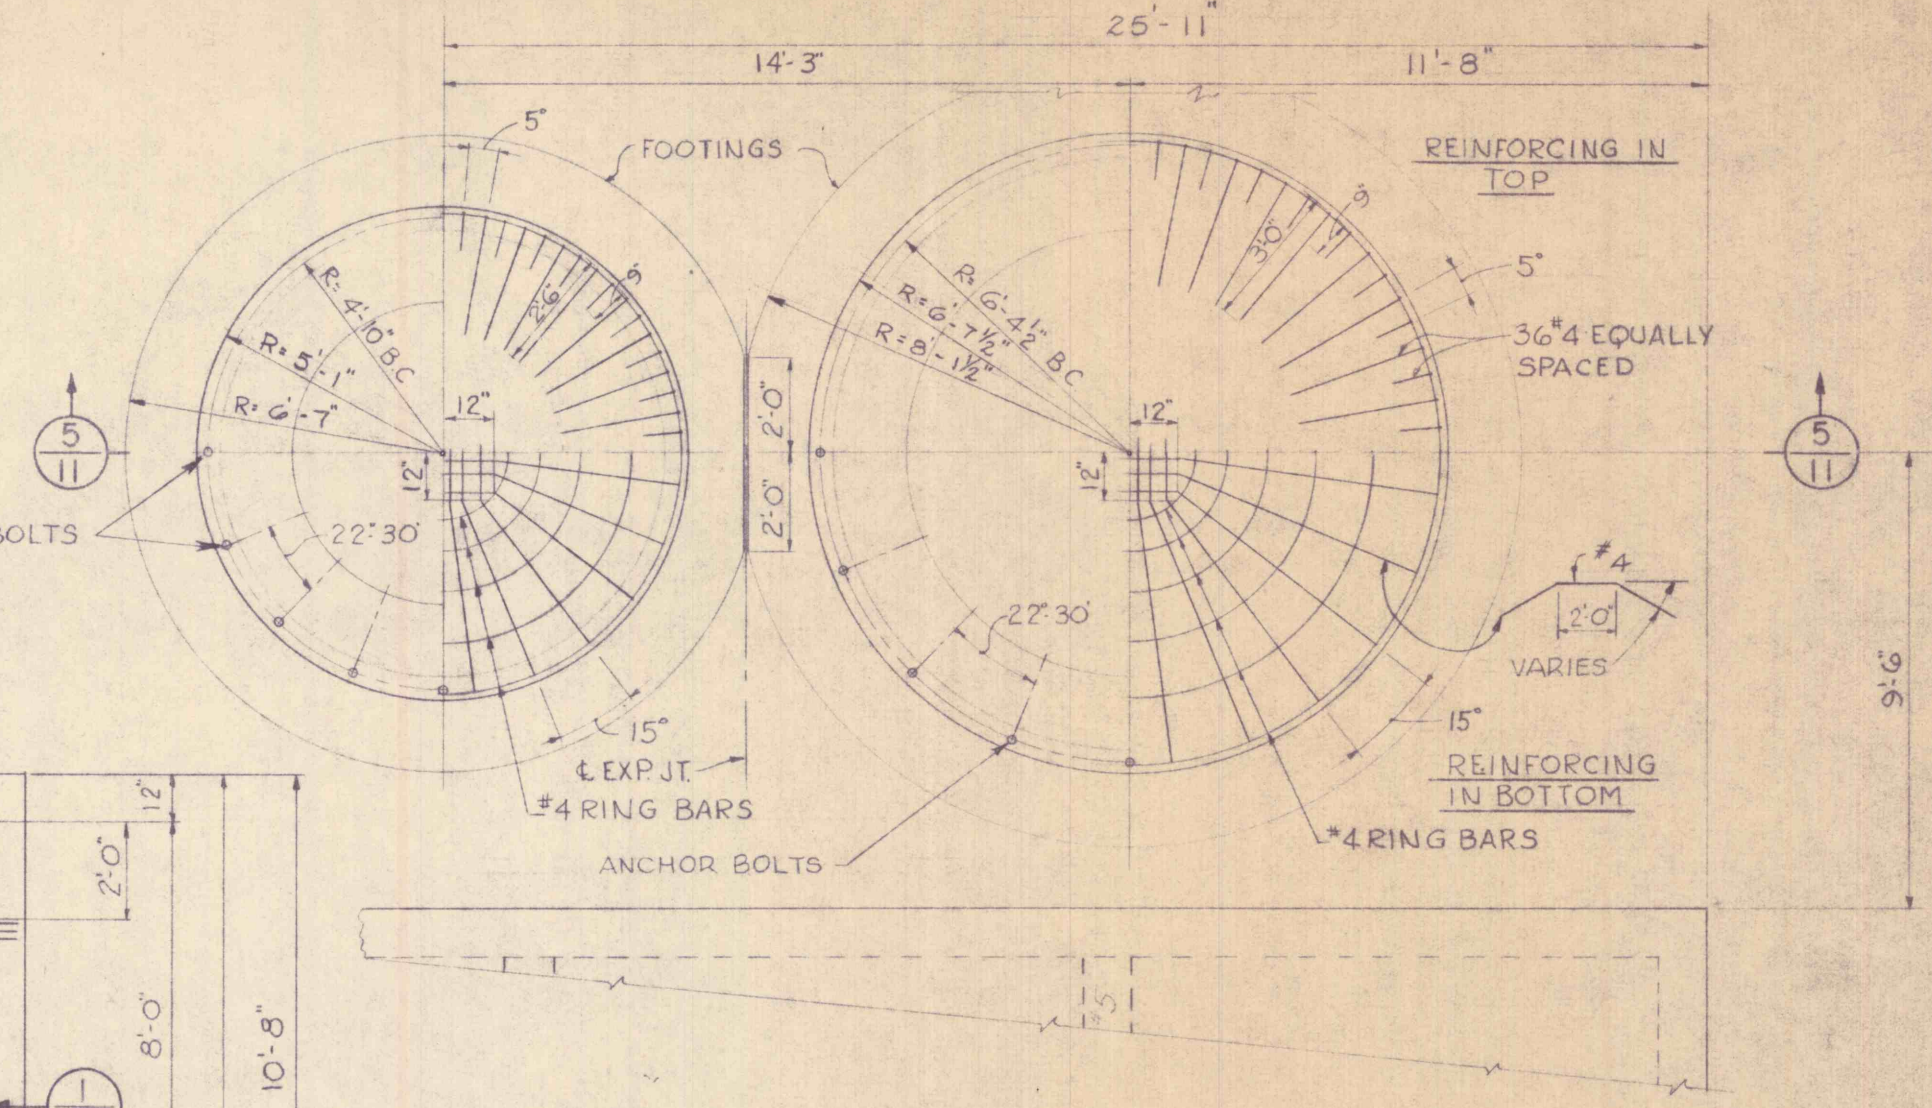



GROUND FLOOR PLAN

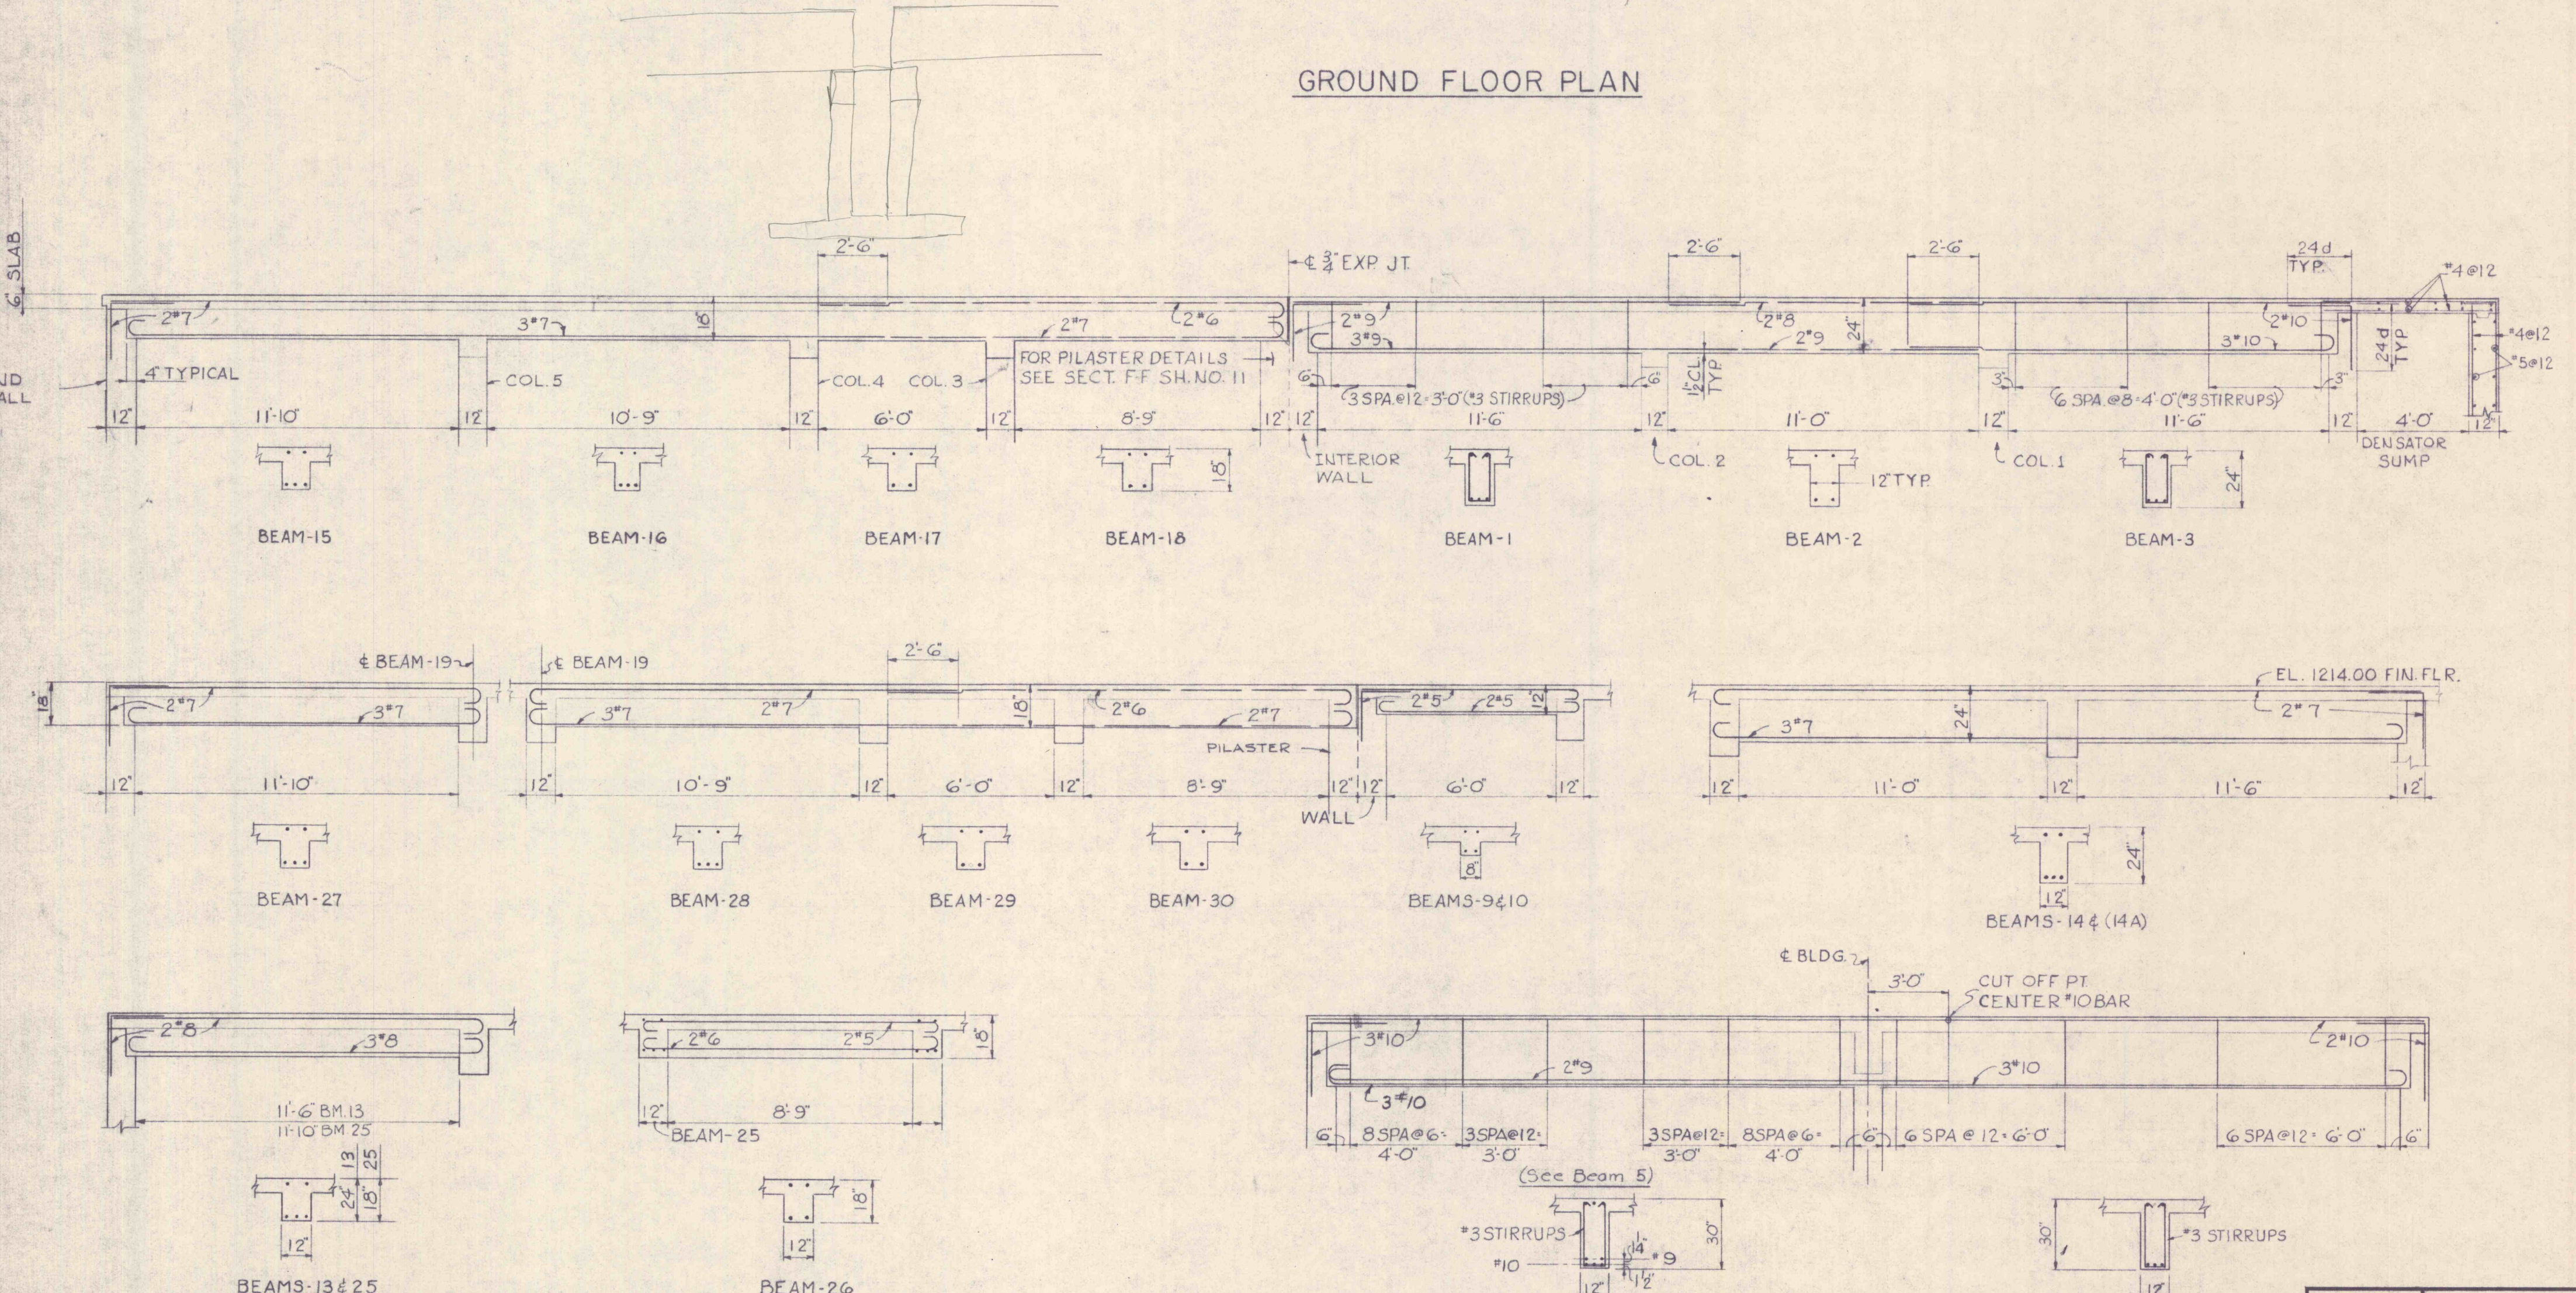

LIME STORAGE TANK FOUNDATION PLANS

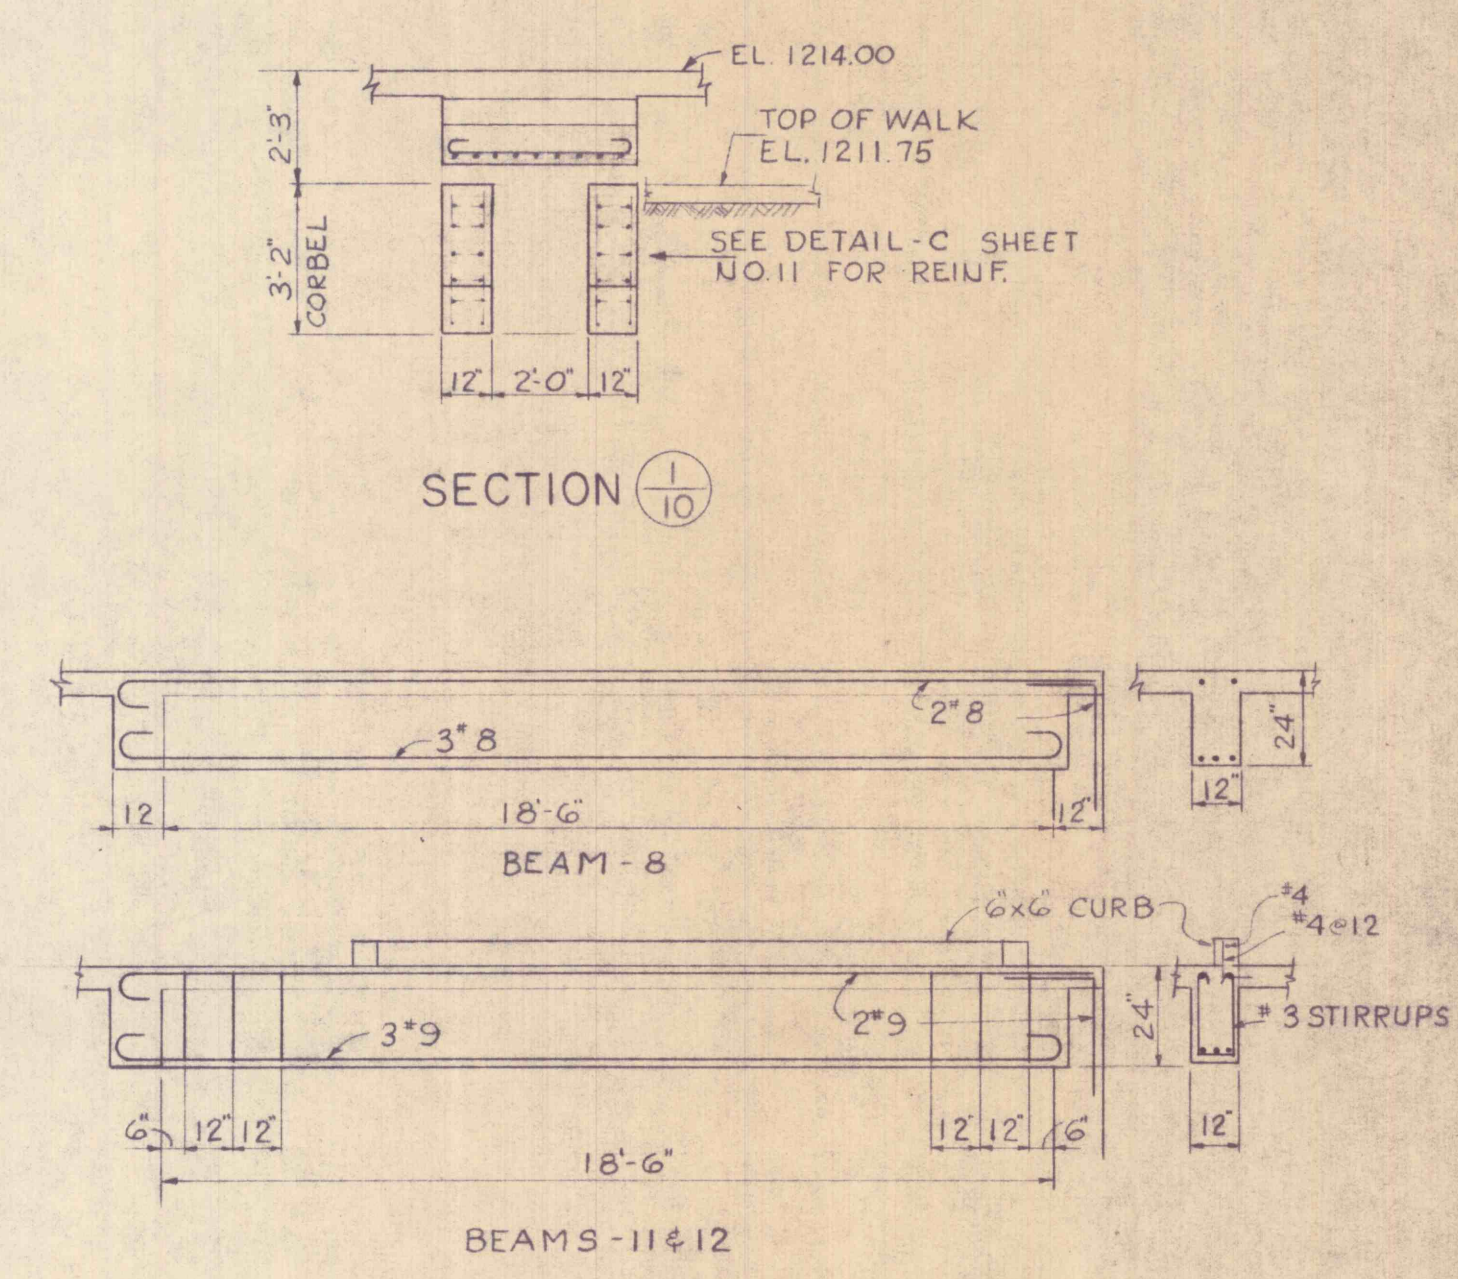

BEAM DETAILS

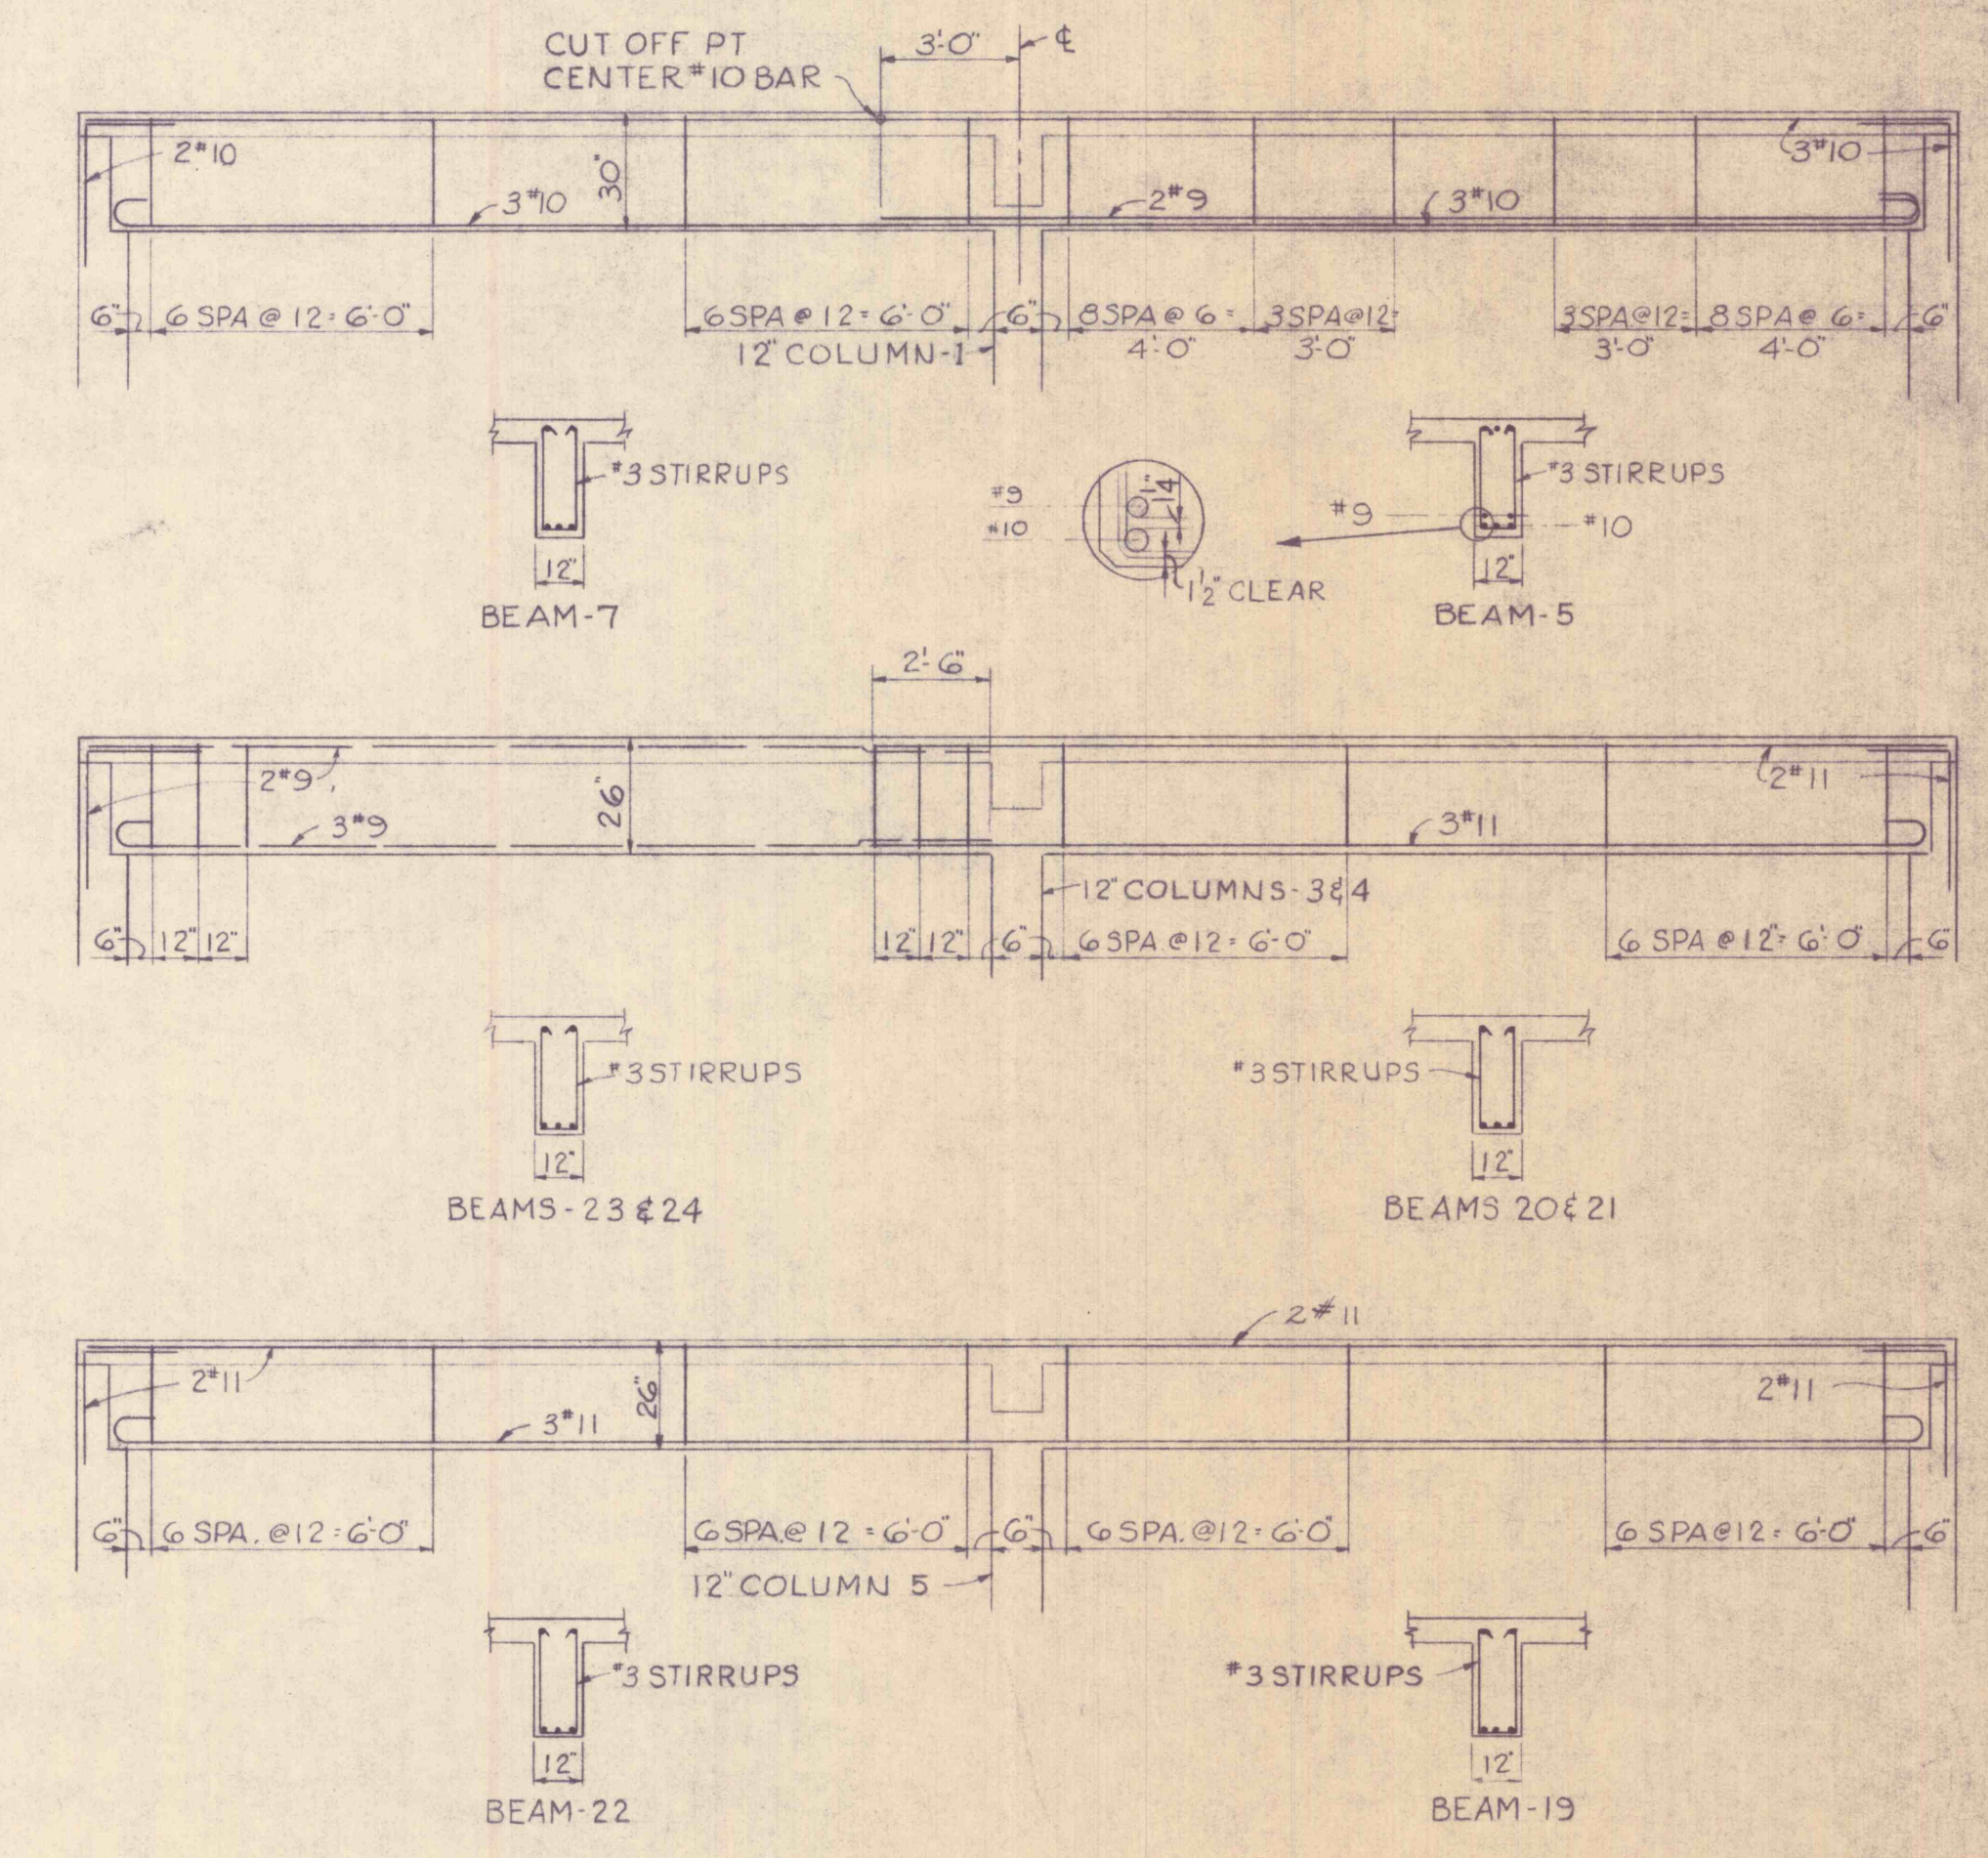

REVISIONS			
NO.	DESCRIPTION	DATE	BY

DRAWN J.B.S. TRACED J.B.S. CHECKED C.K.M. APPROVED G.G.B. APPROVED	<b>GANNETT FLEMING CORDRY &amp; CARPENTER, INC.</b> <b>ENGINEERS</b>		JOB No. <b>4590</b>	THE PENNSYLVANIA STATE UNIVERSITY CONSTRUCTION OF A MINE DRAINAGE TREATMENT PLANT HUSTON TOWNSHIP, CLEARFIELD CO., PA.	SHEET No. <b>10</b>
	600 N. SECOND ST.      HARRISBURG, PENNA.		SCALE 1/4" = 1'-0"	<b>CONTROL BUILDING</b> <b>STRUCTURAL</b>	DRAWING No. I-17519
	DATE JUNE 1967				
	CONTROL BUILDING STRUCTURAL				