





GROUND FLOOR PLAN

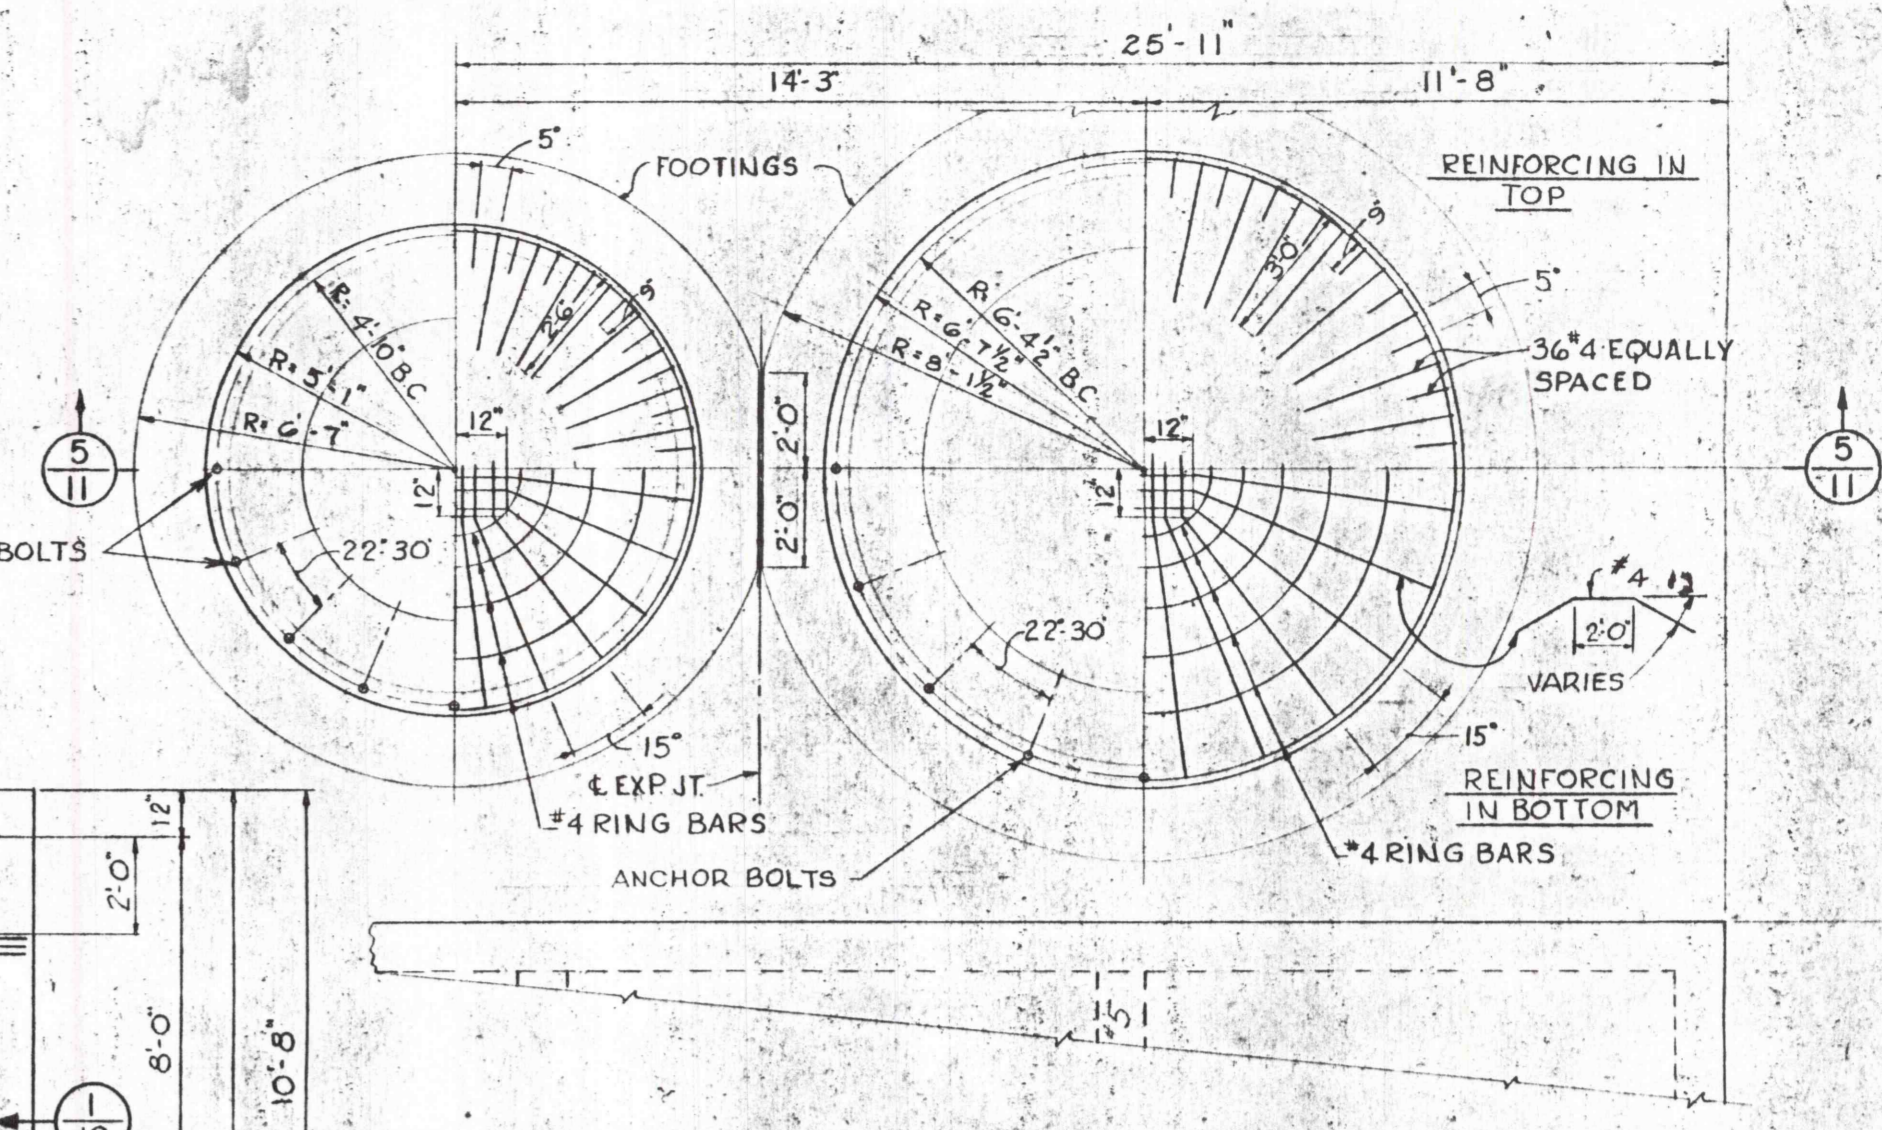


LIME STORAGE TANK FOUNDATION PLANS

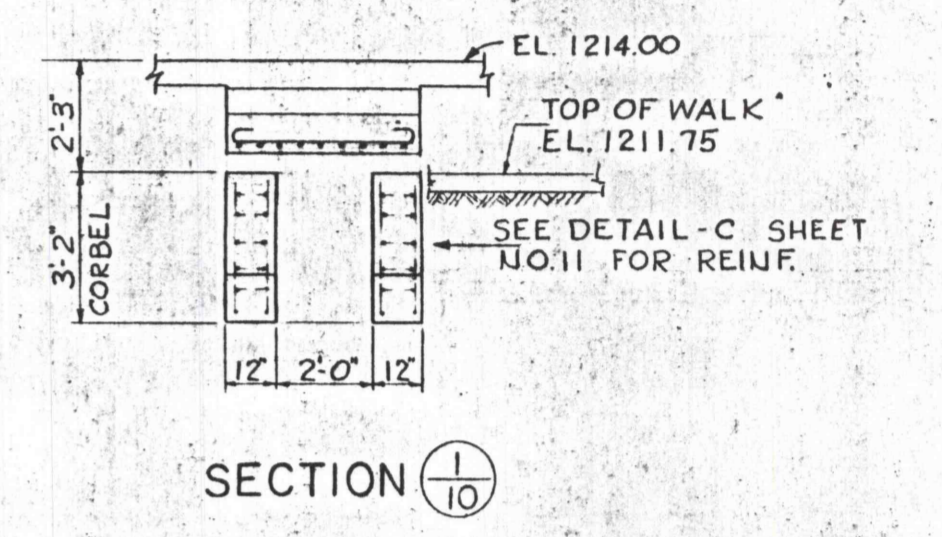


SECTION 10

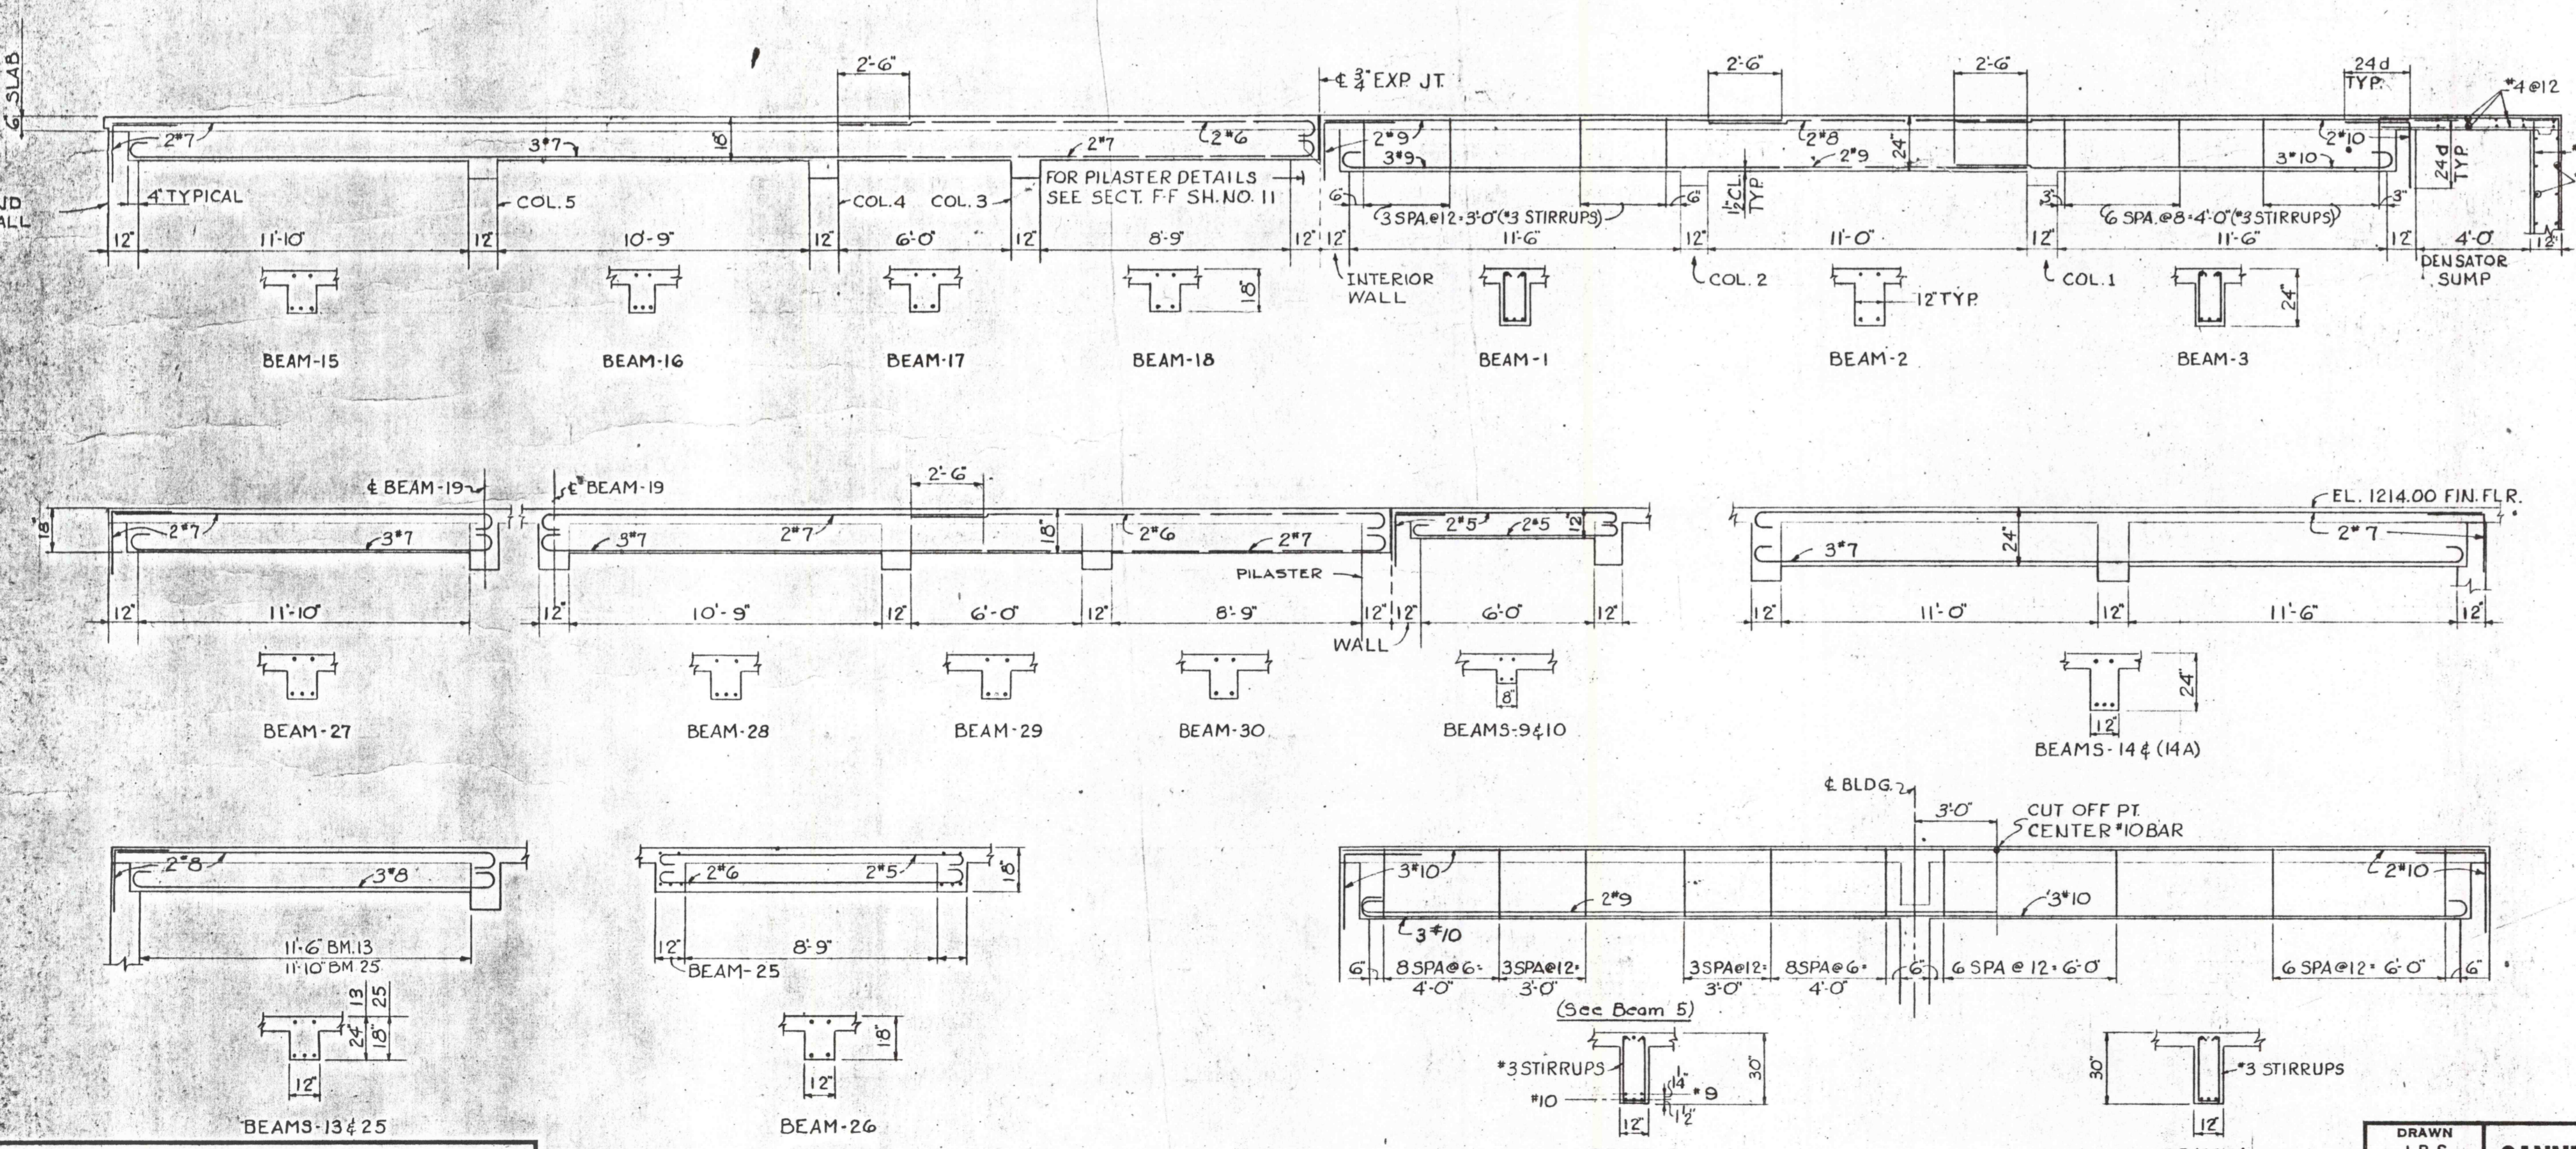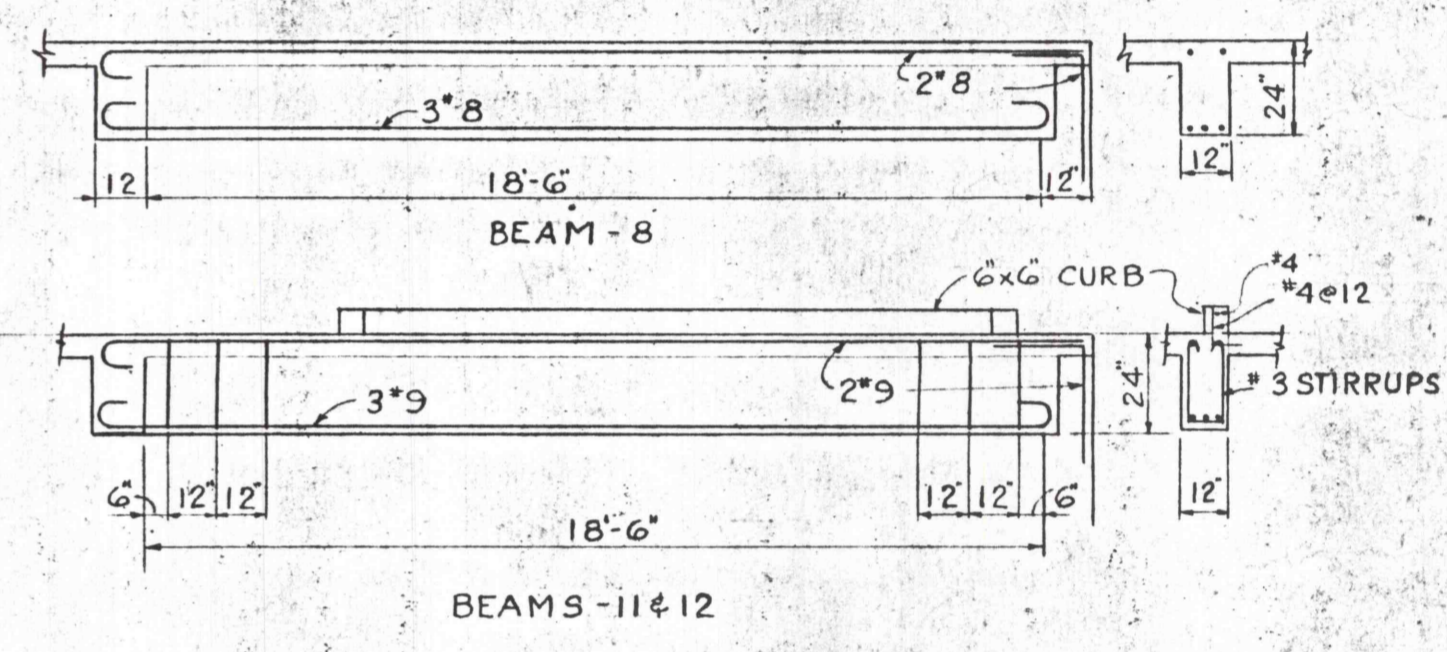

BEAM DETAILS

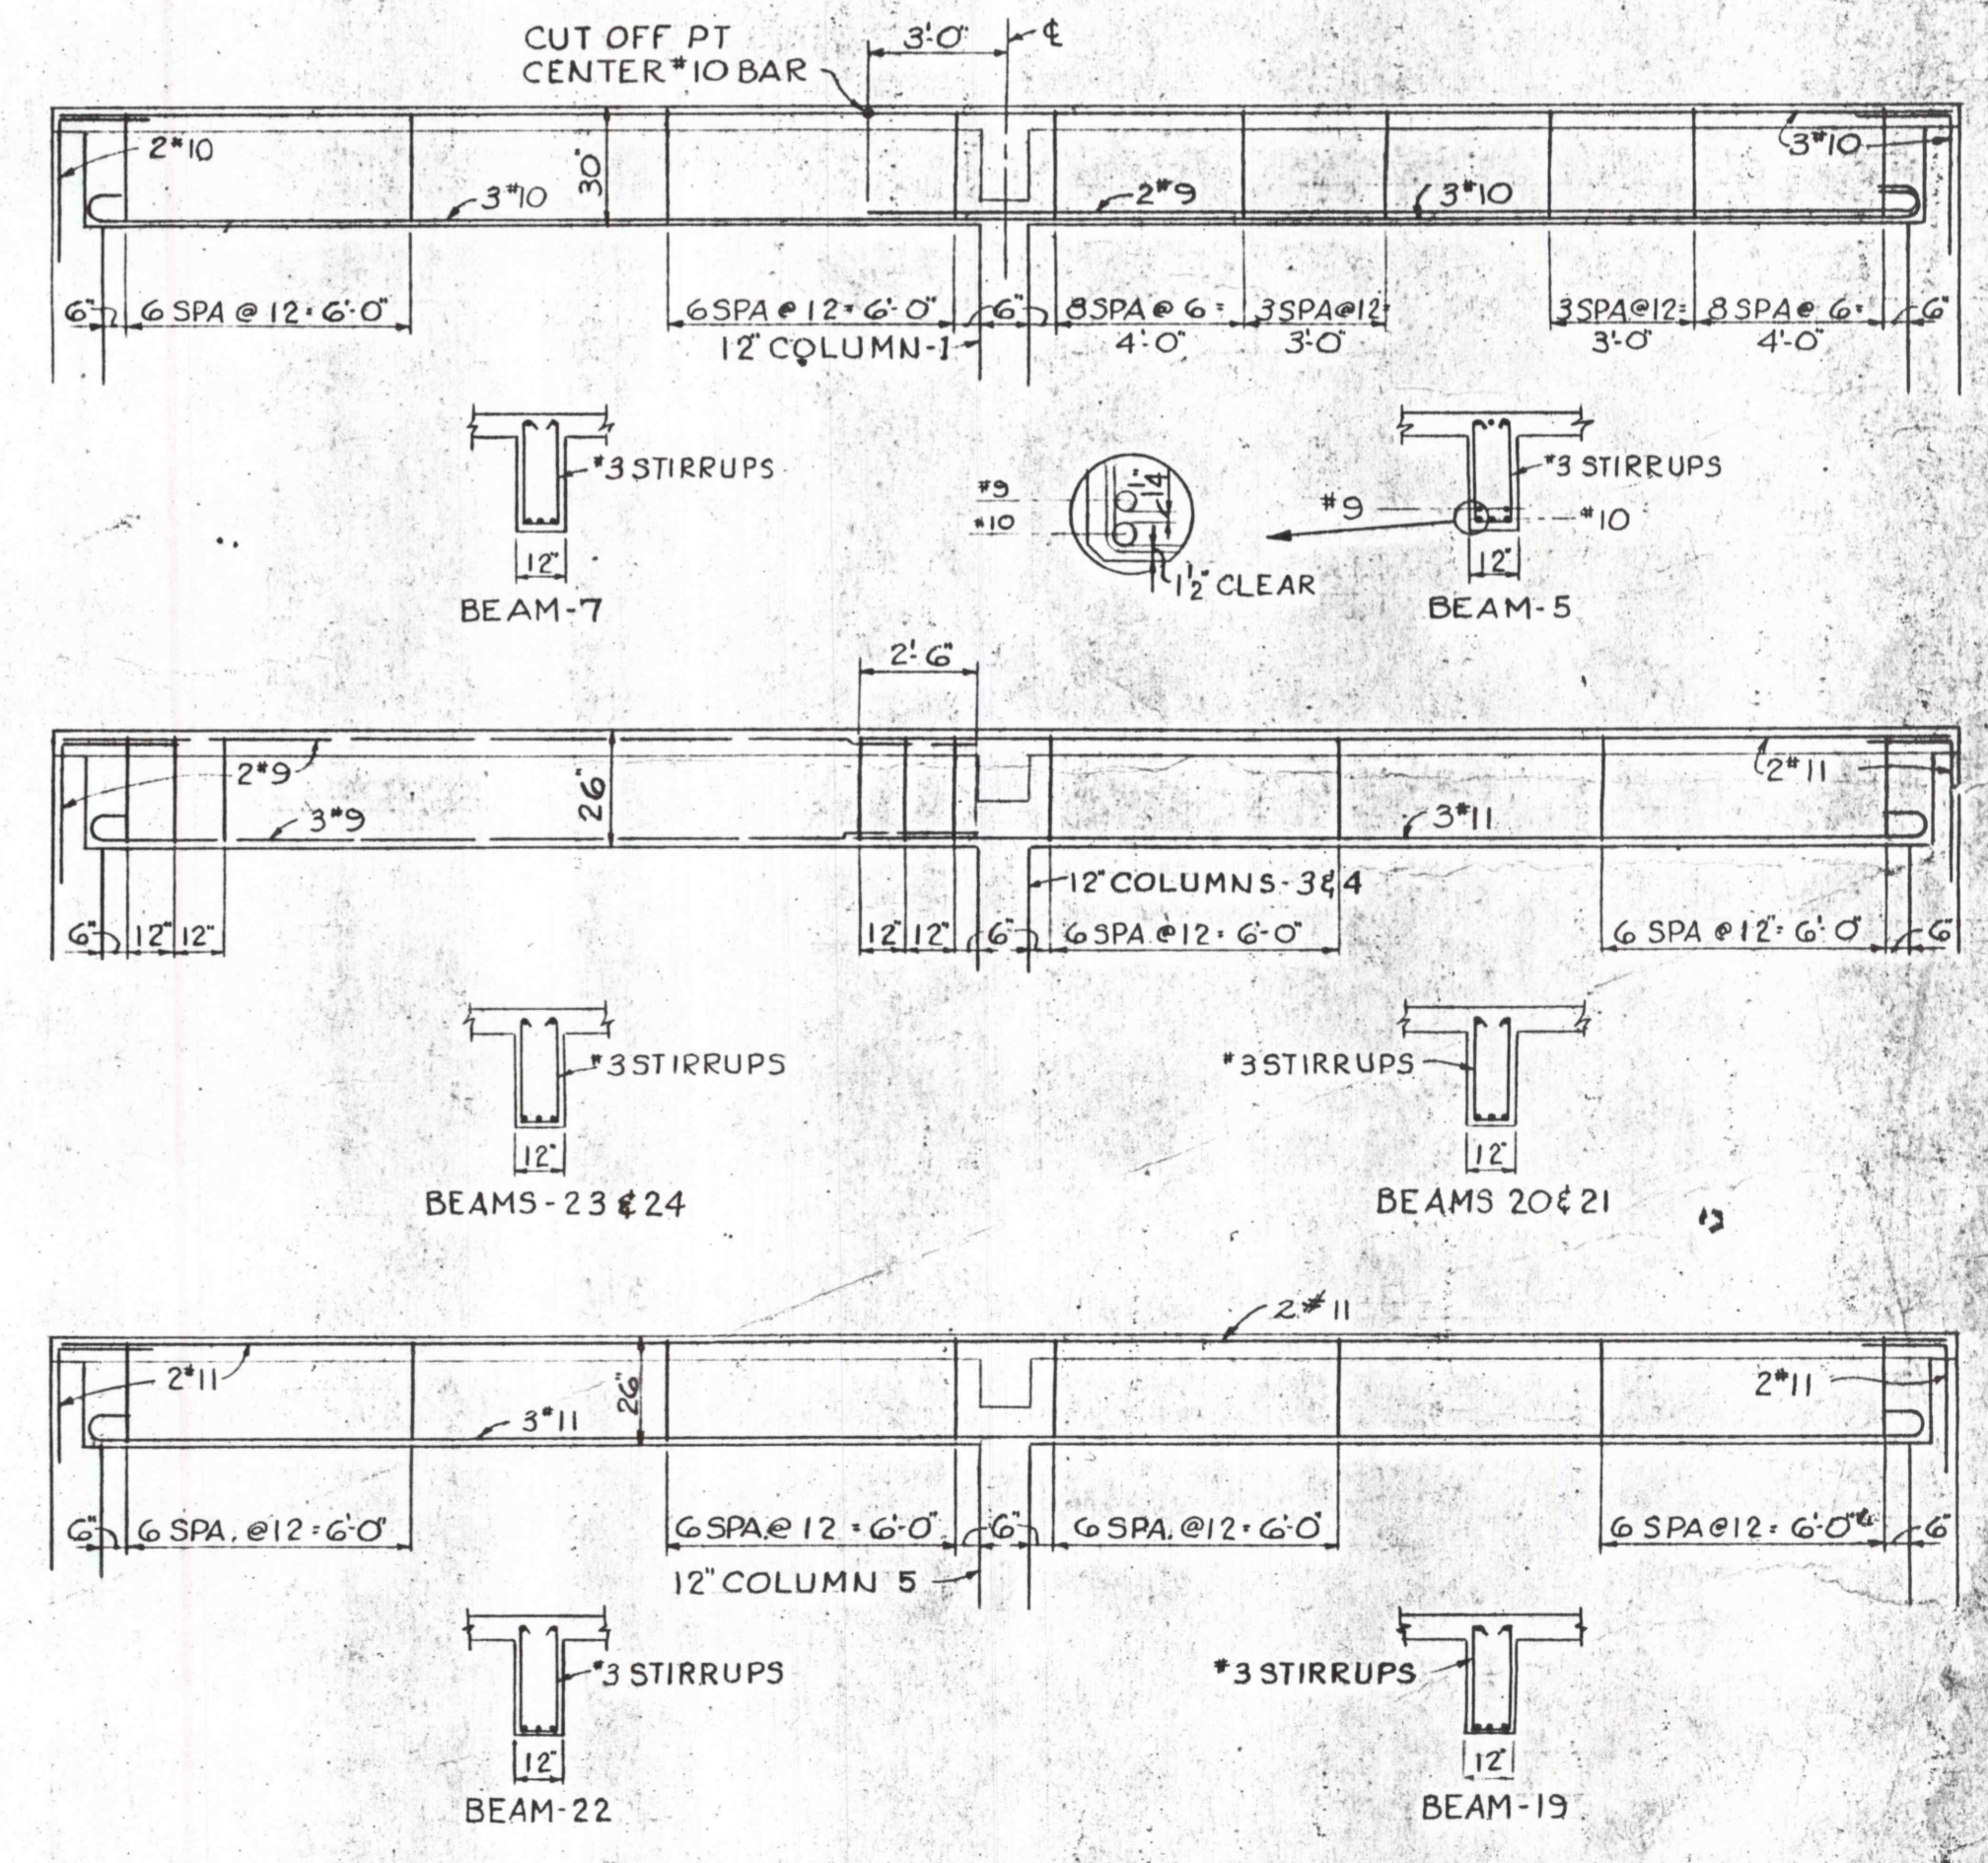

REVISIONS		
NO.	DESCRIPTION	DATE BY

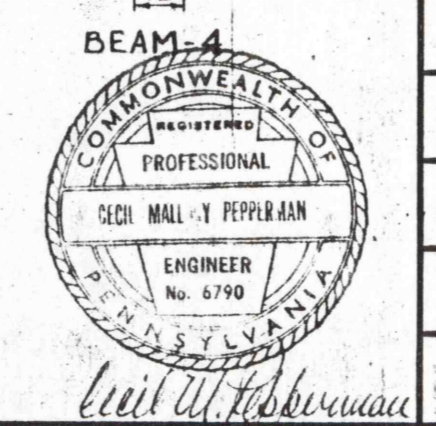

DRAWN J.B.S. TRACED J.B.S. CHECKED C.K.M. APPROVED G.G.B. APPROVED	<b>GANNETT FLEMING CORDDRY &amp; CARPENTER, INC.</b> <b>ENGINEERS</b>		JOB No. <b>4590</b>	THE PENNSYLVANIA STATE UNIVERSITY CONSTRUCTION OF A MINE DRAINAGE TREATMENT PLANT HUSTON TOWNSHIP, CLEARFIELD CO., PA.	SHEET No. <b>10</b>
	600 N. SECOND ST.      HARRISBURG, PENNA.		SCALE 1/4" = 1'-0"	CONTROL BUILDING STRUCTURAL	DRAWING No. I-17519
	DATE JUNE 1967		DATE JUNE 1967		