


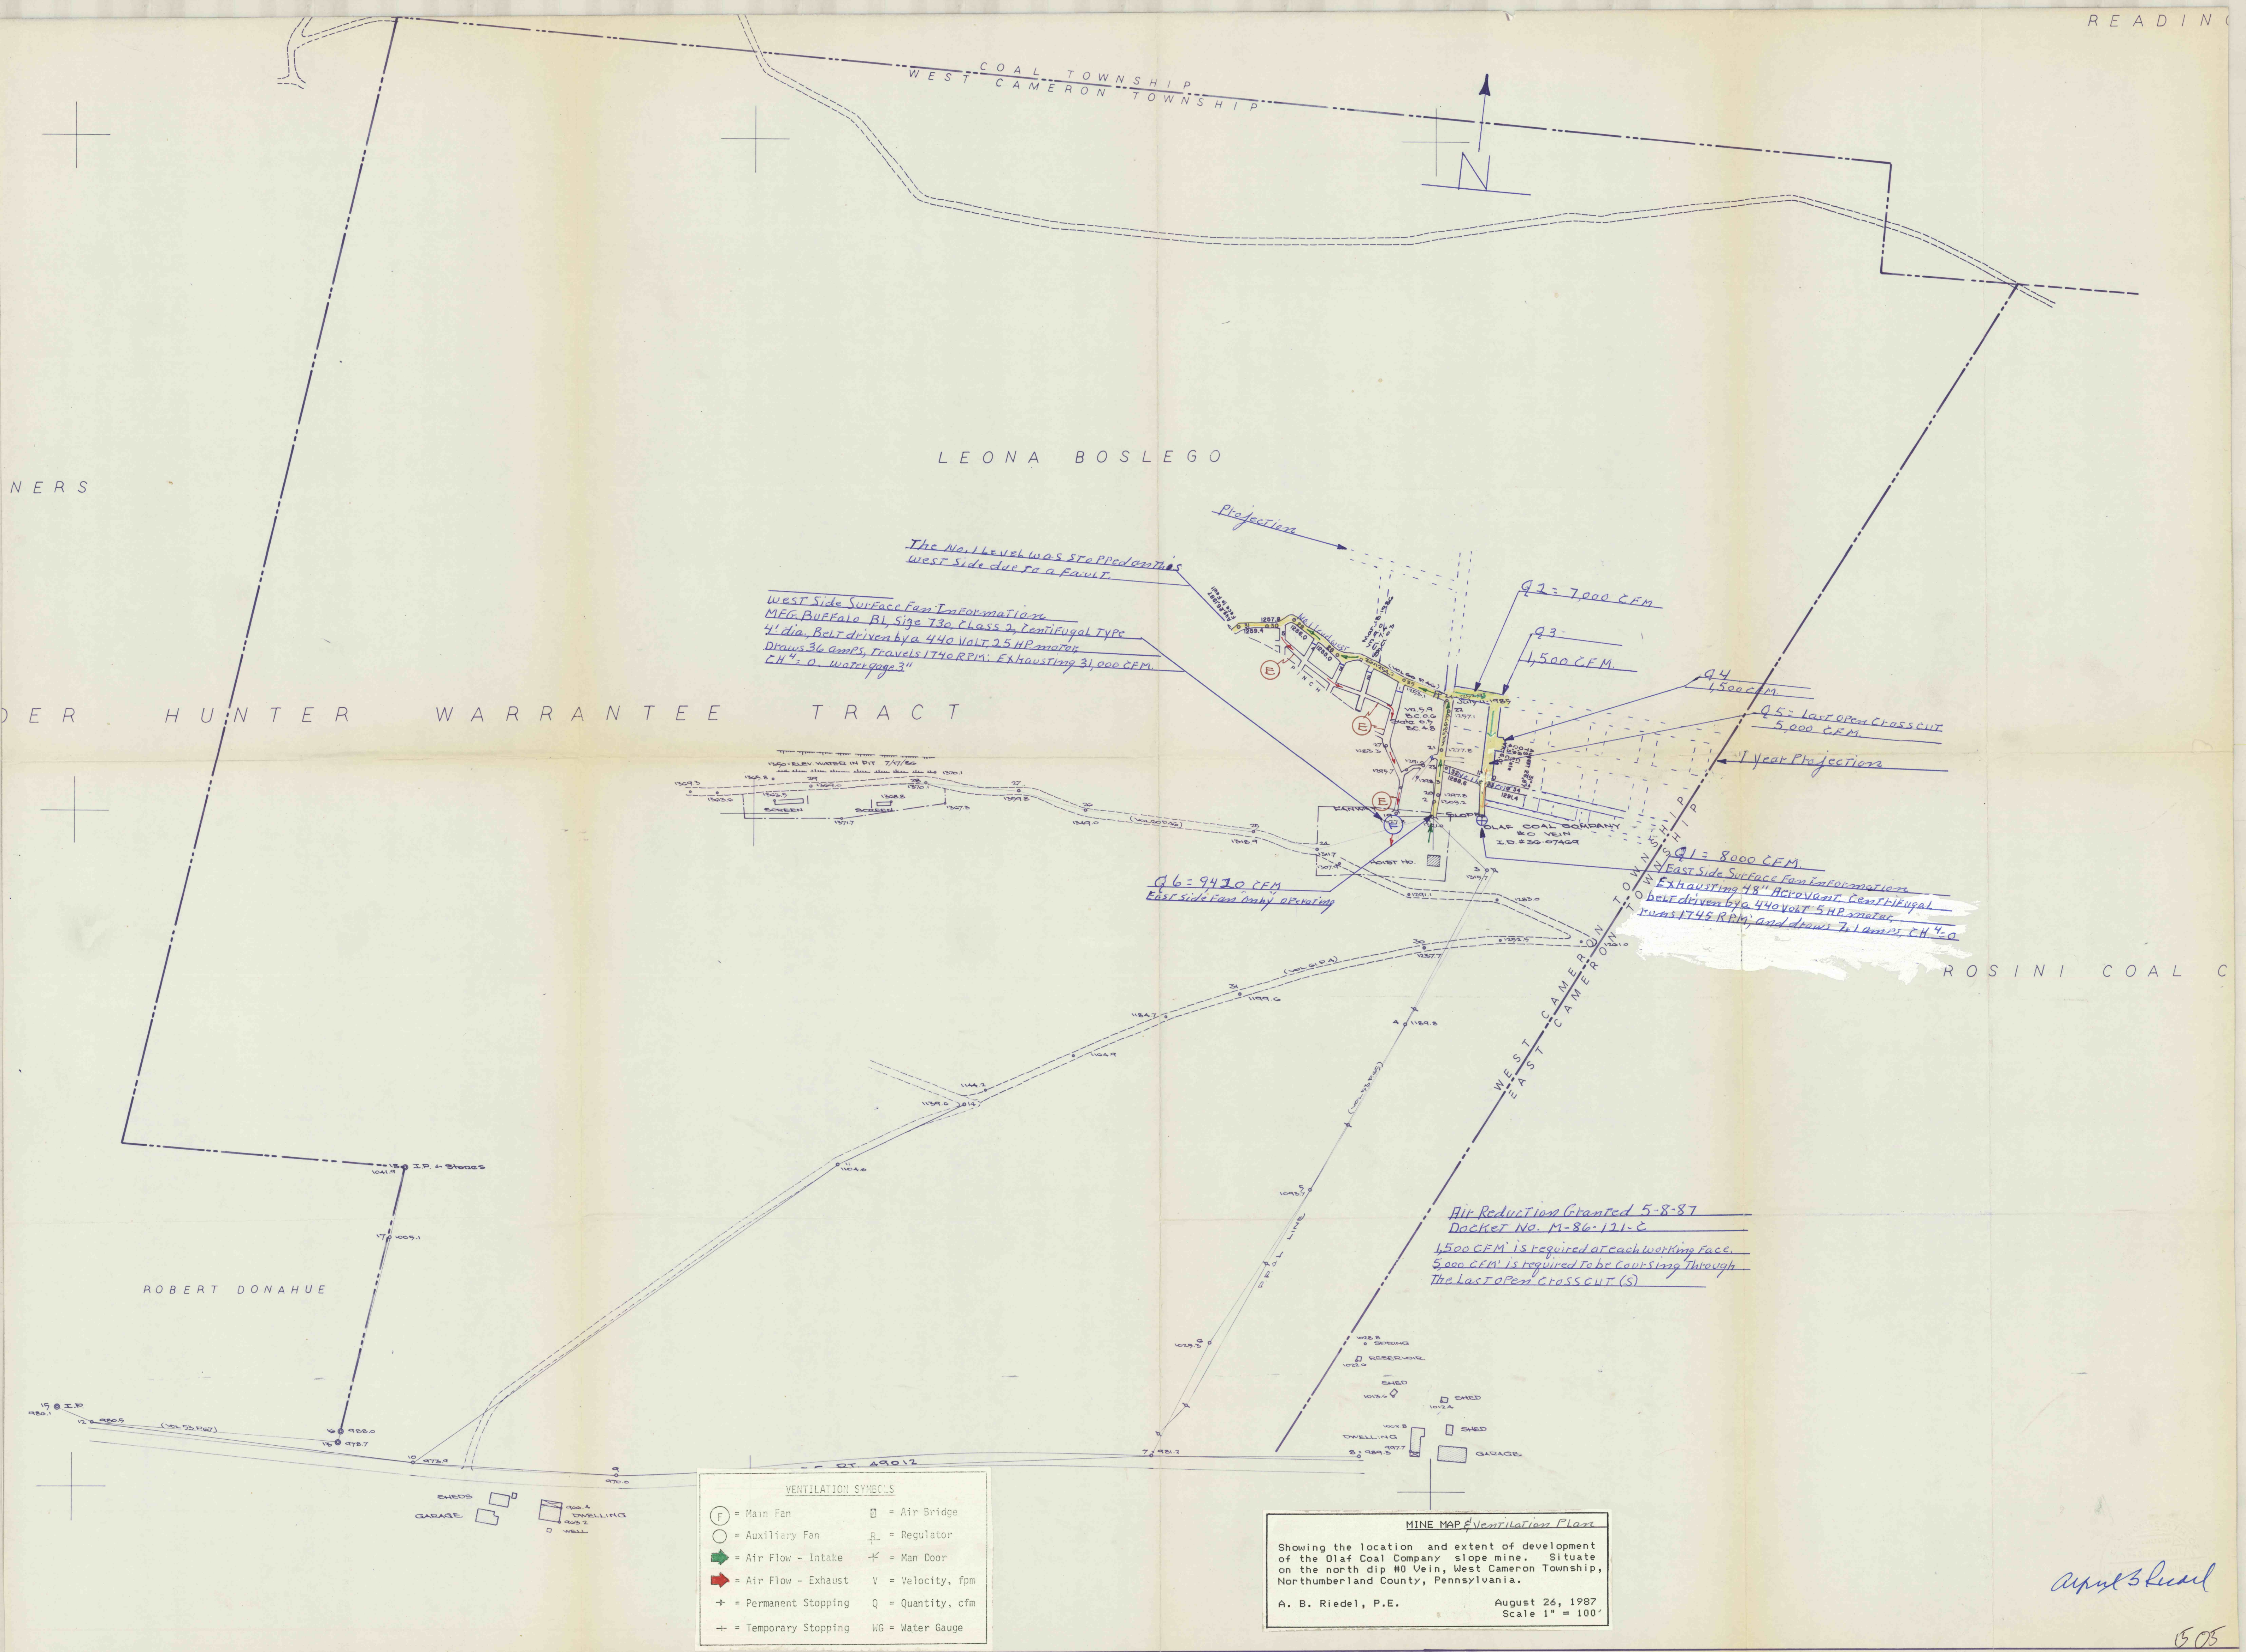

VENTILATION SYMBOLS

(F) = Main Fan	(AB) = Air Bridge
(A) = Auxiliary Fan	(R) = Regulator
(V) = Air Flow - Intake	(MD) = Man Door
(V) = Air Flow - Exhaust	(V) = Velocity, fpm
(+) = Permanent Stopping	(Q) = Quantity, cfm
(-) = Temporary Stopping	(WG) = Water Gauge

MINE MAP Ventilation Plan

Showing the location and extent of development of the Olaf Coal Company slope mine. Situate on the north dip #0 Vein, West Cameron Township, Northumberland County, Pennsylvania.

A. B. Riedel, P.E. August 26, 1987
Scale 1" = 100'

April 3, 1988