


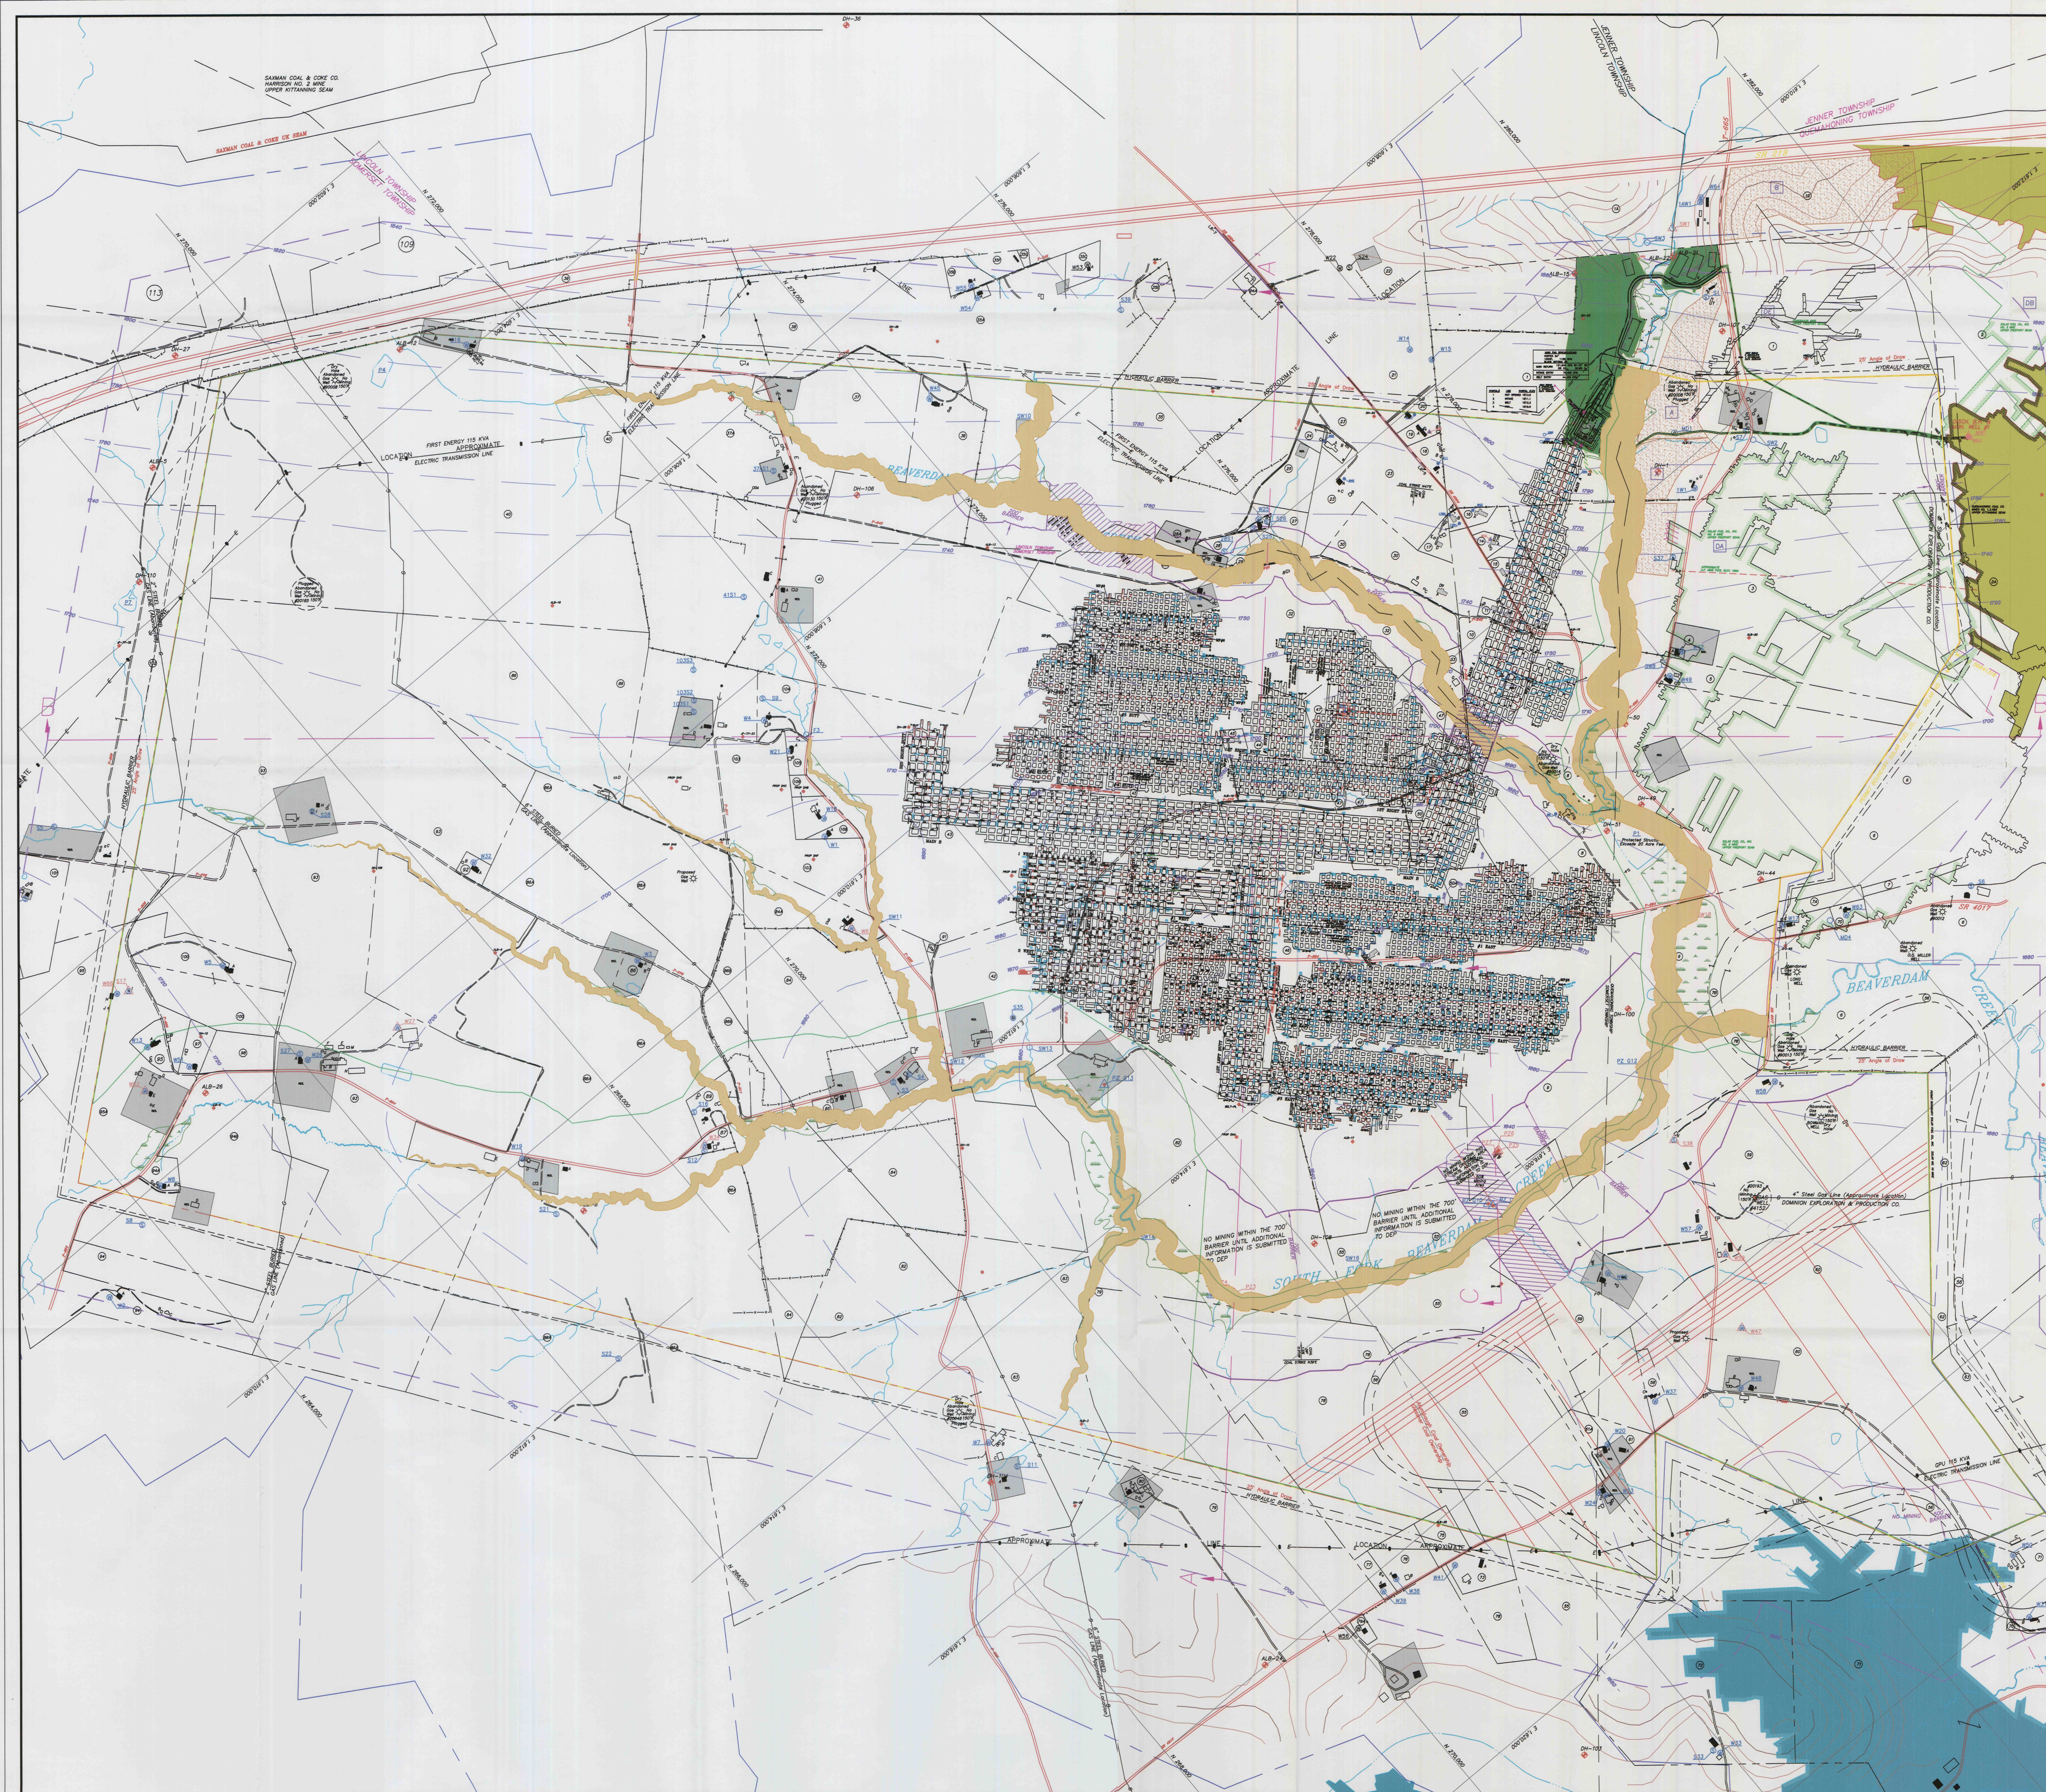

LEGEND

Parcel Boundary
Subsidence Control Plan Boundary
Property Lines
Roads
Streams
Fence
Upper Kibitzing Coal Seam Contour
DRI Hole
Reserve-to-Mining Area
Unit Lease is Obtained
No Mining Area
Unit Lease is Obtained
Mining System

VENTILATION LEGEND

INTAKE AIR
RETURN AIR
REDUCED RETURN AIR
REDUCED RETURN AIR
PRIMARY ESCAPEWAY
STOPPING WITH DOOR
STOPPING WITH HOLE
PERMANENT STOPPING
EQUIPMENT DOORS
PROPOSED STOPPING
CANVAS CHECK
OVERCAST
GASHEAL

AIR MONITORING STATION
TRACK
BELT HAULAGE
NOT SURVEYED
AIR LOCK
PROPOSED SEALS
CAVED AREA
CO MONITOR
INTAKE EVALUATION POINT
BLEEDER EVALUATION POINT
AREAS NOT POSTED DO TO WATER OR BAD ROOF

NOTES:
HORIZONTAL SURVEY ACCURACY PRIOR TO 2-21-04 EXCEEDS 1 IN 5,000
SURVEY ACCURACY AFTER 2-21-04 EXCEEDS 1 IN 10,000
COORDINATE BASE FOR THIS MAP IS NAD 83, PENNSYLVANIA SOUTH
THIS MAP MEETS REQUIREMENTS FOR 75.1200 & 75.372
THIS MAP REPRESENTS A COMPLETE AND ACCURATE REPRESENTATION
OF ALL EXISTING AND IS THE "FINAL" MAP

NAME: COMPANY OR CORPORATE OFFICERS DATE: _____
NAME: MINE INSPECTOR DATE: _____

I HEREBY CERTIFY THAT THE MINE WORKINGS MAPPED
BY APPLICABLE SERVICES FROM OCTOBER 11, 2004
FORWARD TO BE ACCURATE. SURFACE MAPPING AND
PRIOR MINE WORKINGS WAS PROVIDED BY MUSSEY
ENGINEERING, INC.

GENESIS, INC. d.b.a.
P.O. BOX 552, SOMERSET, PA 15501-0552
Meadow Run Genesis, Inc.
GENESIS NO. 17 MINE
FINAL MINE MAP
CMAA # 56001301
MSHA ID #36-08980
UPPER KITTANNING SEAM
Lincoln, Quakertown, & Somerset Townships, Somerset County, PA
Scale: 1" = 500' Date: 10/07/06