




**ROOF PLAN**  
SCALE: 1/8" = 1'-0"

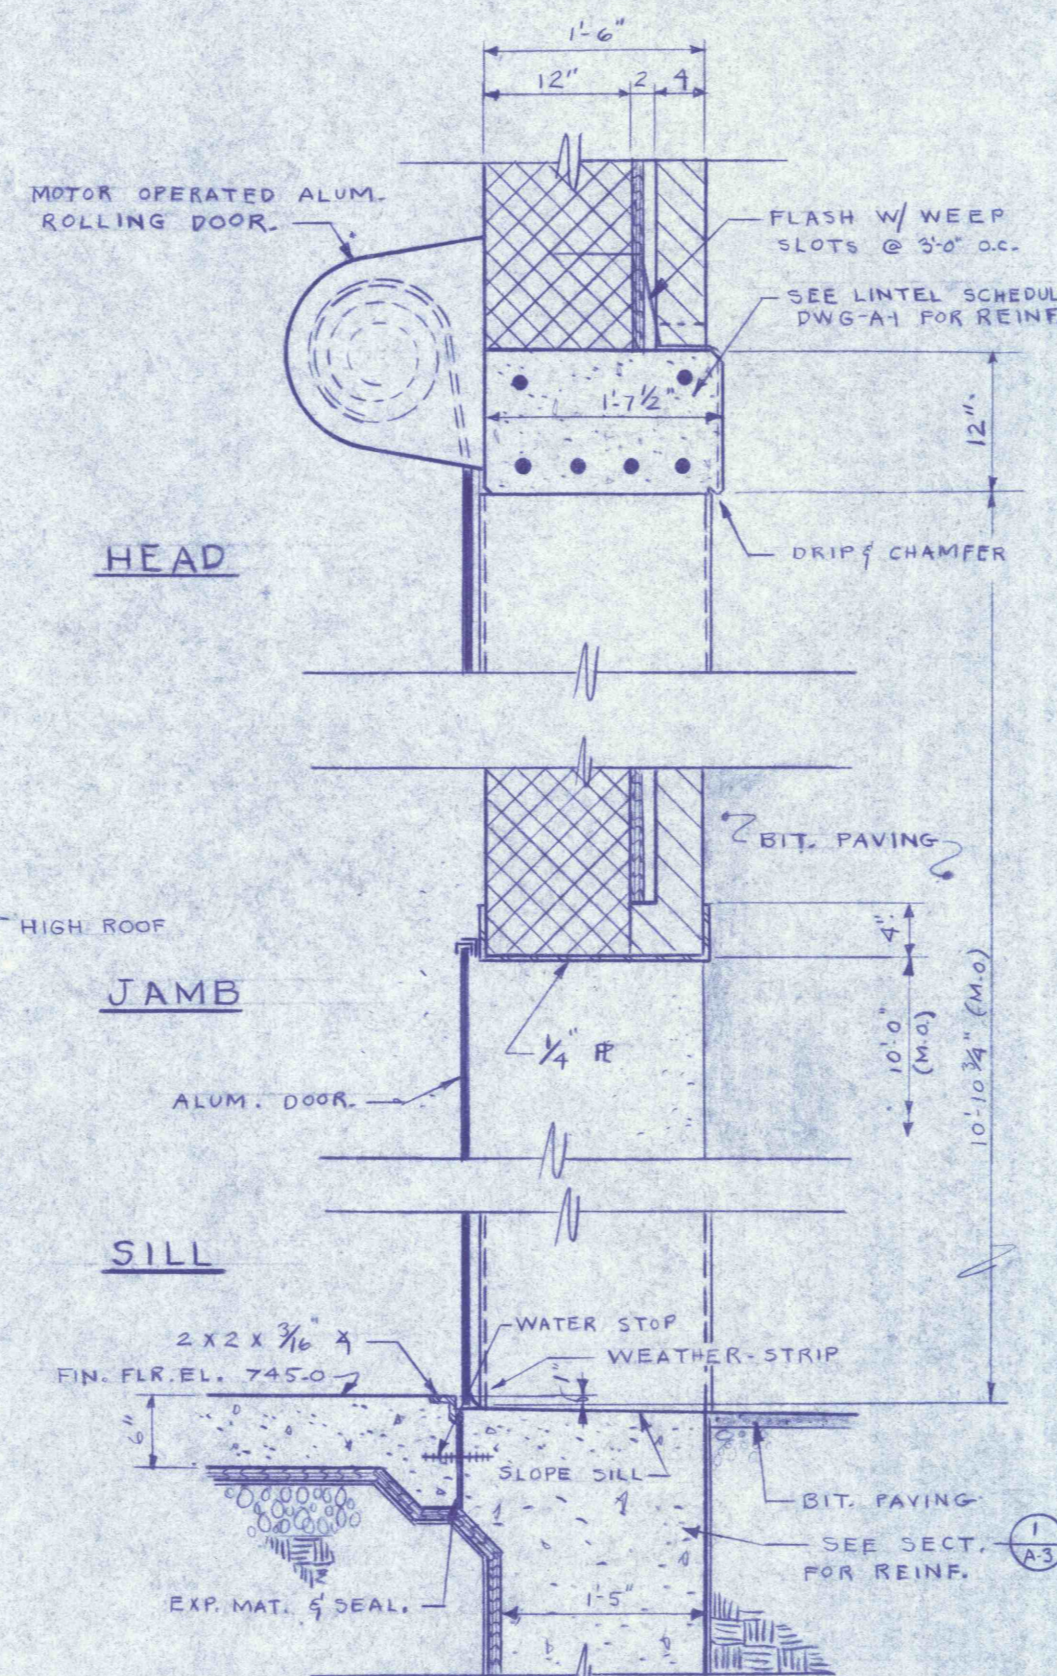



**SECTION**  
SCALE: 1/8" = 1'-0"

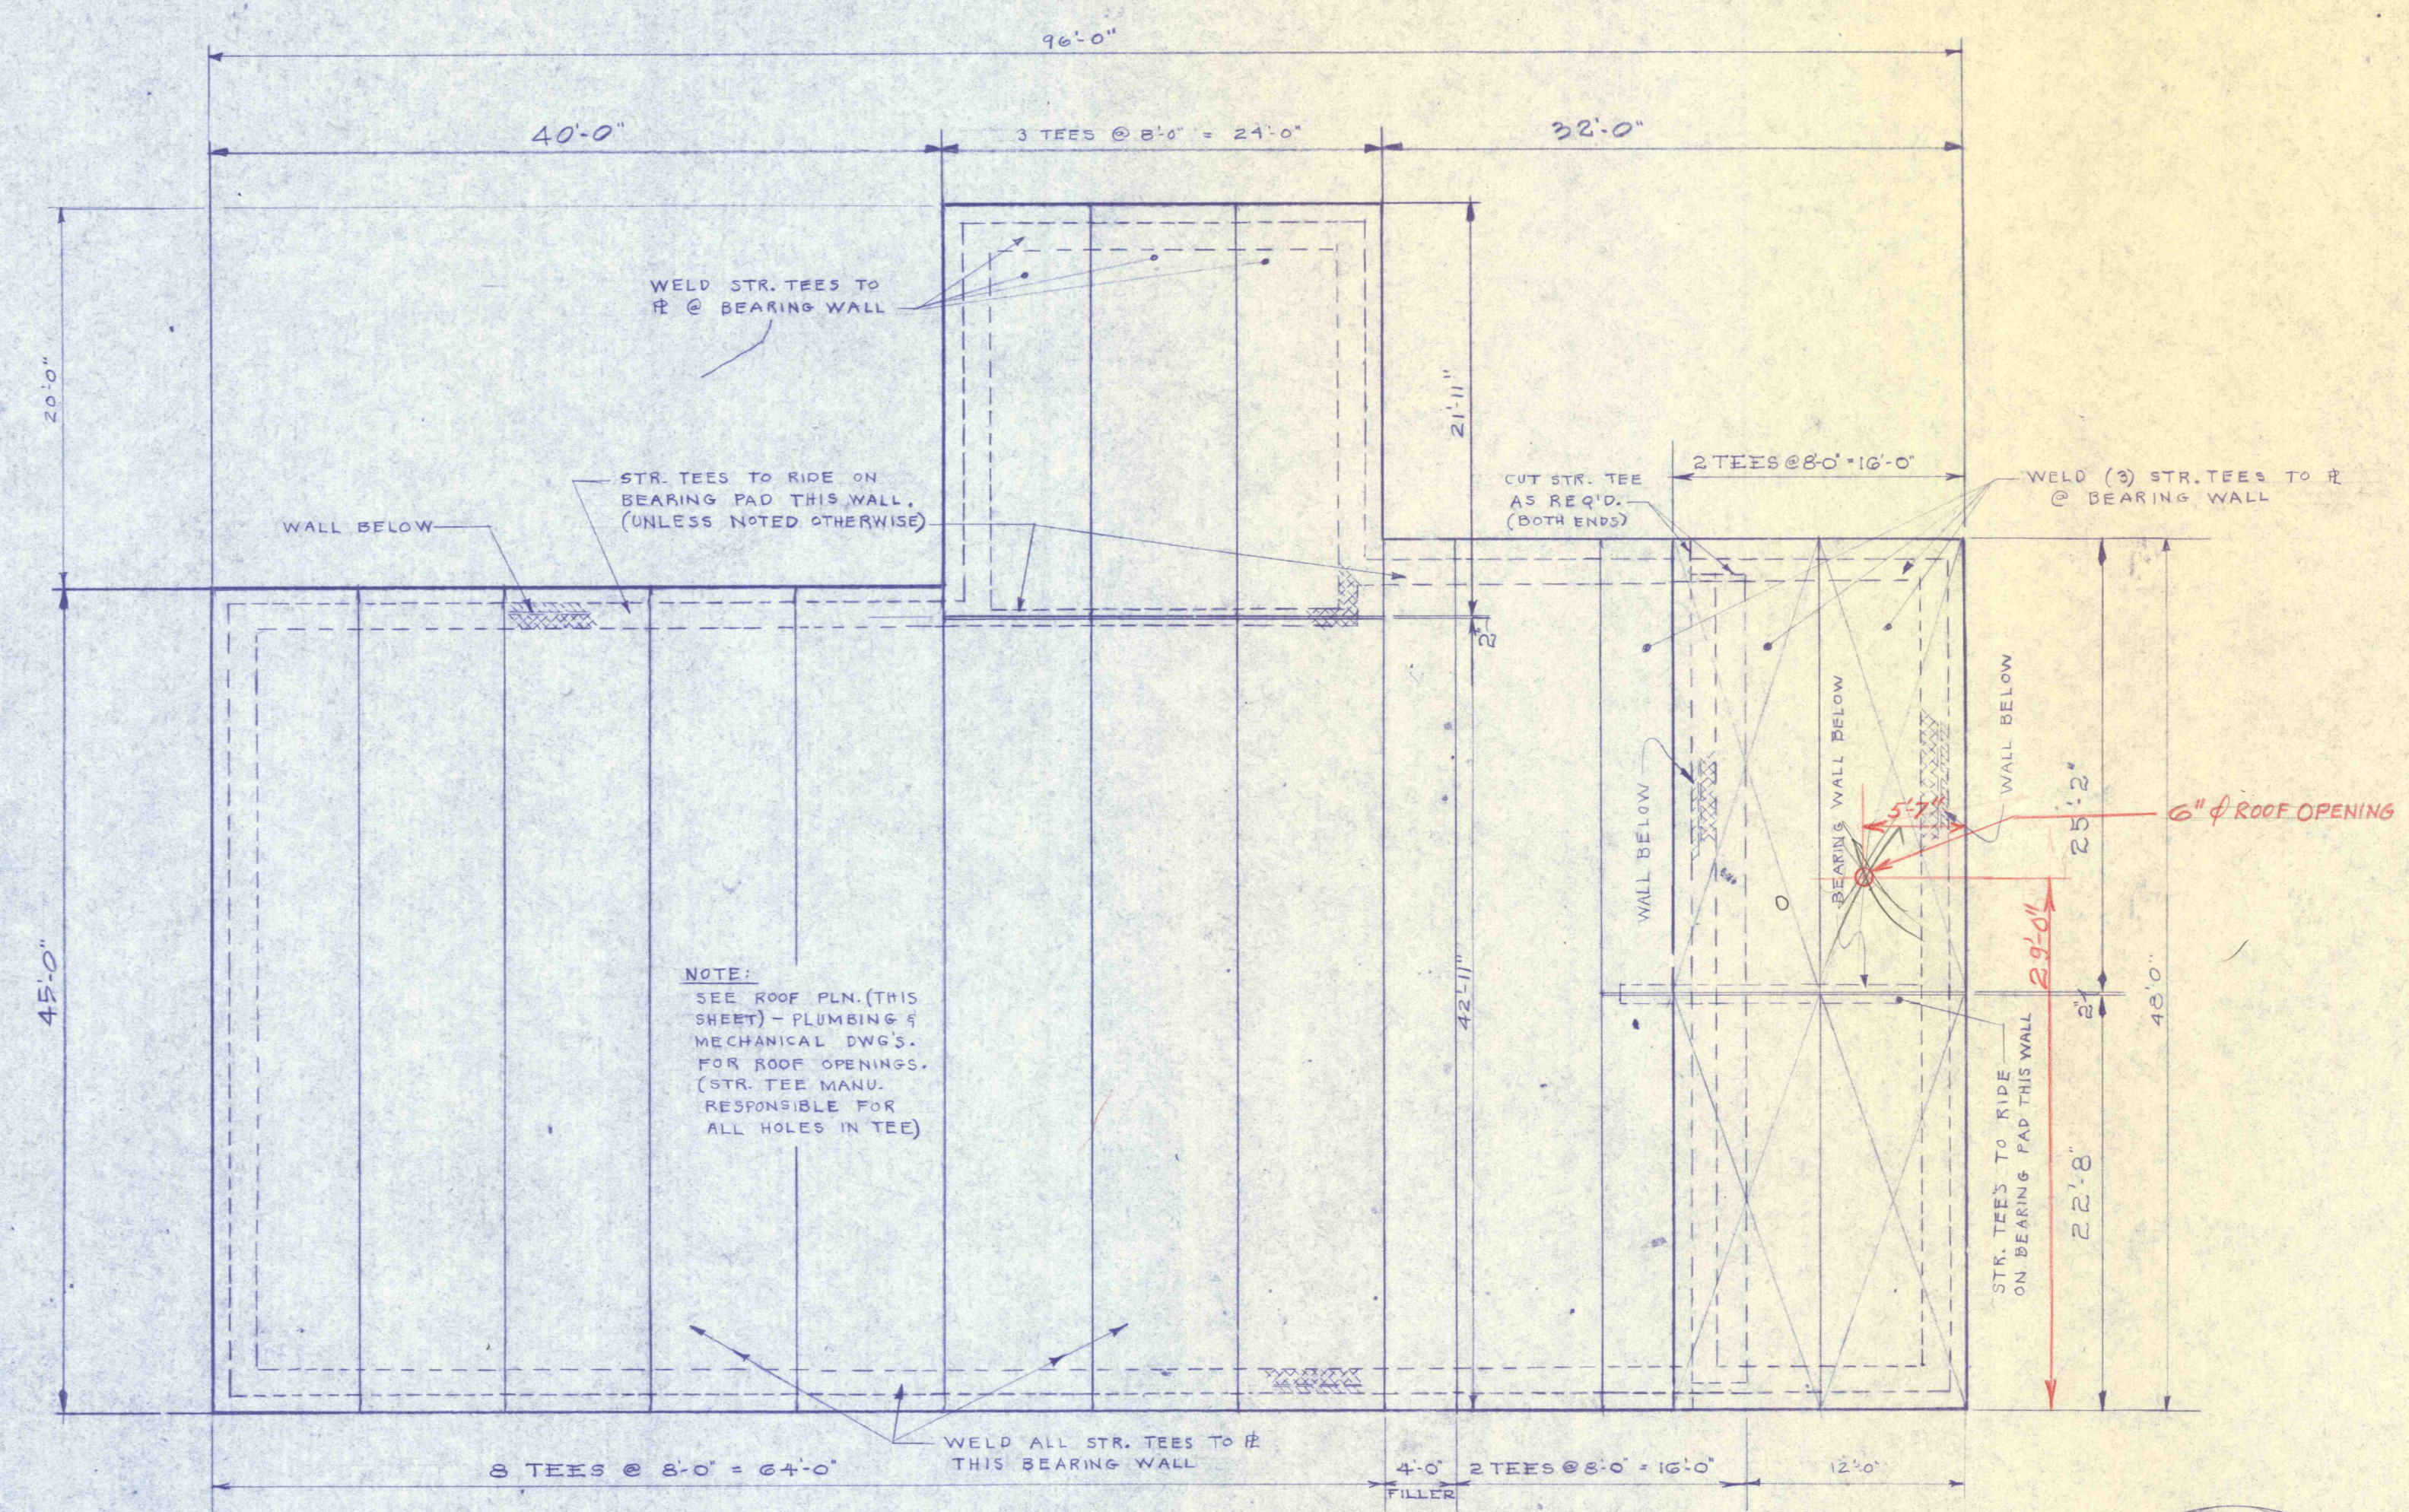

**ROOF FRAMING PLAN**  
SCALE: 1/8" = 1'-0"

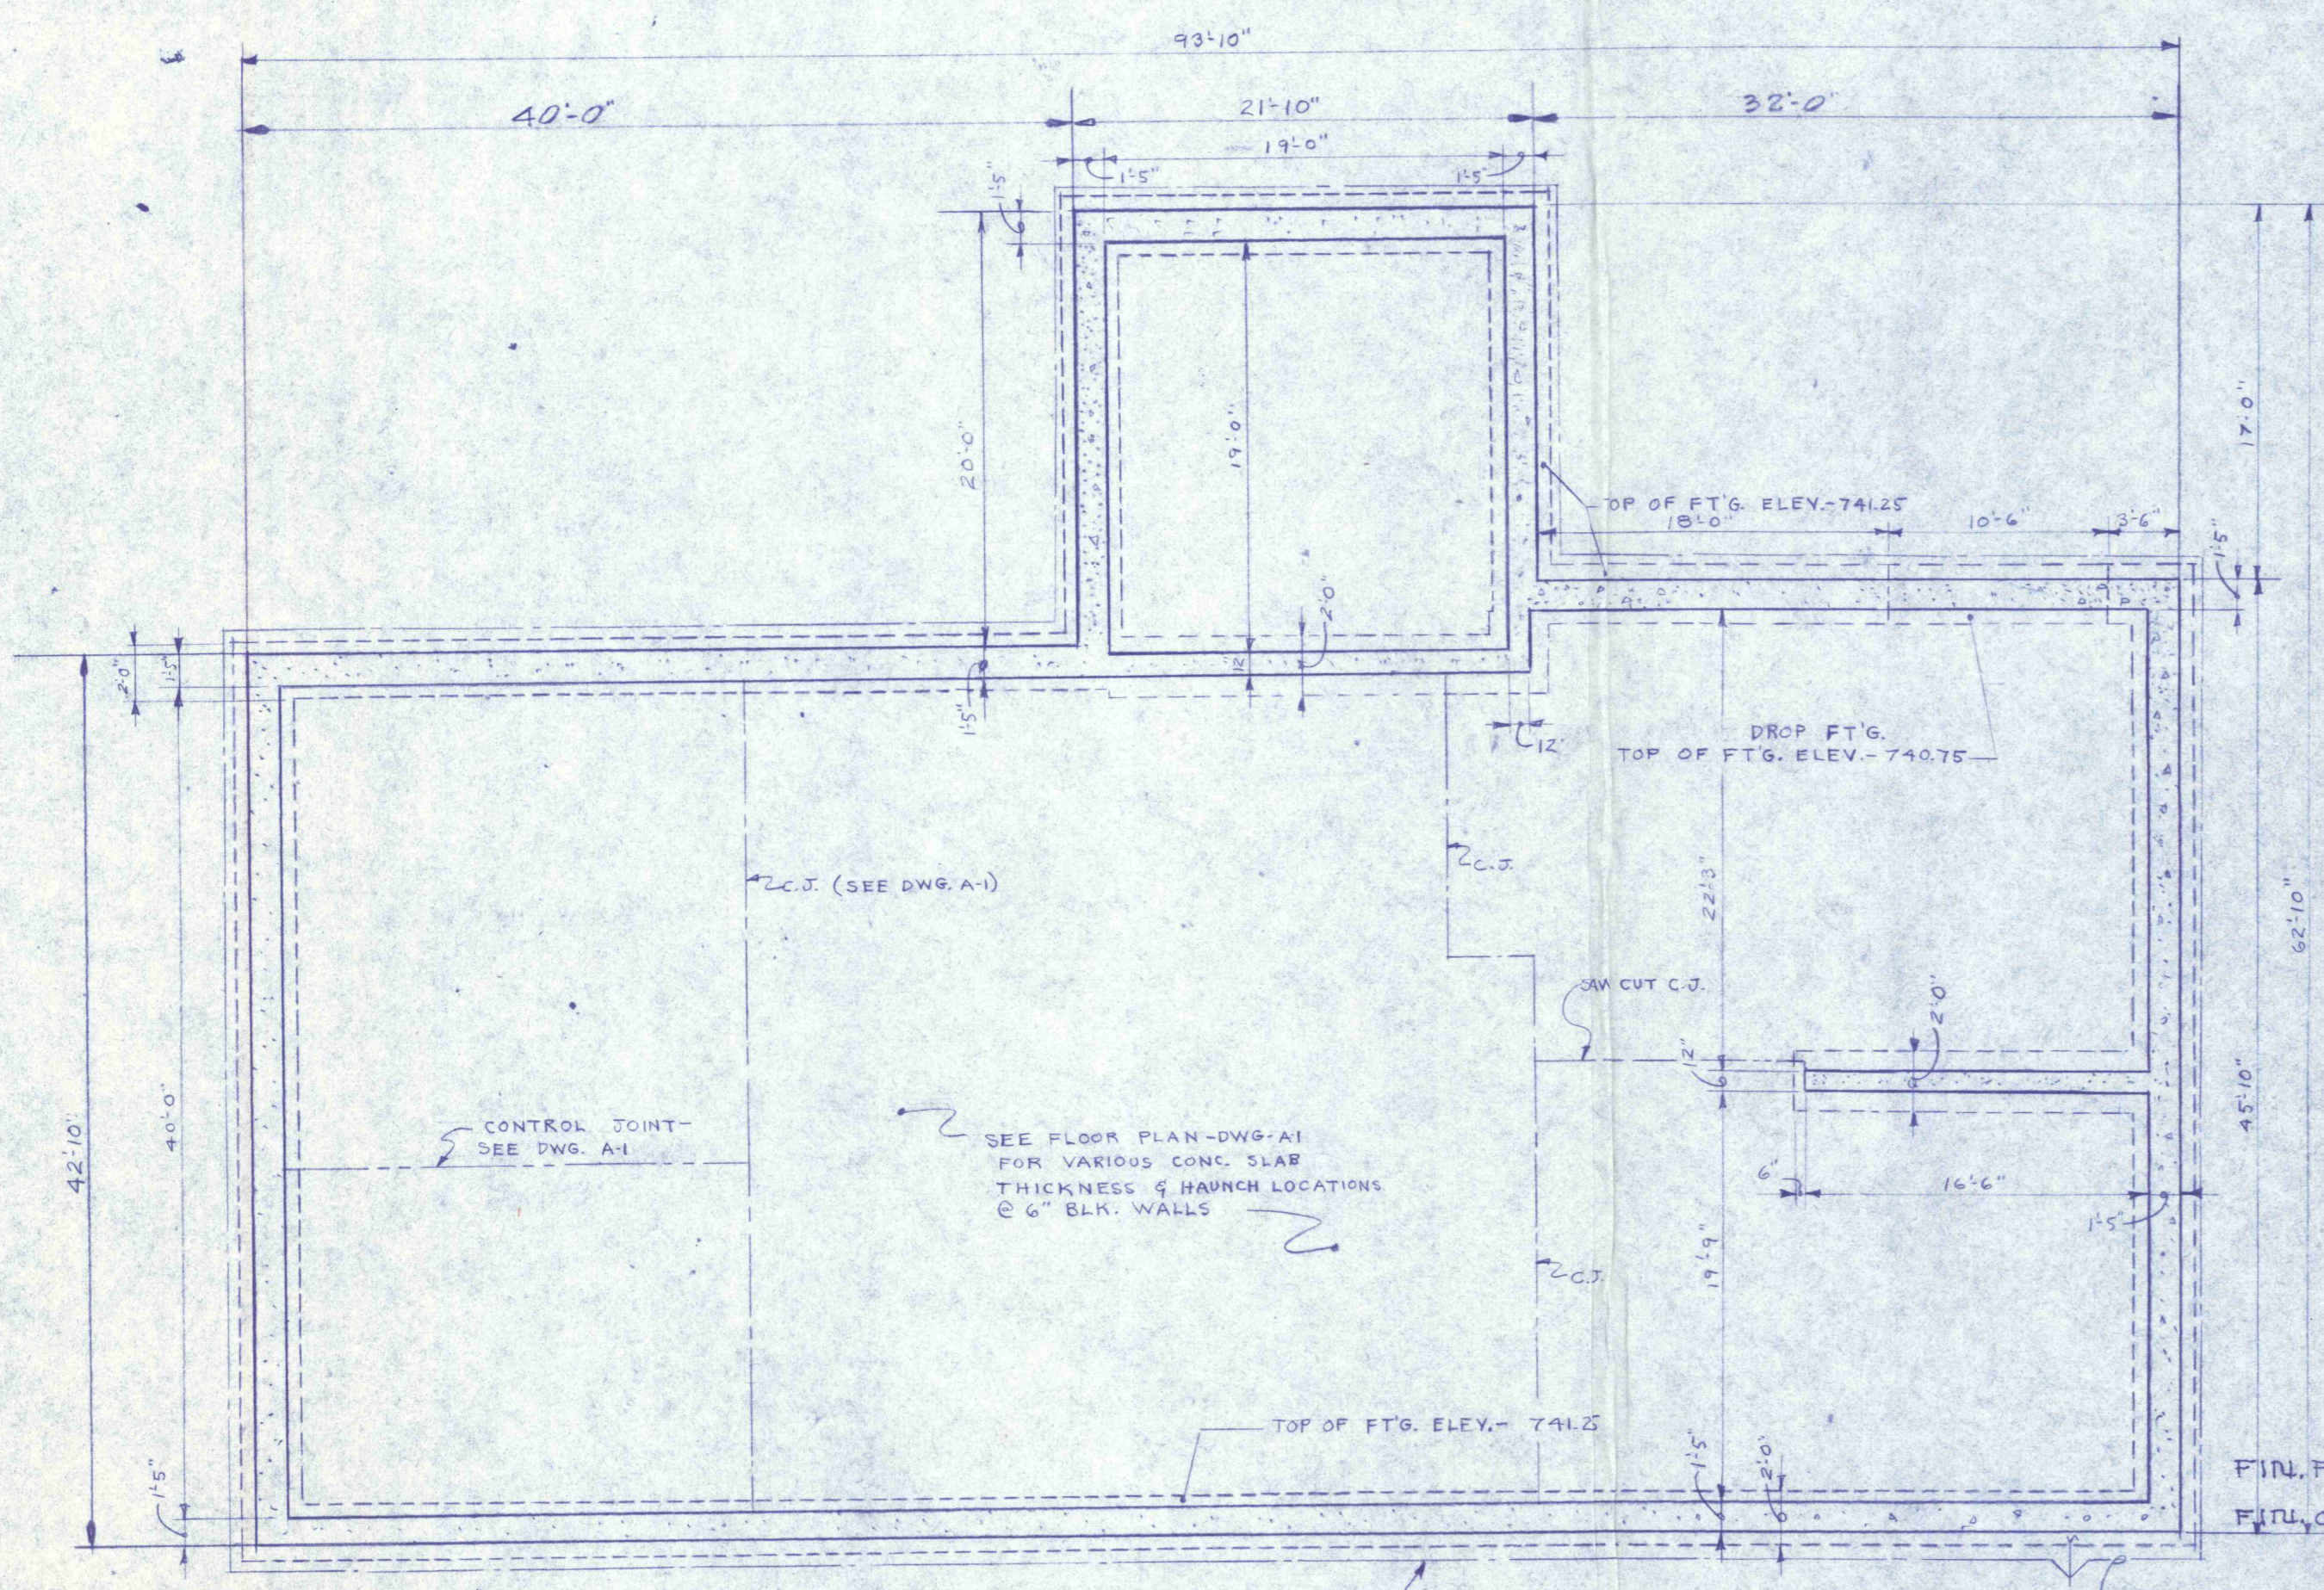

**FOUNDATION PLAN**  
SCALE: 1/8" = 1'-0"

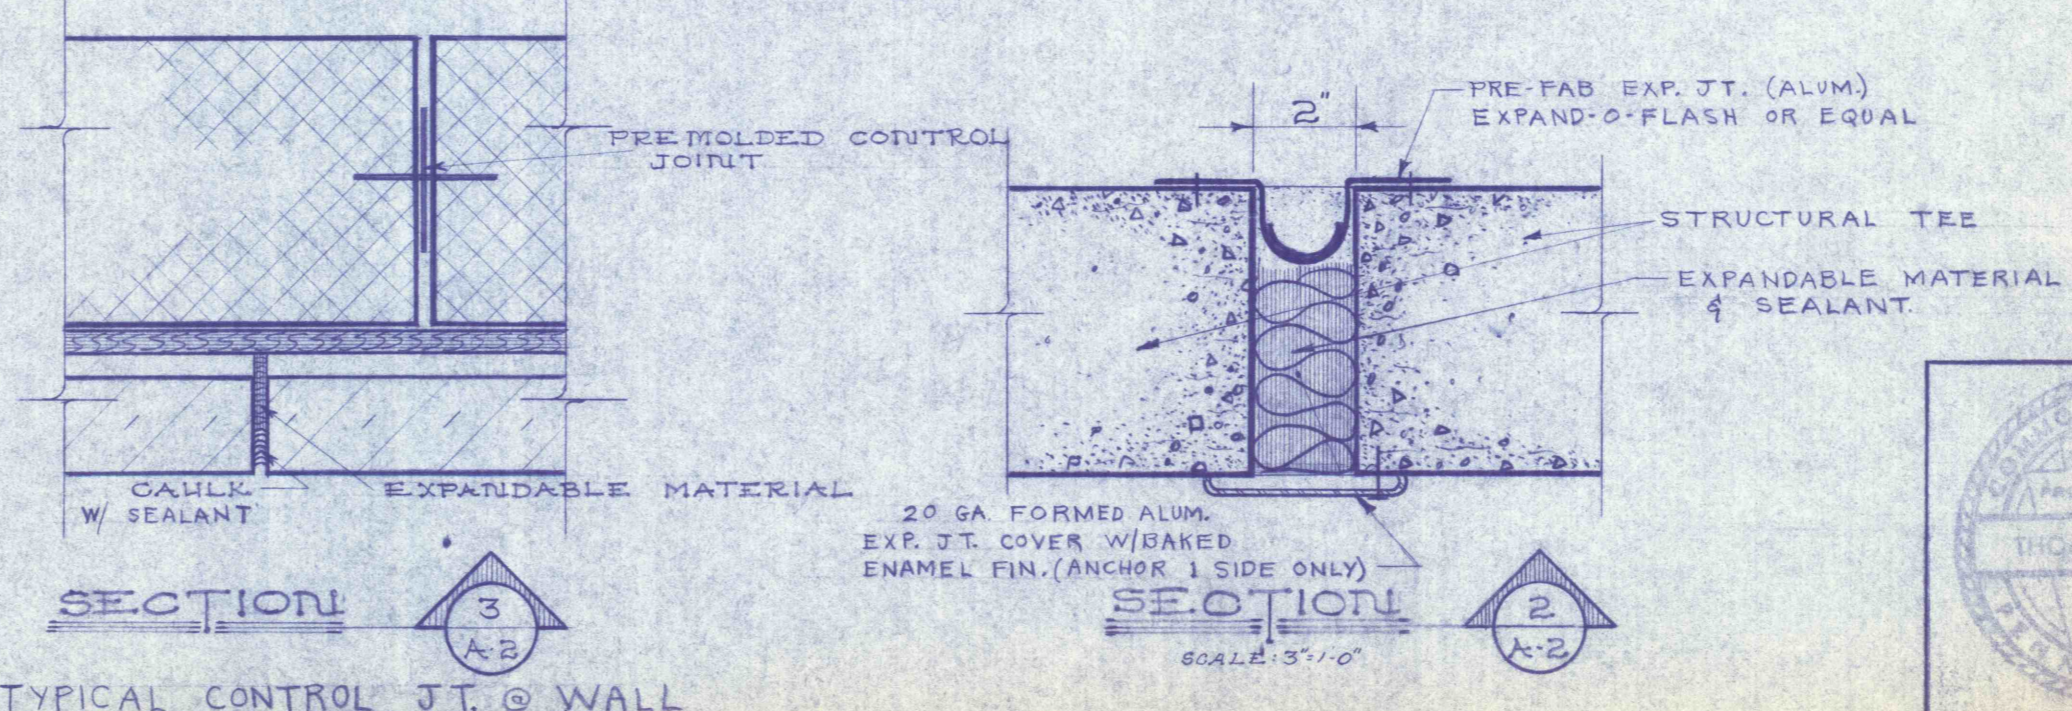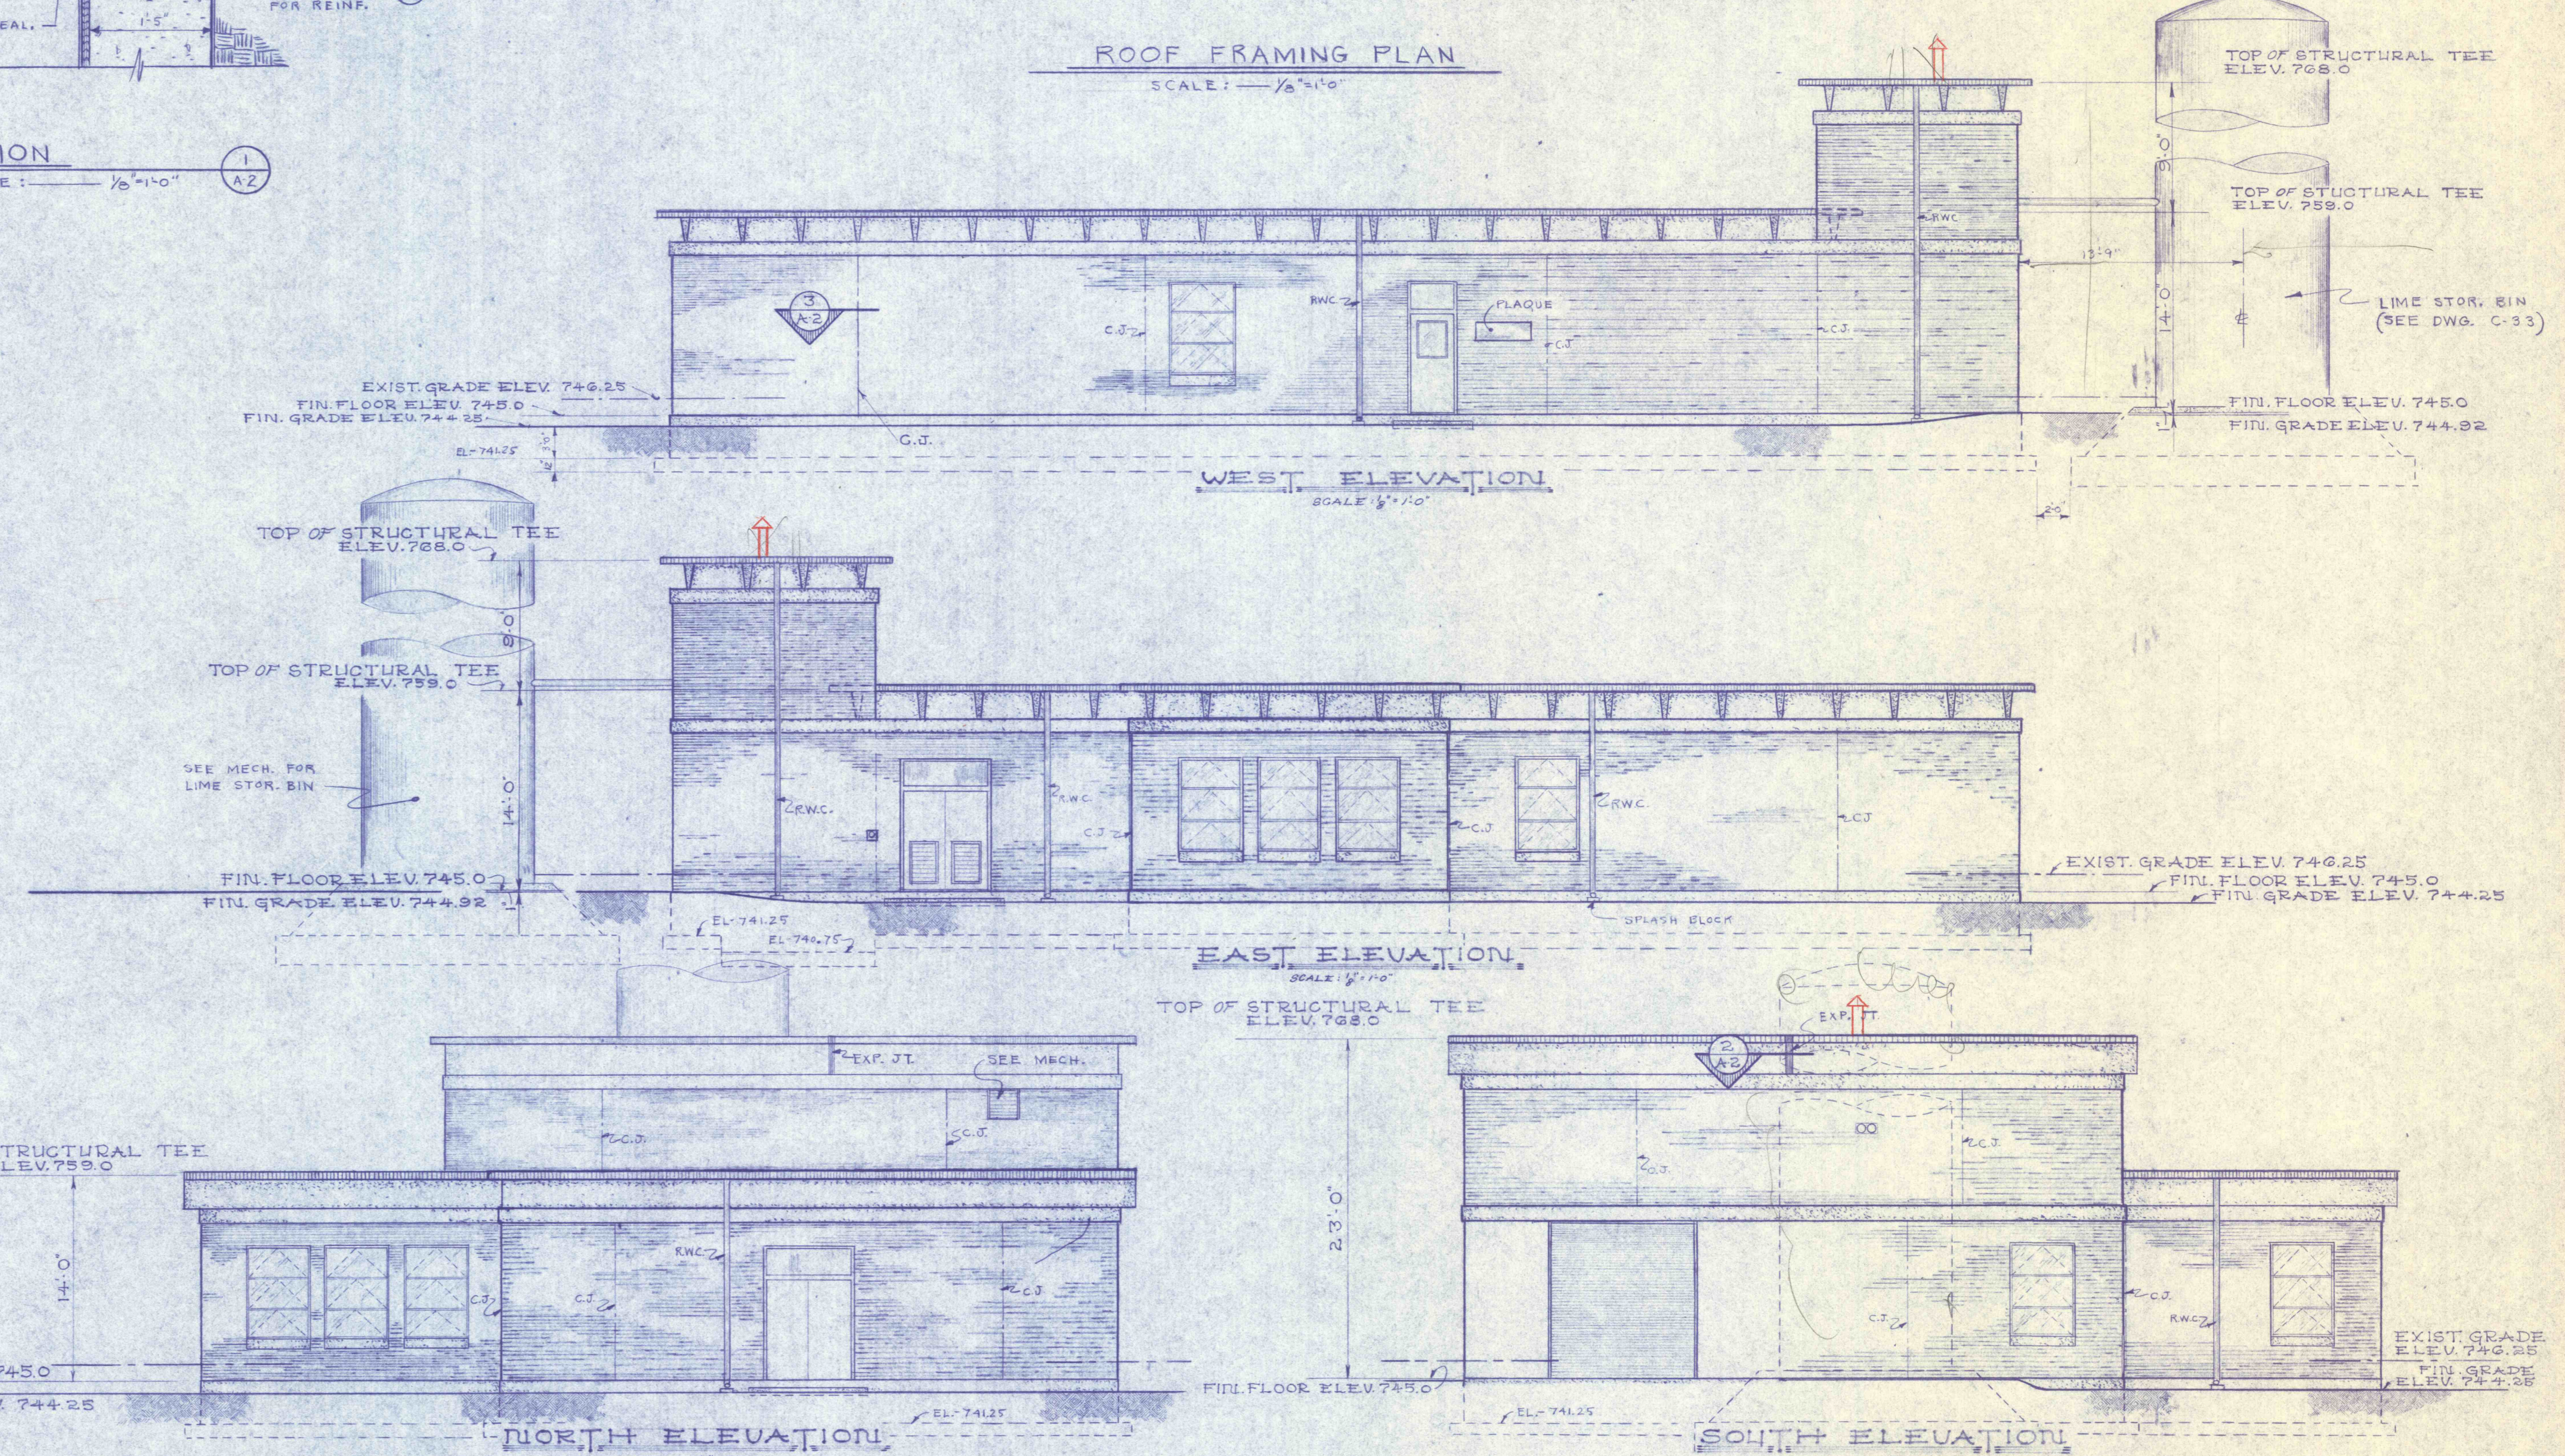

**SECTION**  
TYPICAL CONTROL JT. @ WALL

| REVISIONS |  |
|-----------|--|
|           |  |
|           |  |

| PLANS - ELEVATIONS & DETAILS  |                        |
|---|------------------------|
| CONSTRUCTION OF TREATMENT FACILITIES FOR ACID MINE DRAINAGE   |                        |
| RAUSCH CREEK WATERSHED  |                        |
| SCHUYLKILL COUNTY PENNSYLVANIA  |                        |
| ANTRACITE RESEARCH & DEVELOPMENT CO. INC. consulting engineers POTTSVILLE PENNSYLVANIA                        | TAMAQUA                |
| JOB NO: 6805<br>DATE: JANU 11, 1970<br>SCALE: 1/8" = 1'-0"<br>DRAWN: T.H.F. W.J.R.<br>APPROVED: T.H.R. J.L.L. | DRAWING NO: <b>A-2</b> |