



SECTION A

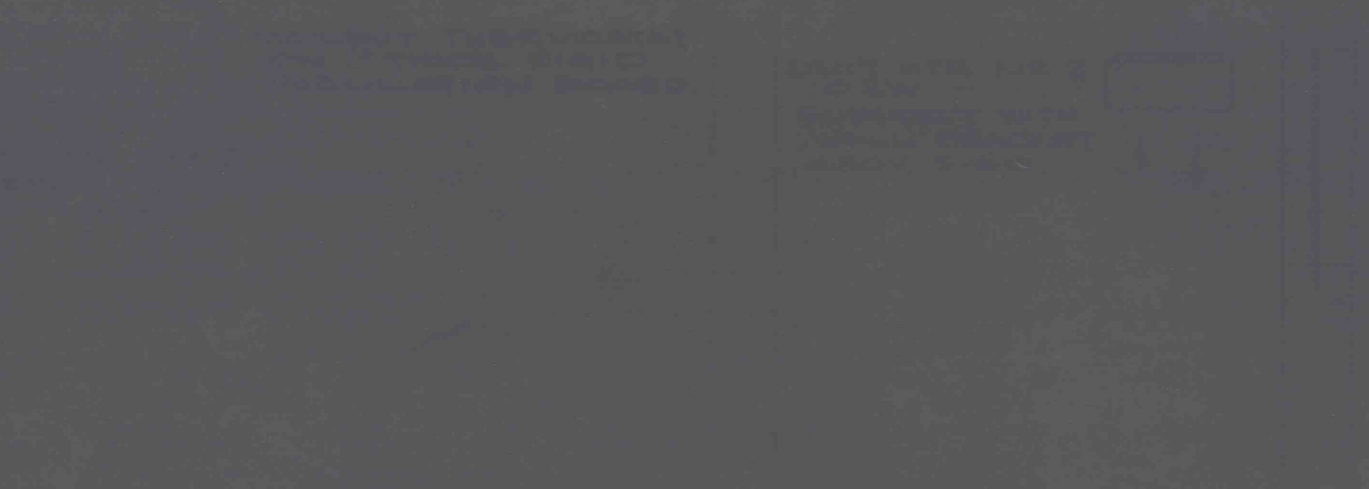

DETAIL G - EXHAUST PAN

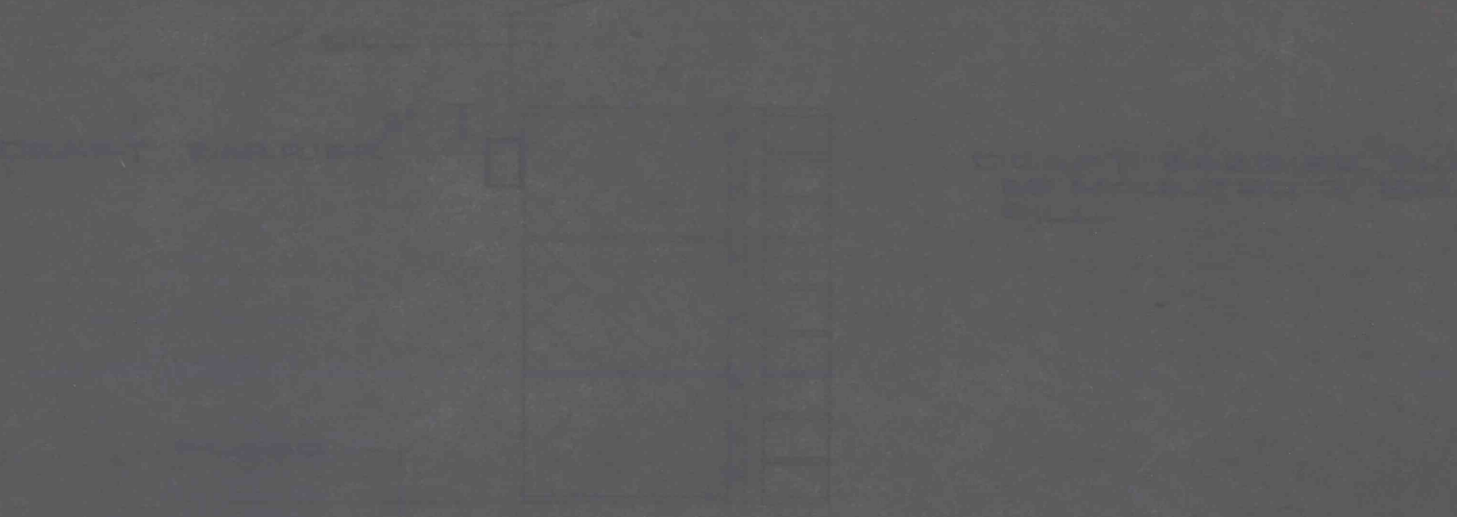

DETAIL C - DRAFT BARRIER



HTR N 3



DETAIL F - WALL

|                            |                 |
|----------------------------|-----------------|
| CONTROL BUILDING HVAC PLAN |                 |
| DATE: 11/15/2011           | SCALE: AS SHOWN |
| PROJECT: CONTROL BUILDING  | NO. 11          |