



ROOF PLAN

SCALE: 1/8" = 1'-0"

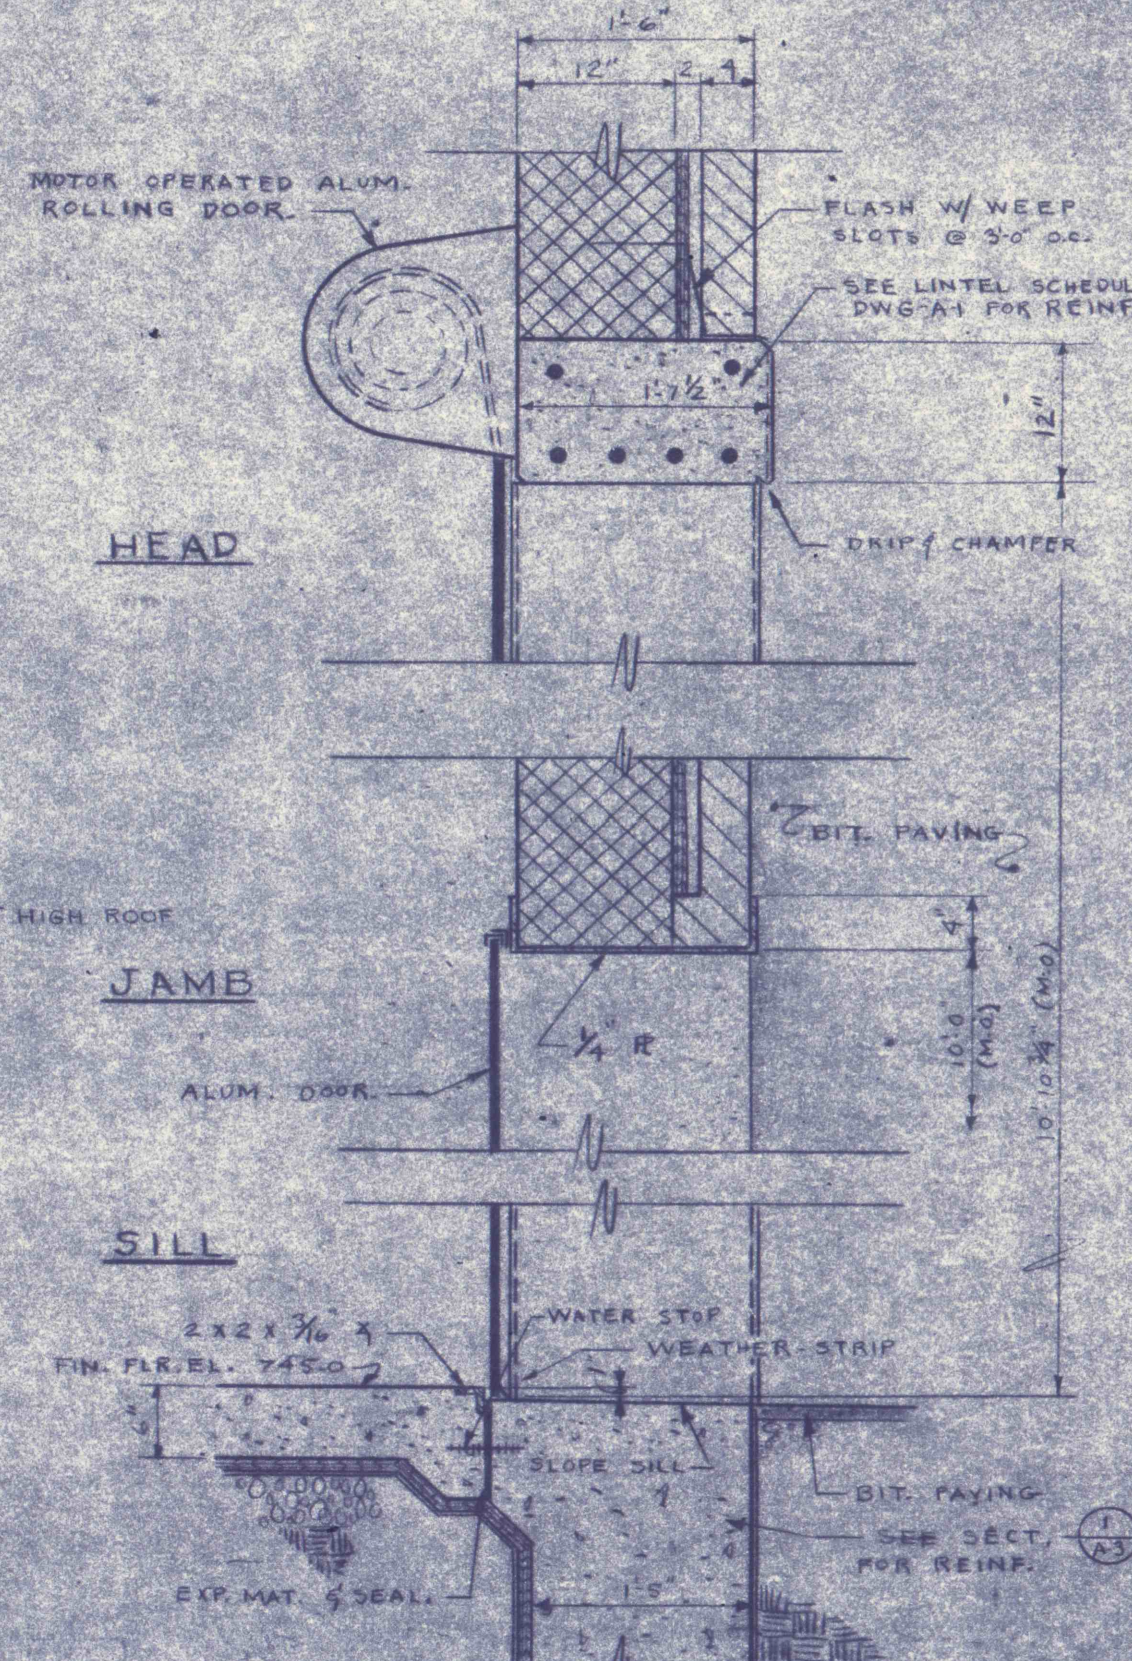


SECTION

SCALE: 1/8" = 1'-0"

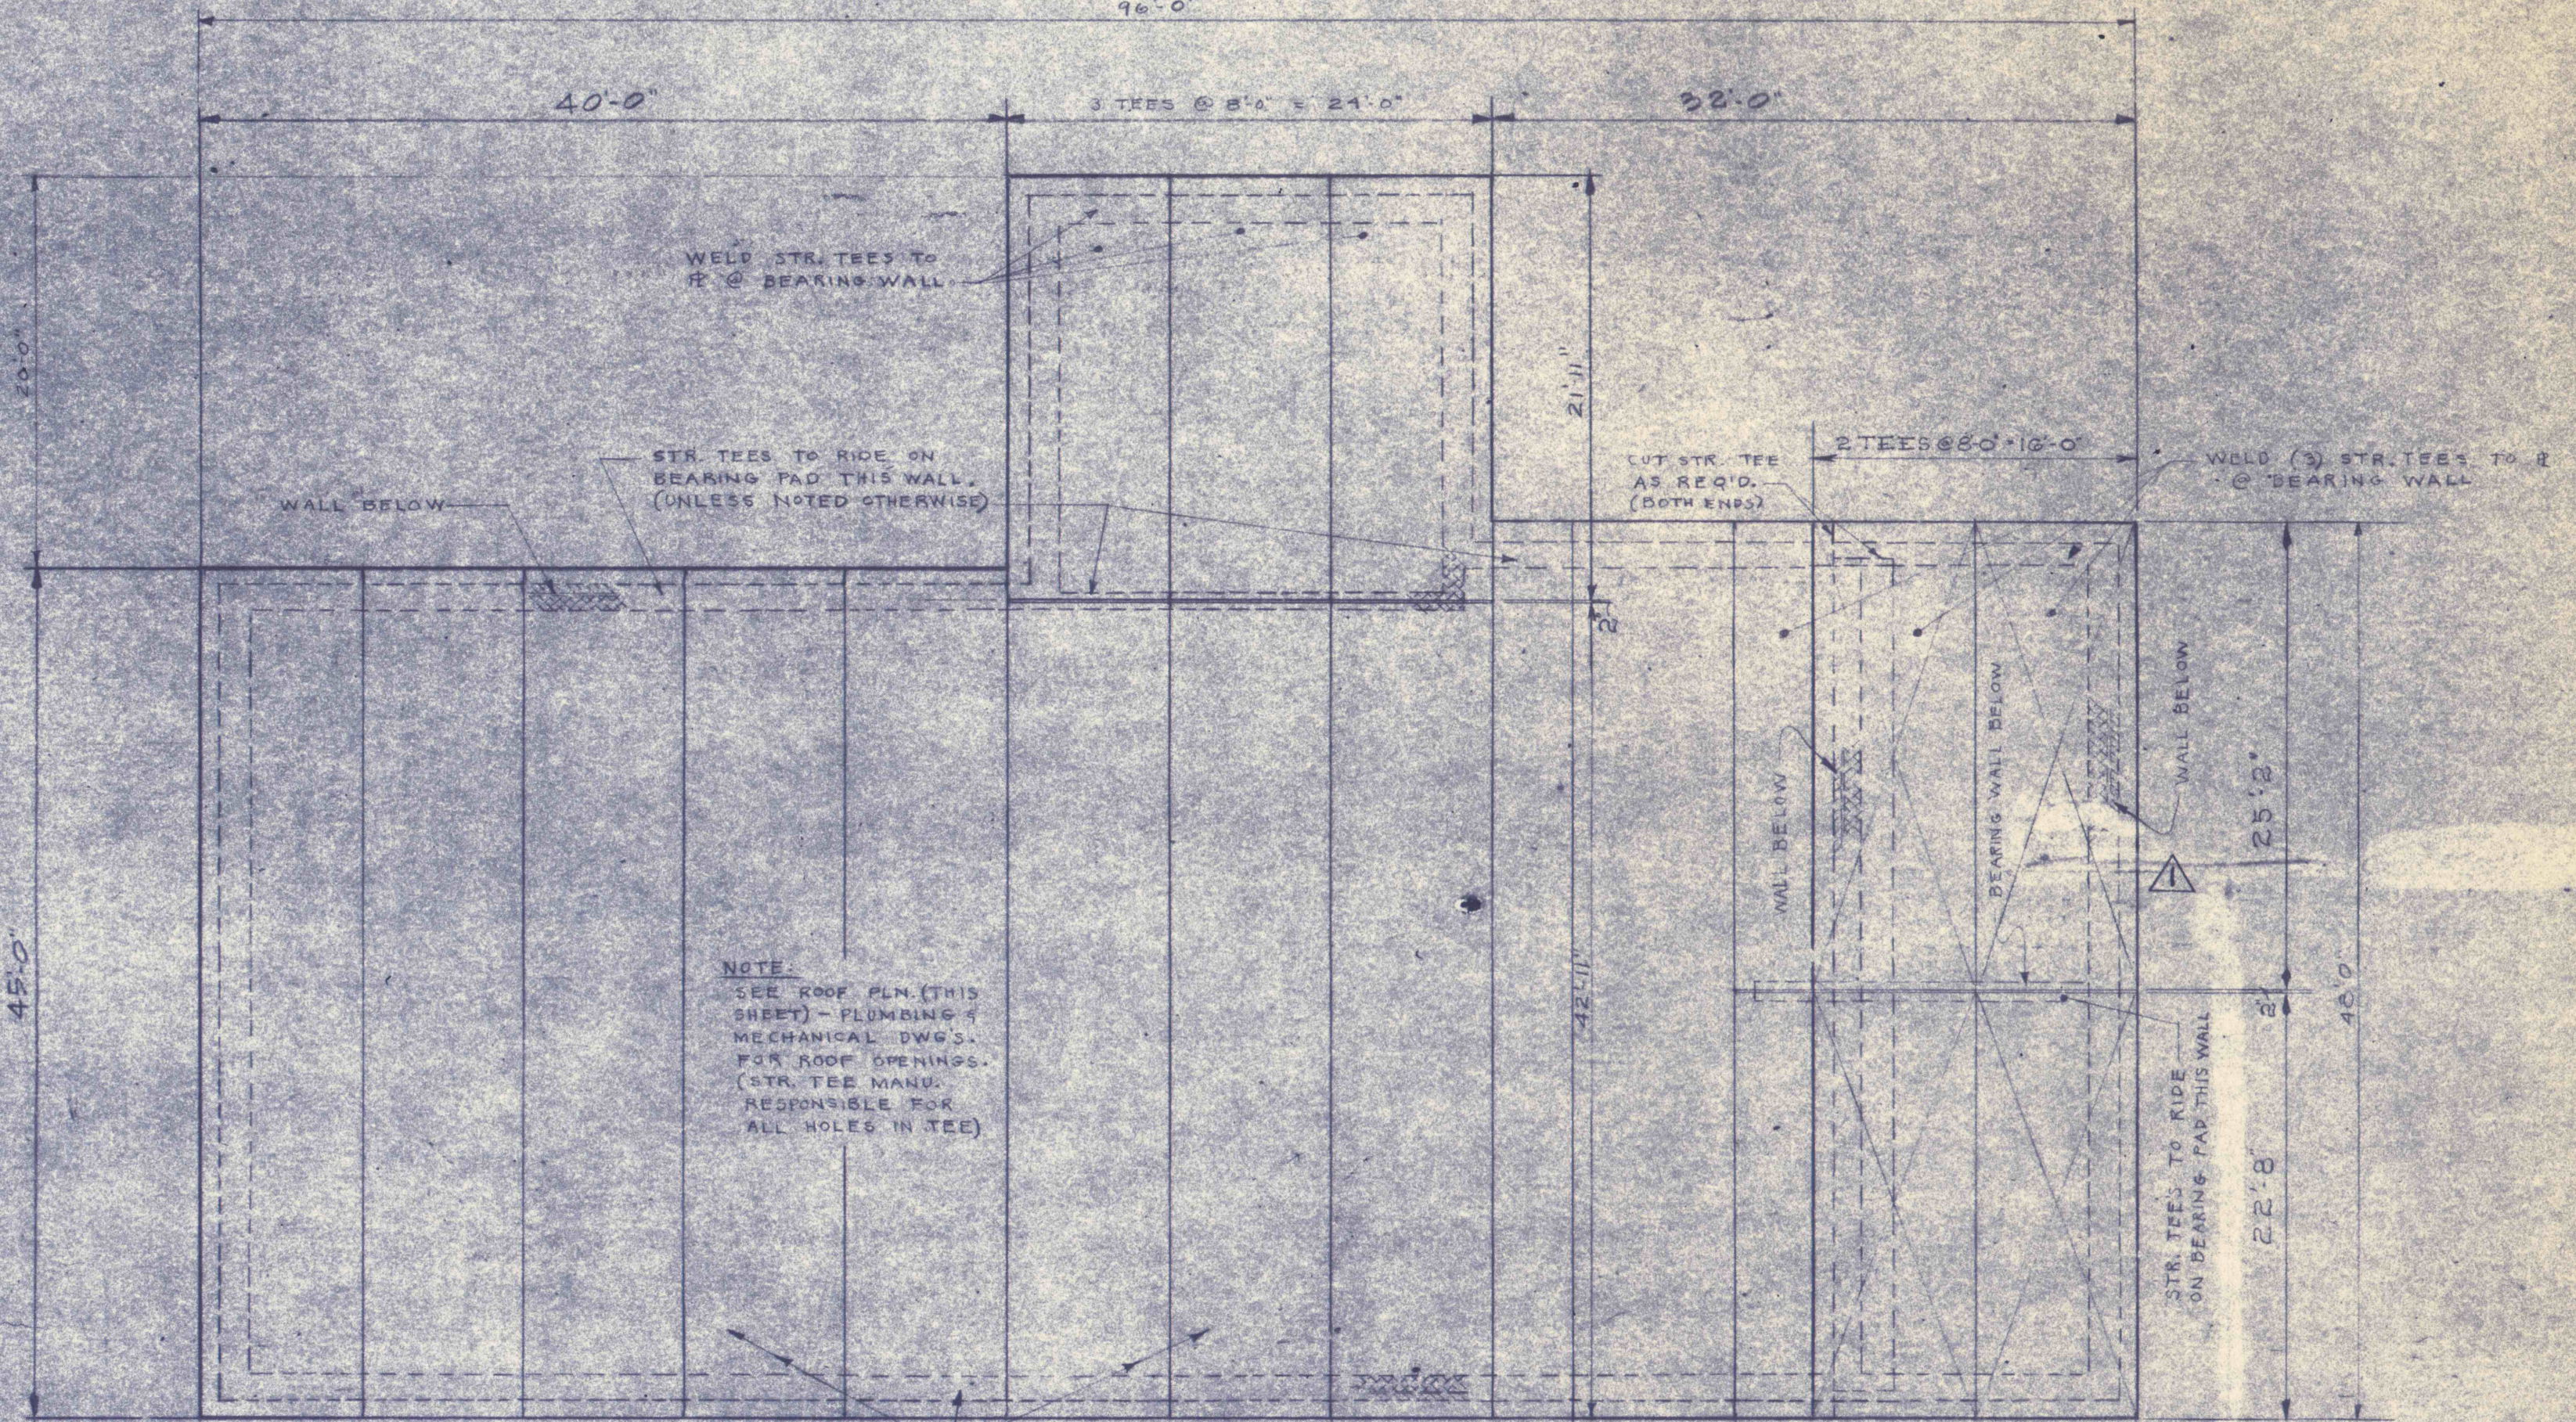

ROOF FRAMING PLAN



SCALE: 1/8" = 1'-0"

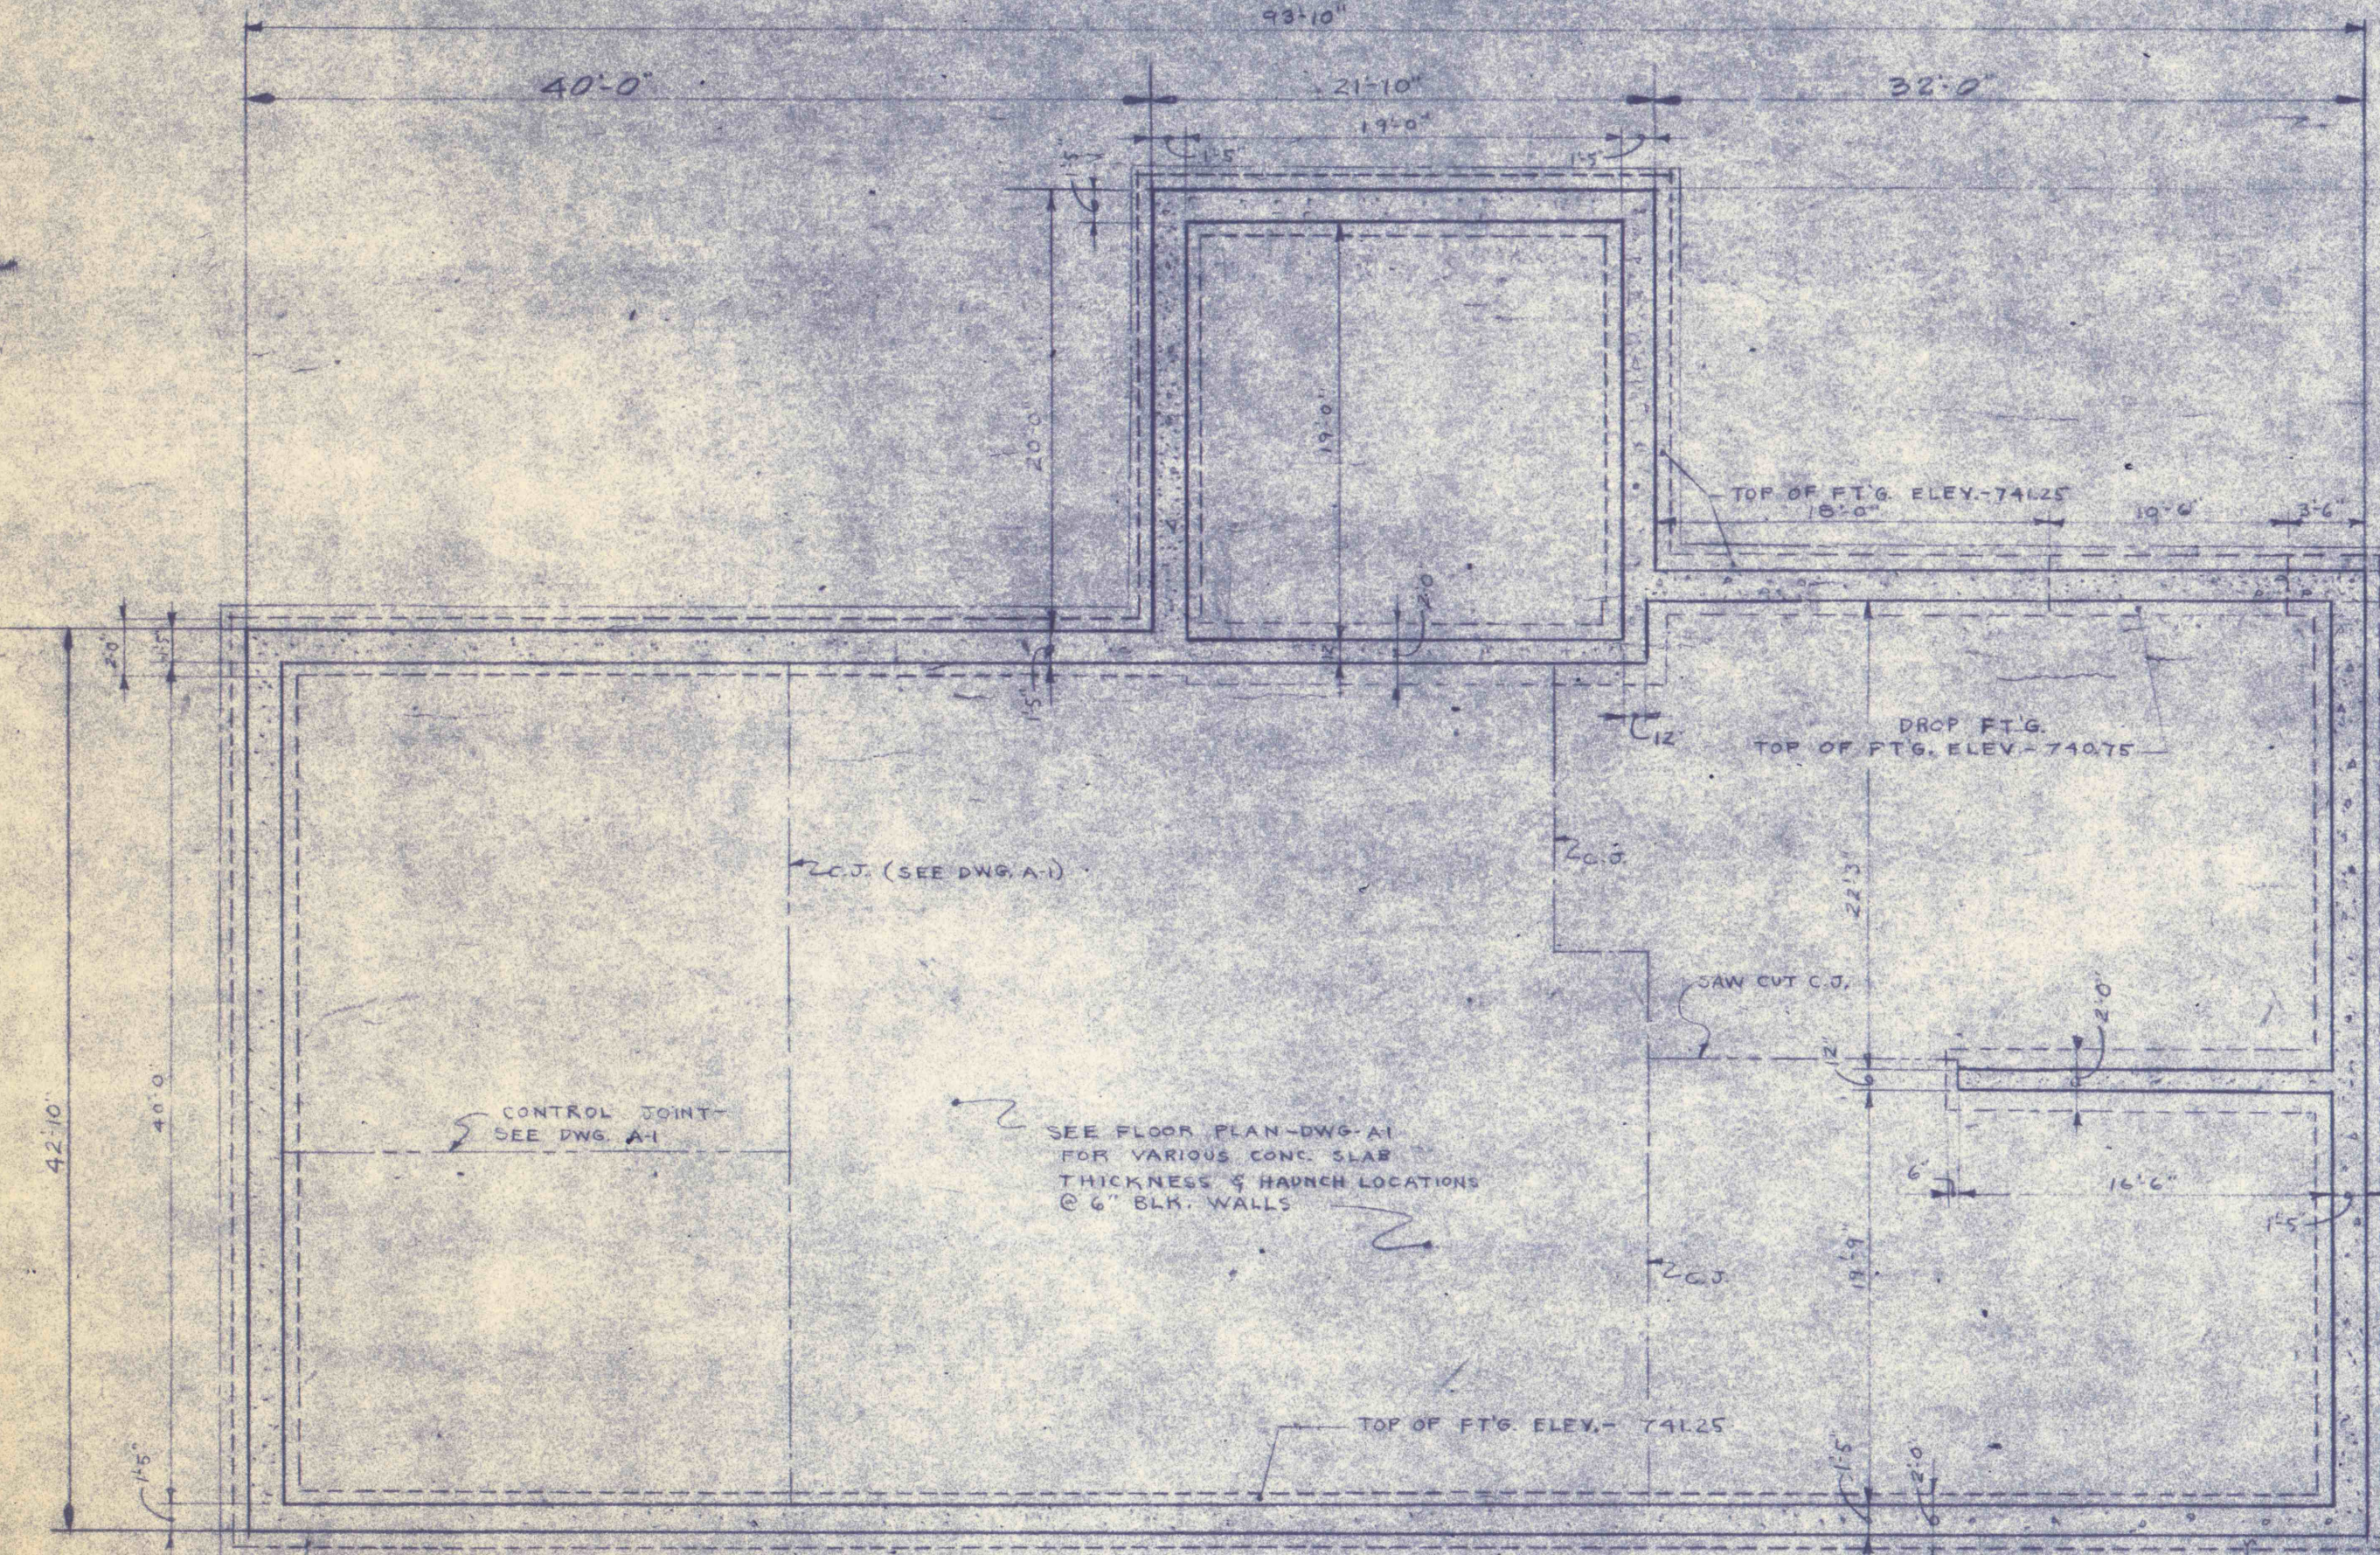

FOUNDATION PLAN


SCALE: 1/8" = 1'-0"

NOTE
ALL DIMENSIONS & EXISTING CONDITIONS SHALL BE CHECKED & VERIFIED BY THE CONTRACTORS AT THE SITE.
GENERAL CONTRACTOR TO CONSULT H & W DRAWINGS FOR BRIDGE DIMENSIONS

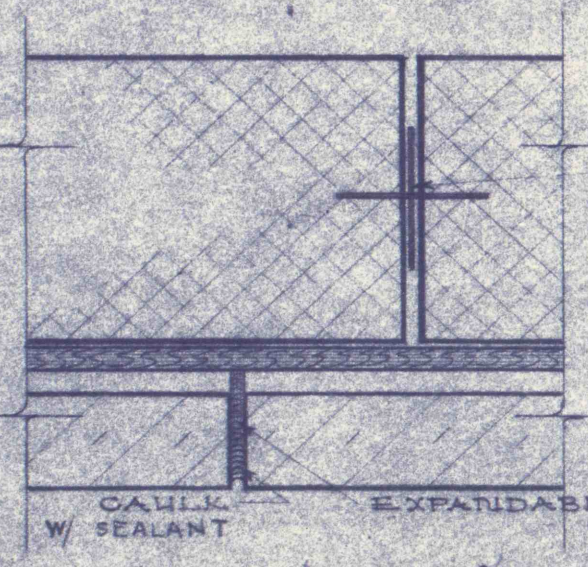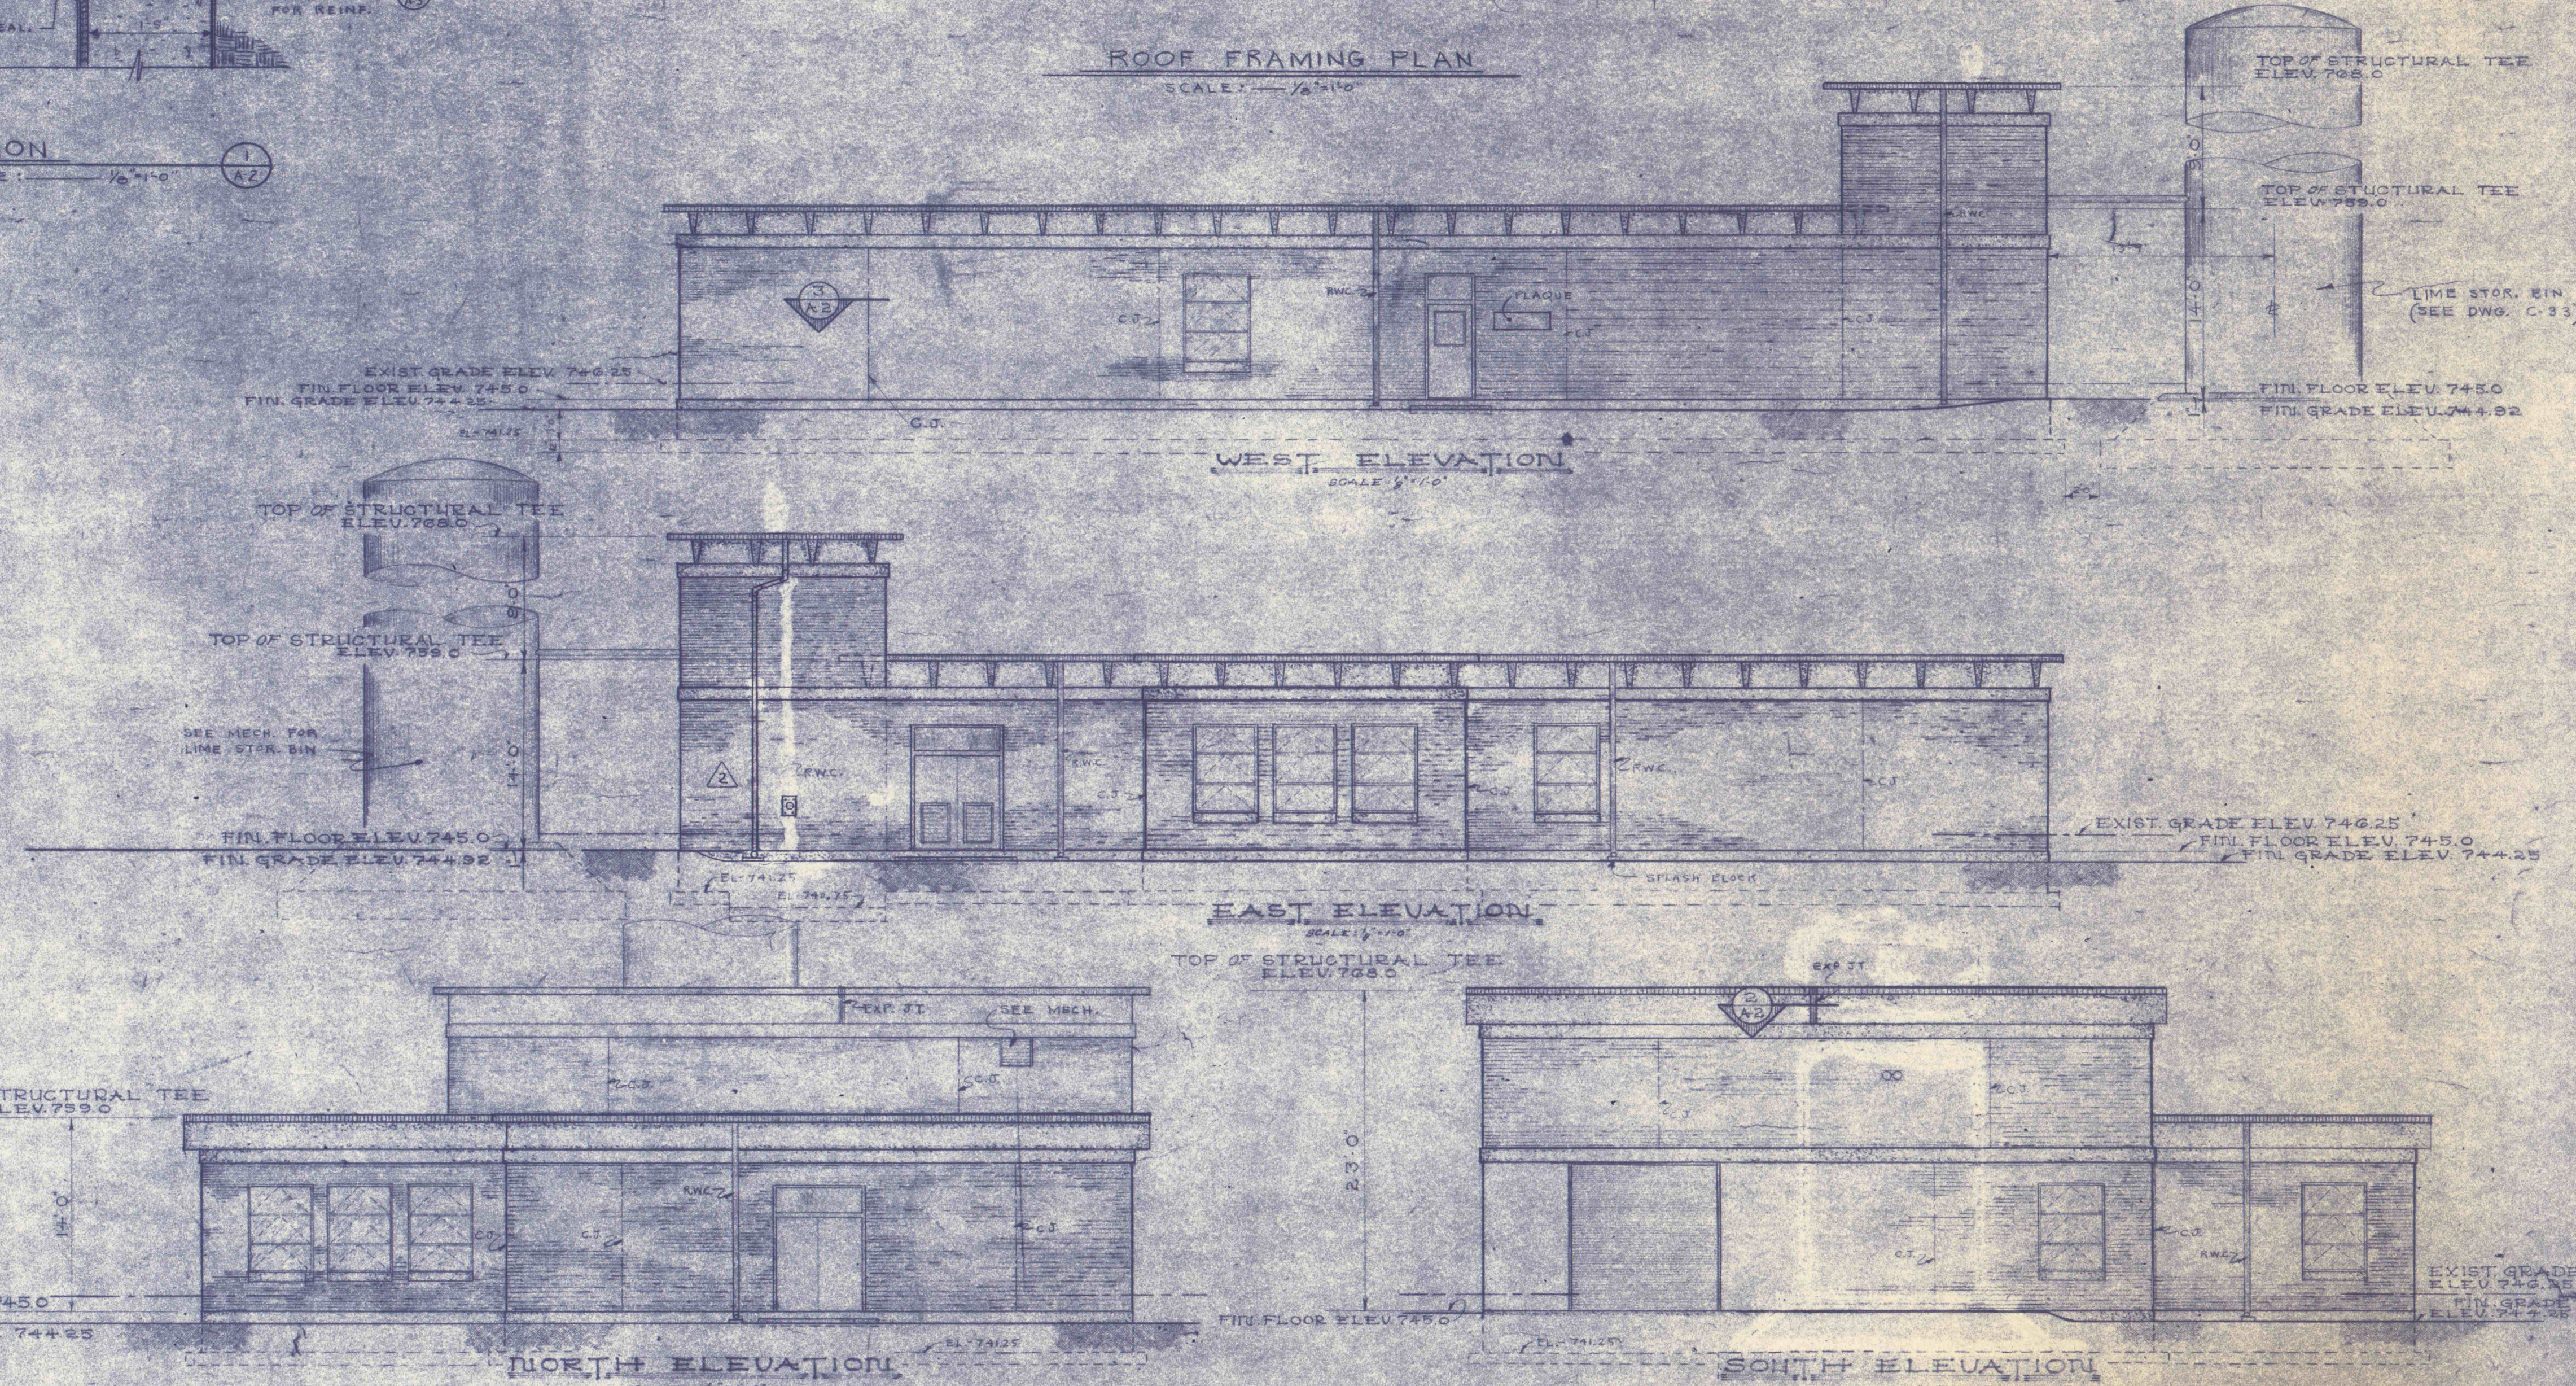


SECTION

SCALE: 3/4" = 1'-0"

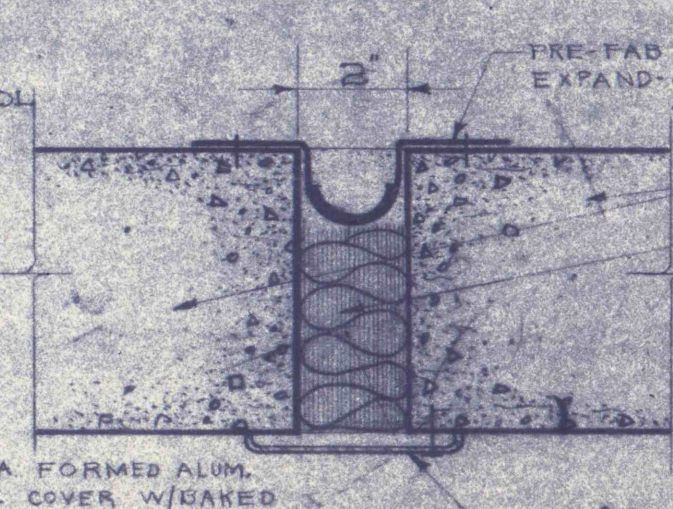

SECTION

SCALE: 3/4" = 1'-0"

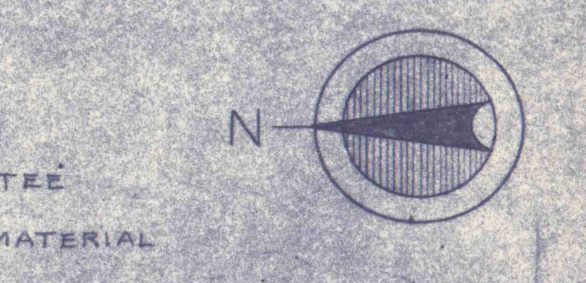

2	2/28/71	MOVED DOWNSPOUT FROM SLAKER ROOM ROOF AS NAD.
1	1/13/70	REMOVED 6" DRIP AS IND. (ROOF FRAMING PLAN)

PLANS - ELEVATIONS & DETAILS

CONSTRUCTION OF TREATMENT FACILITIES FOR ACID MINE DRAINAGE
RAUSCH CREEK WATERSHED
 SCHUYLKILL COUNTY PENNSYLVANIA

ANTHRACTITE RESEARCH & DEVELOPMENT CO. INC.
 consulting engineers
 POTTSVILLE PENNSYLVANIA TAMAGUA

JOB NO. 6805
 DATE: JAN. 1970
 SCALE: 8" = 1'-0"
 DRAWN: ELET, WJR
 APPROVED: THR, JLL

DRAWING NO.
A-2