

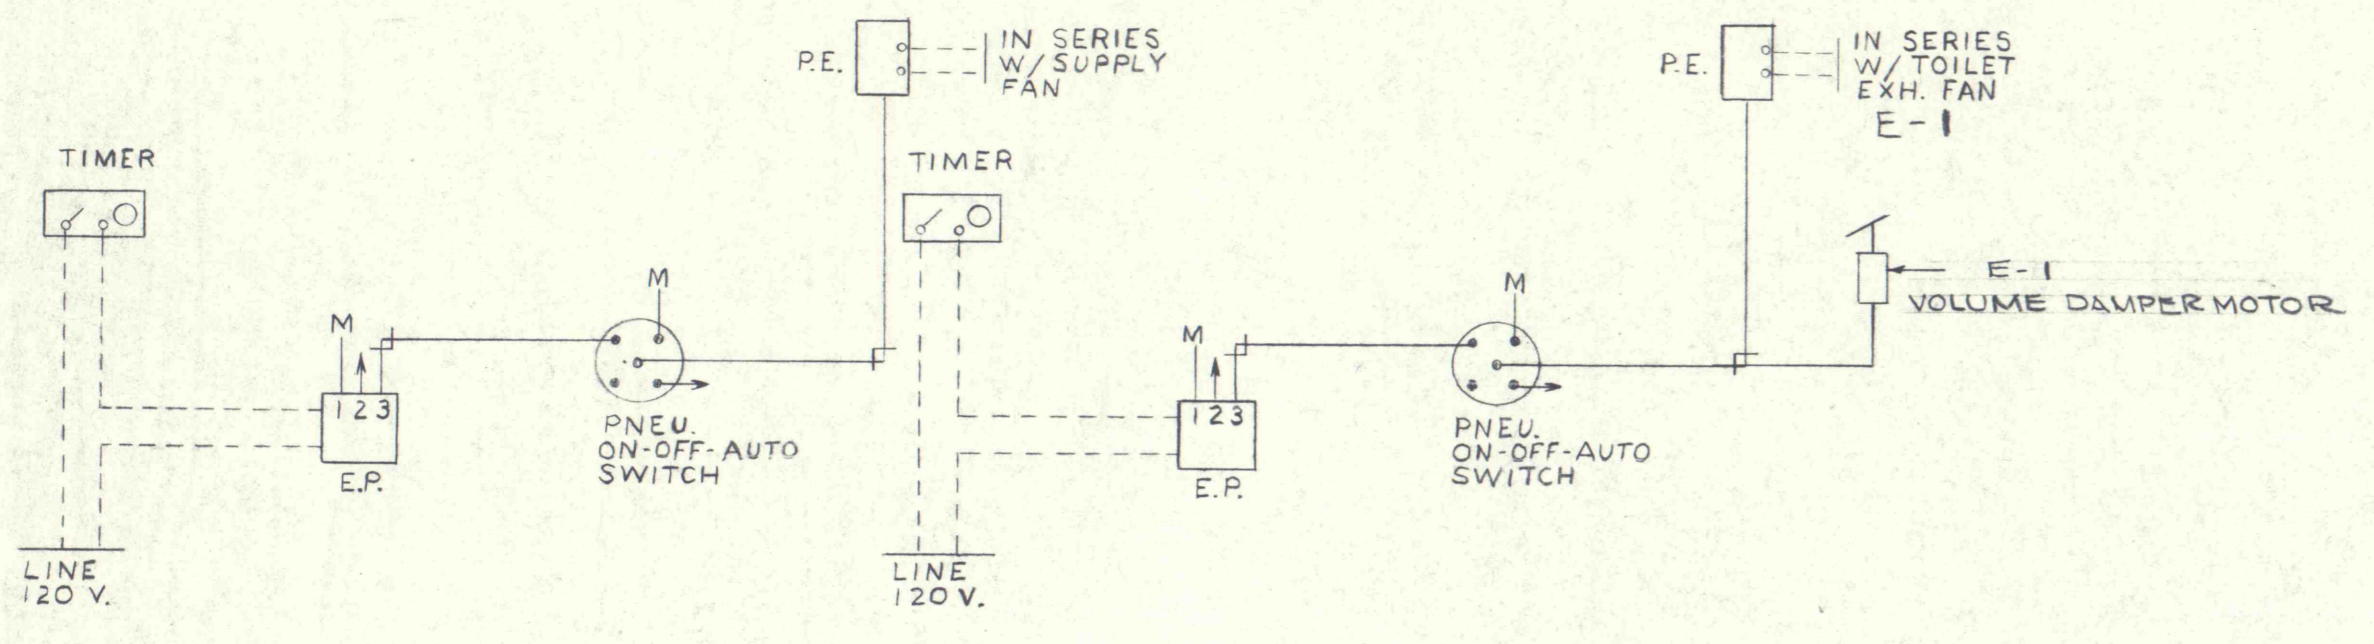



SYM.	ITEM	DESCRIPTION	DWG. & ITEM NO. OR STYLE NO.	MATL. SPEC.	REQ. FOR 1 UNIT						
					GR	GR	GR	GR	GR	GR	

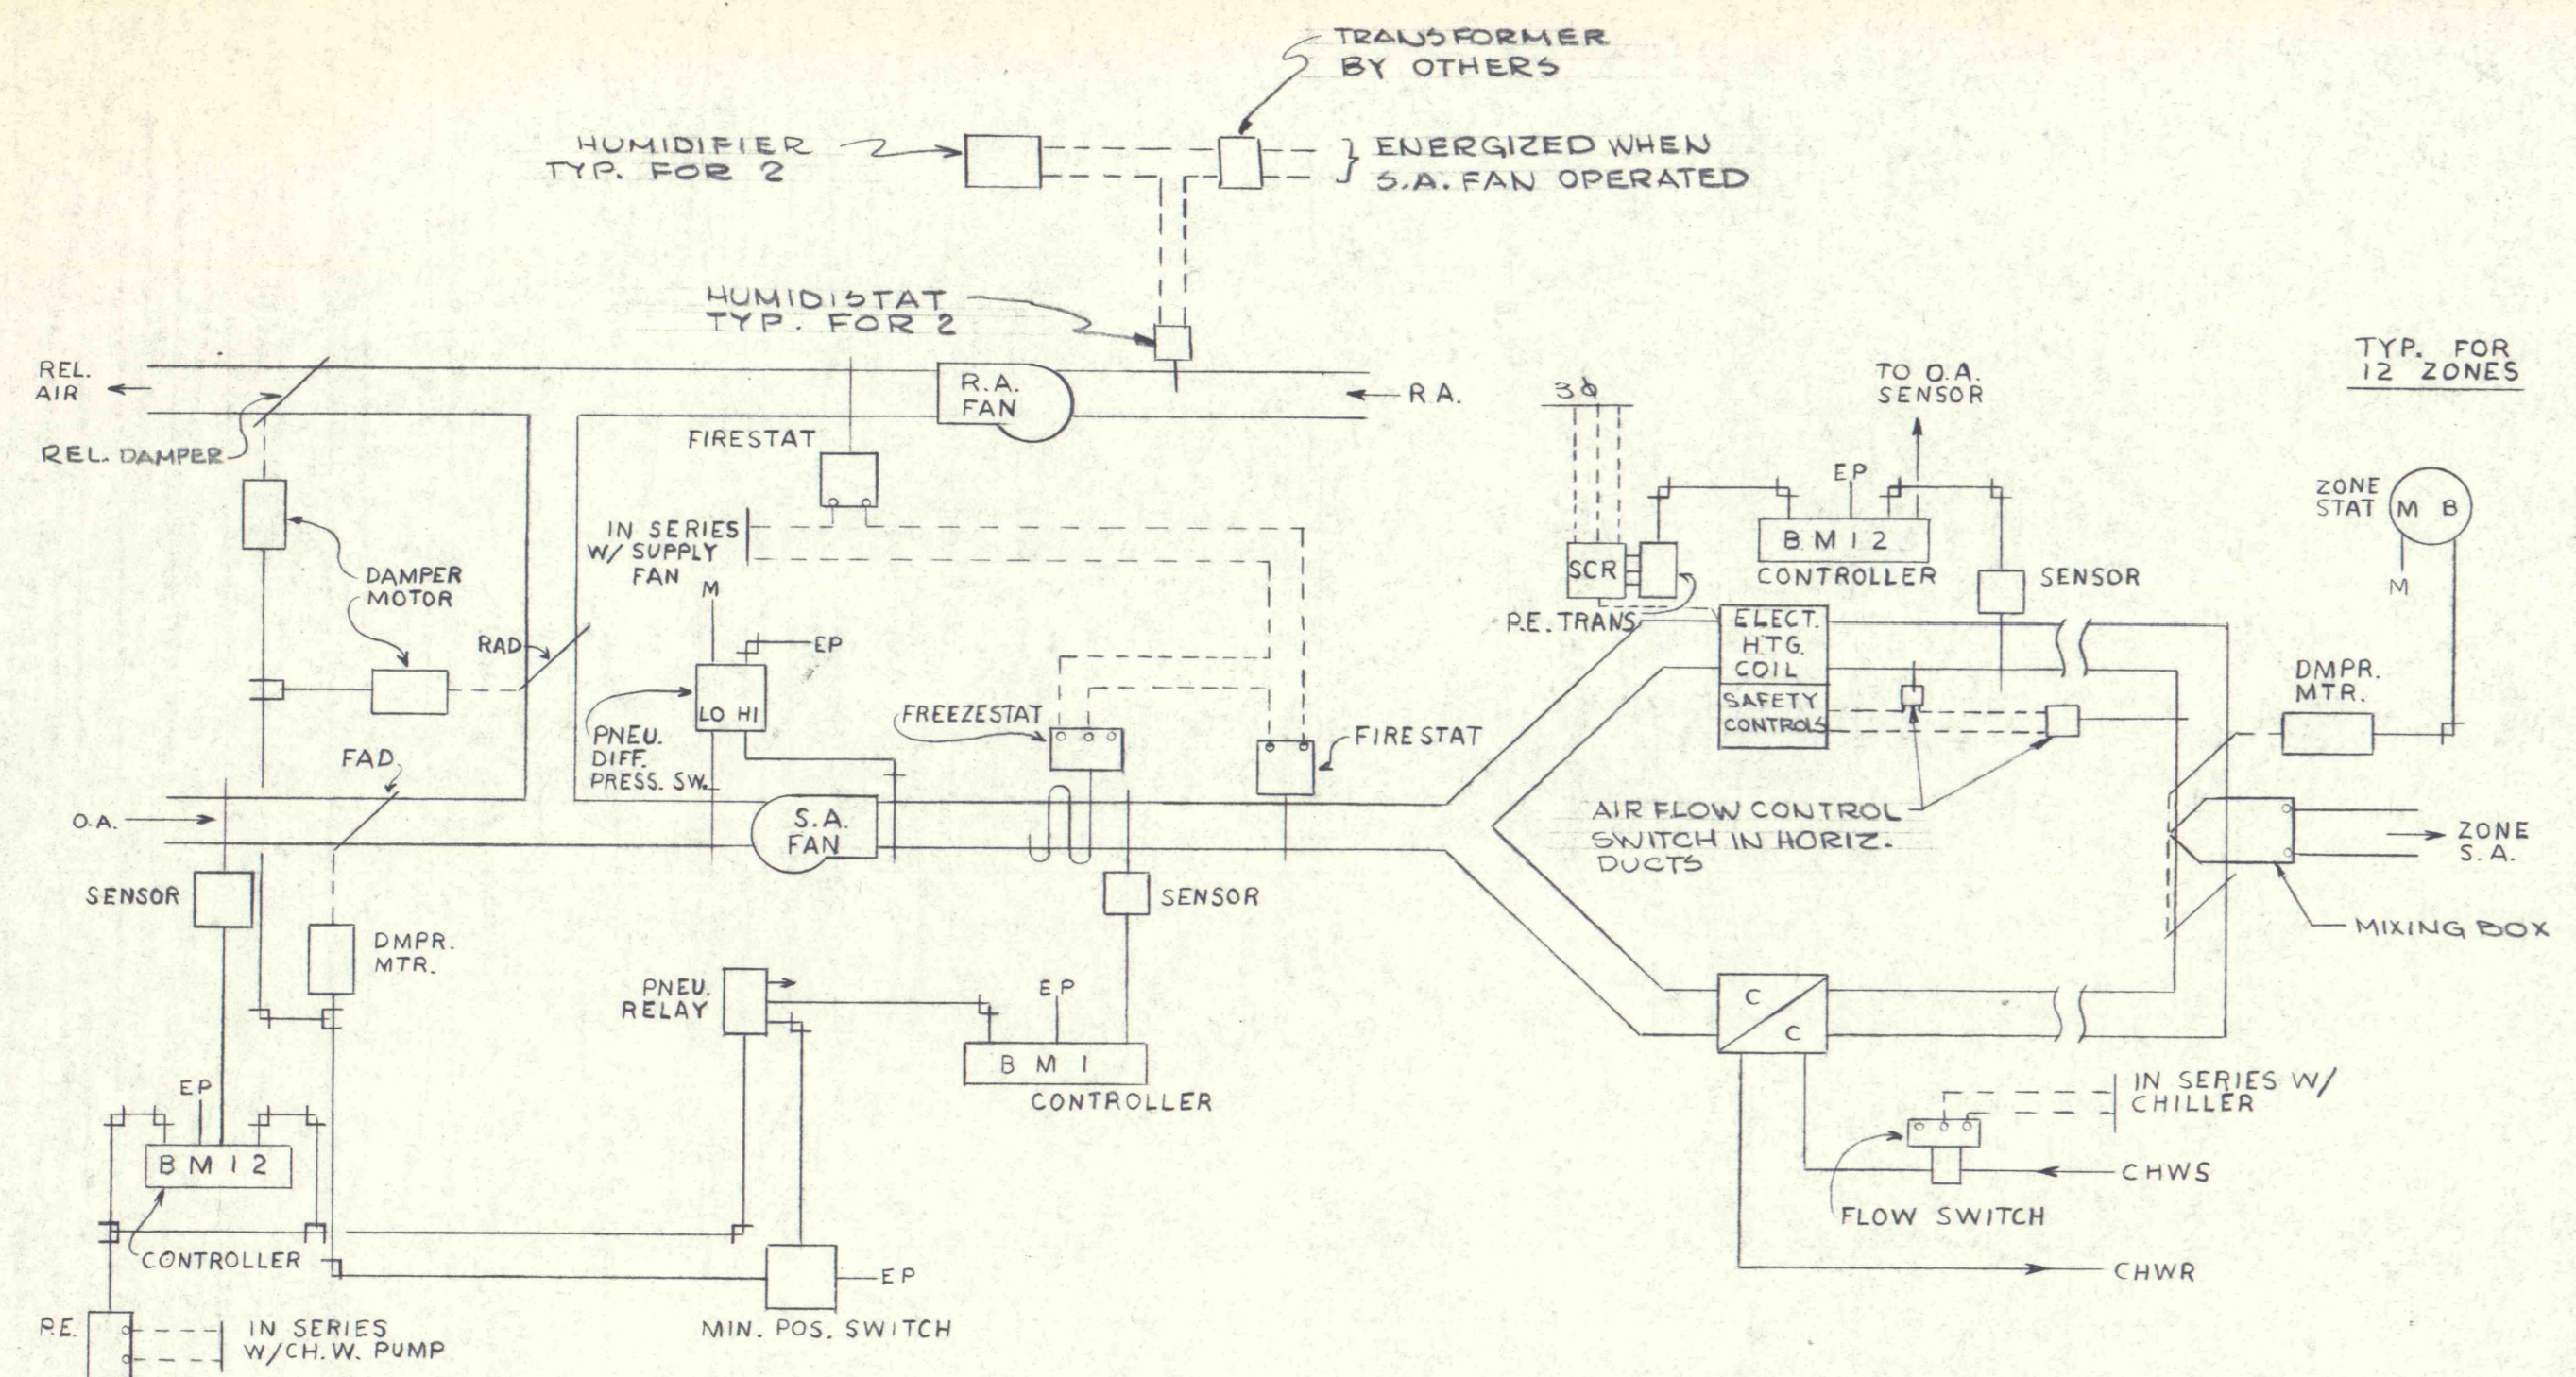


AUTO. CONTROL DIAGRAM

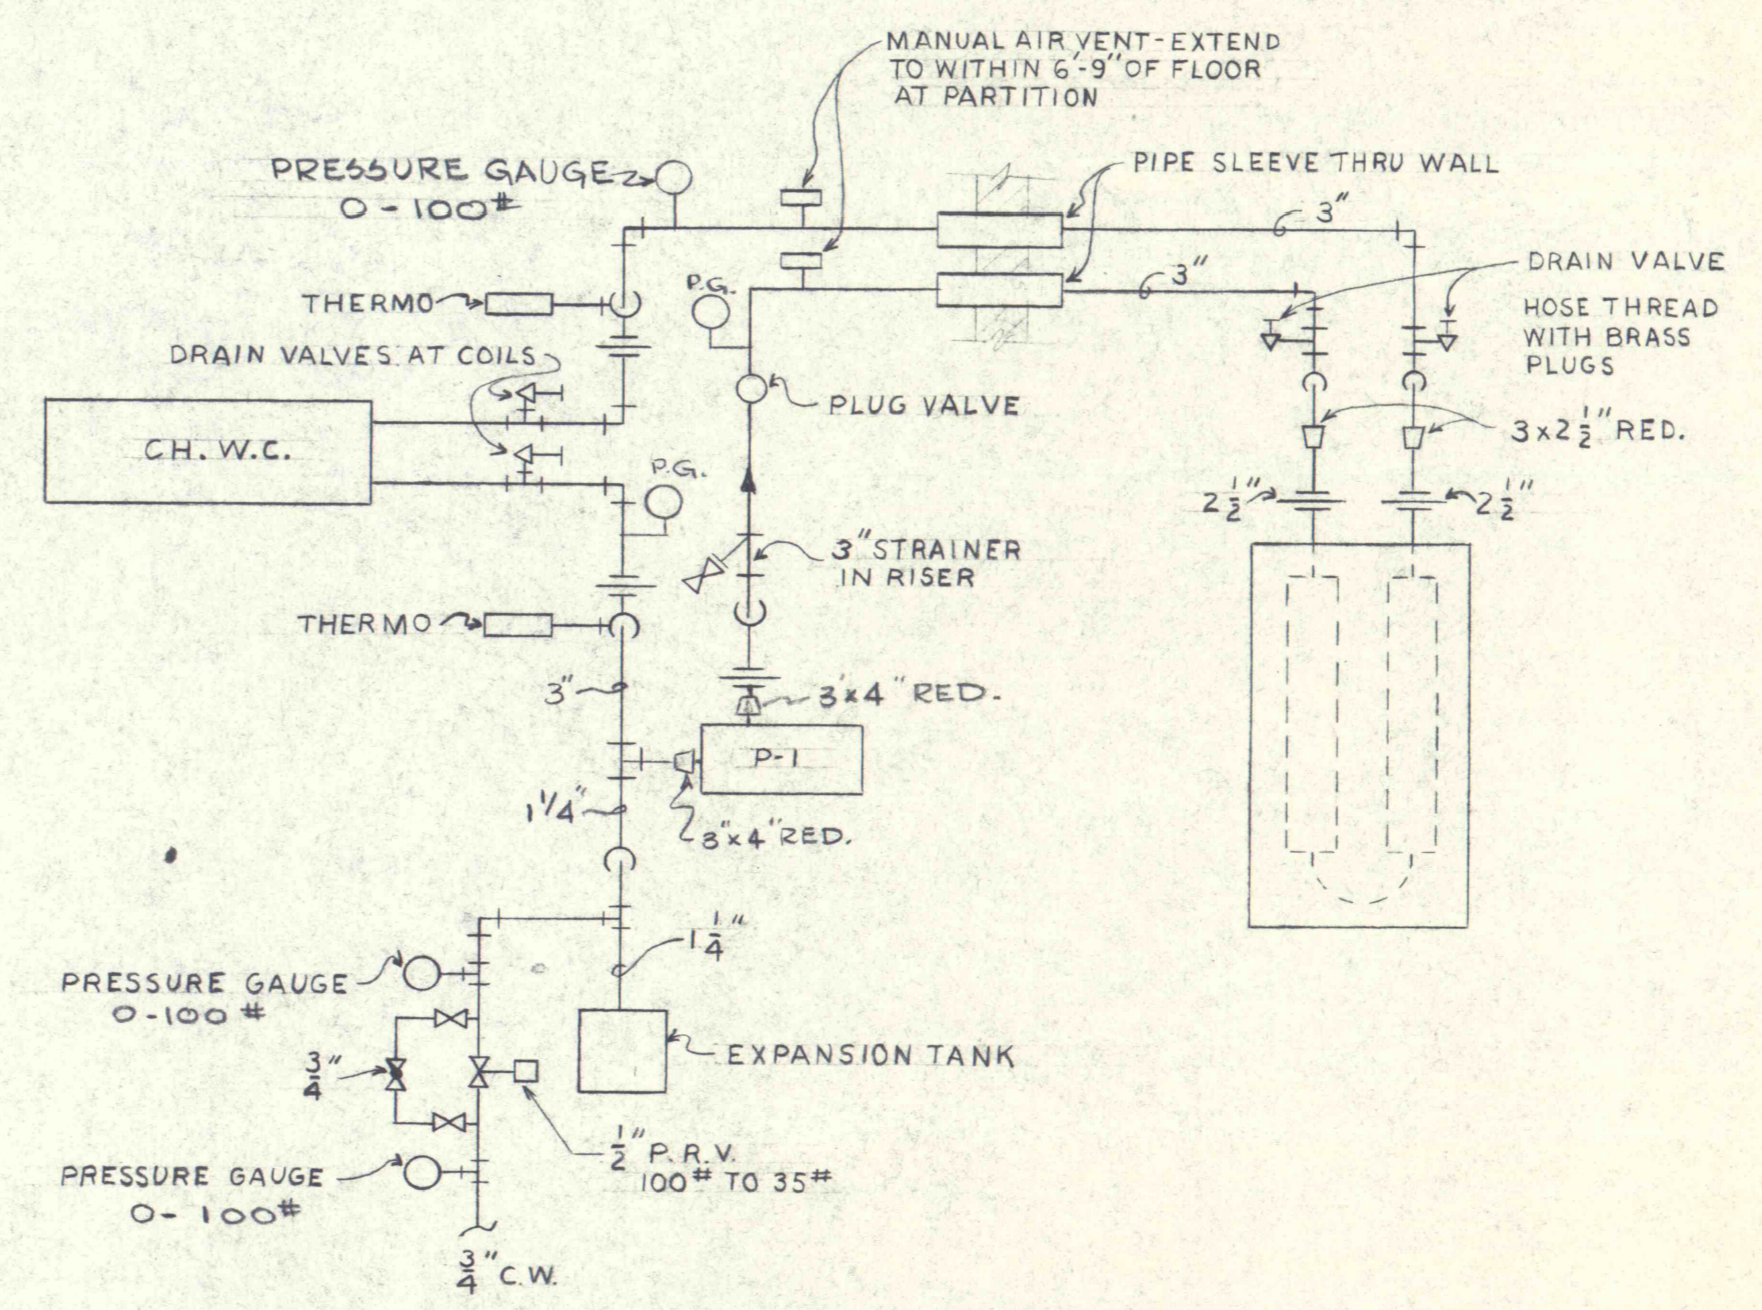

CHILLED WATER DIAGRAM  
SCALE - NONE

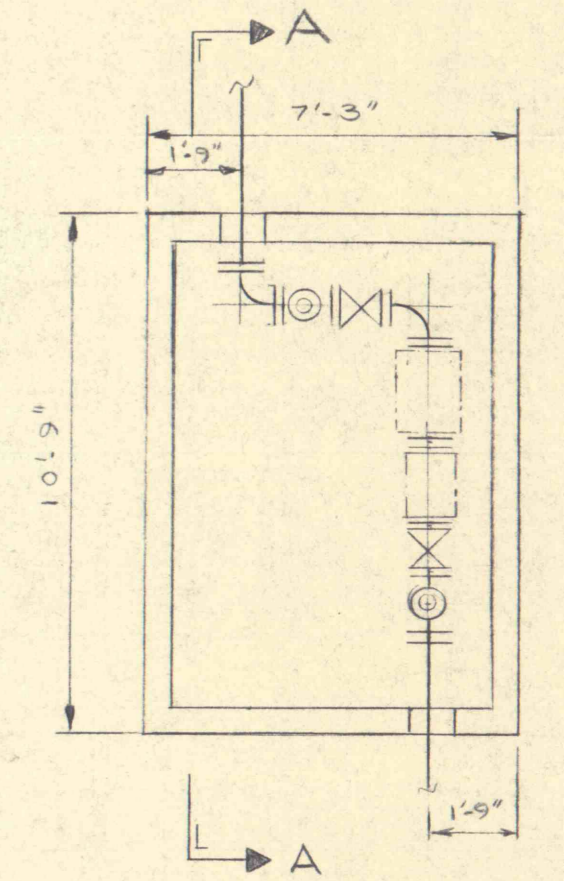

PLAN - METER PIT - PIPING  
FOR LOCATION - SEE DWG 6040 J0007  
FOR PIPING SCHEMATIC - SEE DWG 6040 D0661  
FOR DETAIL OF PIT - SEE DWG 6040 D0651  
SCALE: 1/4" = 1'-0"


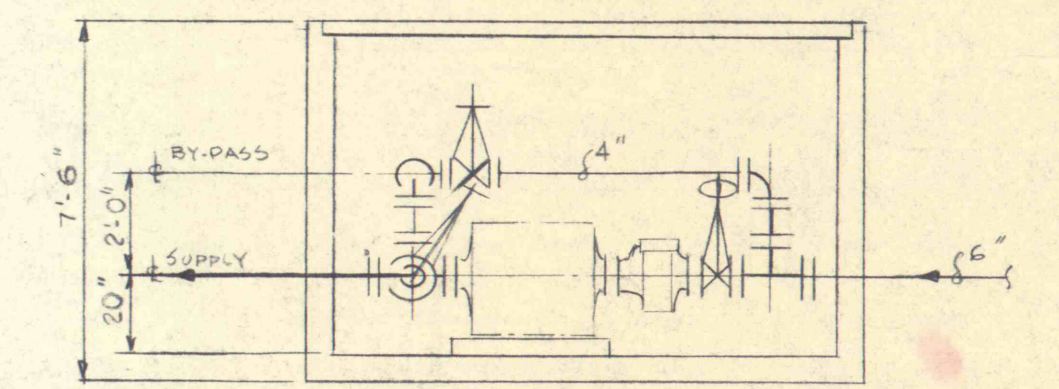


SECTION A-A  
SCALE: 1/4" = 1'-0"  
NOTE: ALL PIPING IN PIT TO HAVE 1" INSULATION.

This document is the property of, and contains proprietary information owned by, the Heat Transfer Department of Westinghouse Electric Corporation and is made available to you under a confidential relationship and subject to the following understanding, conditions and restrictions: no permission is granted to publish, use, reproduce, transmit or disclose to another this document or any information contained therein without the express written permission of said department in advance.

1  
S.O. 19A-9569  
CHANGE

DEPT	AP	PR	LAST NUMBER USED	PARTS LIST
U-1				
W-12				
MIE				
TOTAL				
DATE				

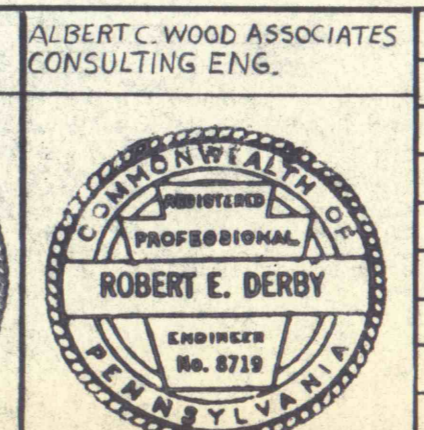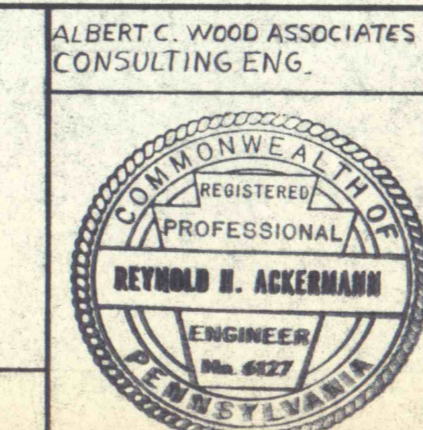

ALBERT C. WOOD ASSOCIATES CONSULTING ENG.  
ALBERT C. WOOD ASSOCIATES CONSULTING ENG.  
ISSUE DATE 12-2-70  
ENGR REF DWG

**Westinghouse Electric Corporation**

APPARATUS AND DEMINERALIZATION PLANT  
TITLE ADMINISTRATION BUILDING  
HVAC CONTROL & CHILLED WATER DIAG. SHEET NO. OF SHEETS

DFTM APP *Allen J. Pico* DESIGN APP *C.D. Buscaglia* MFG APP  
CHKD MET ENG  
L.O. D. TRAVIS MECH ENG  
6040D0663

STEAM DIVISION, LESTER, PA. U.S.A. H.T.D. 01 DEPT