


SECTION A-A

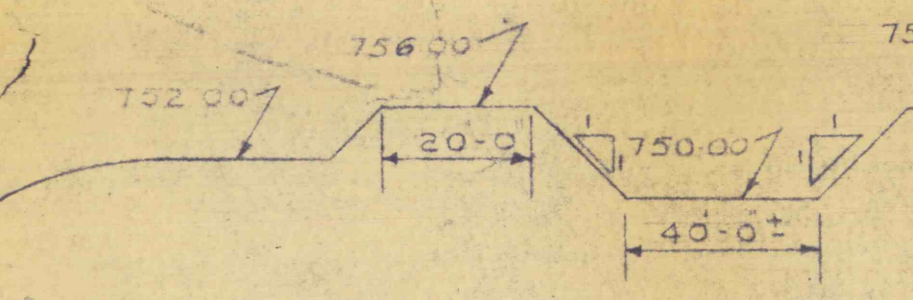

LEGEND


- 740.00 EXISTING SPOT ELEVATIONS
- - - - EXISTING CONTOURS
- - - - EXISTING UTILITY POLE
- TOP OF NEW CUT OR FILL BANKS
- TOP OF NEW CUT OR FILL BANKS
- FINISH GRADE
- NEW MANHOLE
- NEW CATCH BASIN
- SITING/INQUIRY MARKING
- CONCRETE PAVING
- DRAINAGE SWALE
- INDICATES DRAINAGE FLOW
- PROPERTY LINE

GENERAL NOTES

1. SEE DWG. C-1 FOR PLOT PLAN.
2. SEE DWG. C-2 FOR PIPING LAYOUT PLAN.
3. SEE DWG. C-3 FOR LANDSCAPING PLAN.
4. SEE DWG. C-4 FOR RECONSTRUCTION SITE DETAILS.
5. THE PROPERTY LINE IS THE LIMIT OF CONTRACT.

B.M. ELEV. 791.385
 TABLET DESIGNATED '15 H.L.Z. 1968'
 LOCATED S.W.C. OF BRIDGE OVER
 RAUSCH CREEK. (DWG. C-7)

SECTION B-B

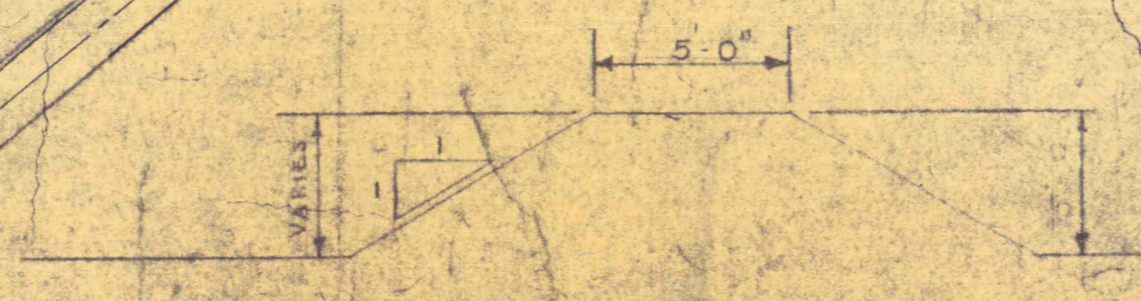

2	03/20	REVISED RIGHT WALL OF HEADWORKS
1	04/10	REVISED DIKES, HEADWORKS CHANNEL, LEE

GRADING PLAN

CONSTRUCTION OF TREATMENT FACILITIES
 OF ACID MINE DRAINAGE
RAUSCH CREEK WATERSHED
 SCHUYLKILL COUNTY PENNSYLVANIA

ANTHRACITE
 RESEARCH & DEVELOPMENT CO. INC.
 consulting engineers
 POTTSVILLE PENNSYLVANIA TAMAGUA

JOB NO: 6805
 DATE: 11/15/70
 SCALE: 1" = 50'
 DRAWN: J.W.W.
 APPROVED: T.H.R.

DRAWING NO: **C-2**

