




INDEX TO DRAWINGS		
SHEET NO.	DWG. NO.	TITLE
1		LOCATION TUNNEL PROFILES, EXISTING CONDITIONS
2		GROUTING DETAILS, MISCELLANEOUS DETAILS
3		CONSTRUCTION DETAILS
4		ELECTRICAL DETAILS, SECURITY FENCE DETAILS

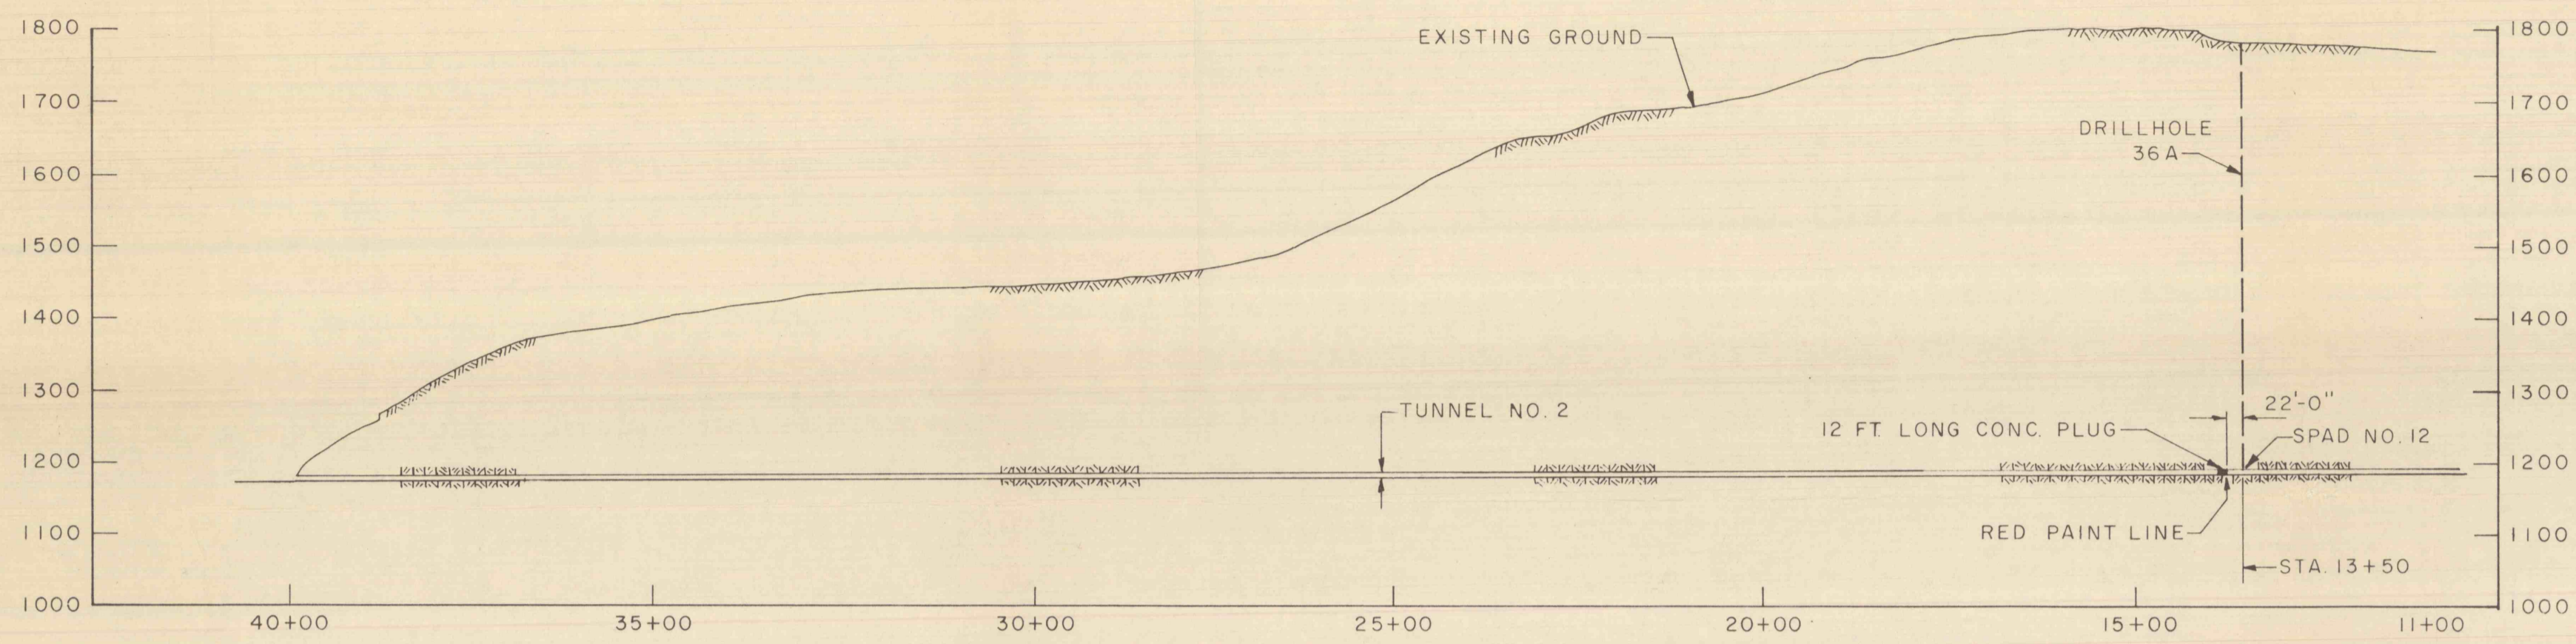

PROFILE-TUNNEL NO. 2
SCALE: 1"=200'

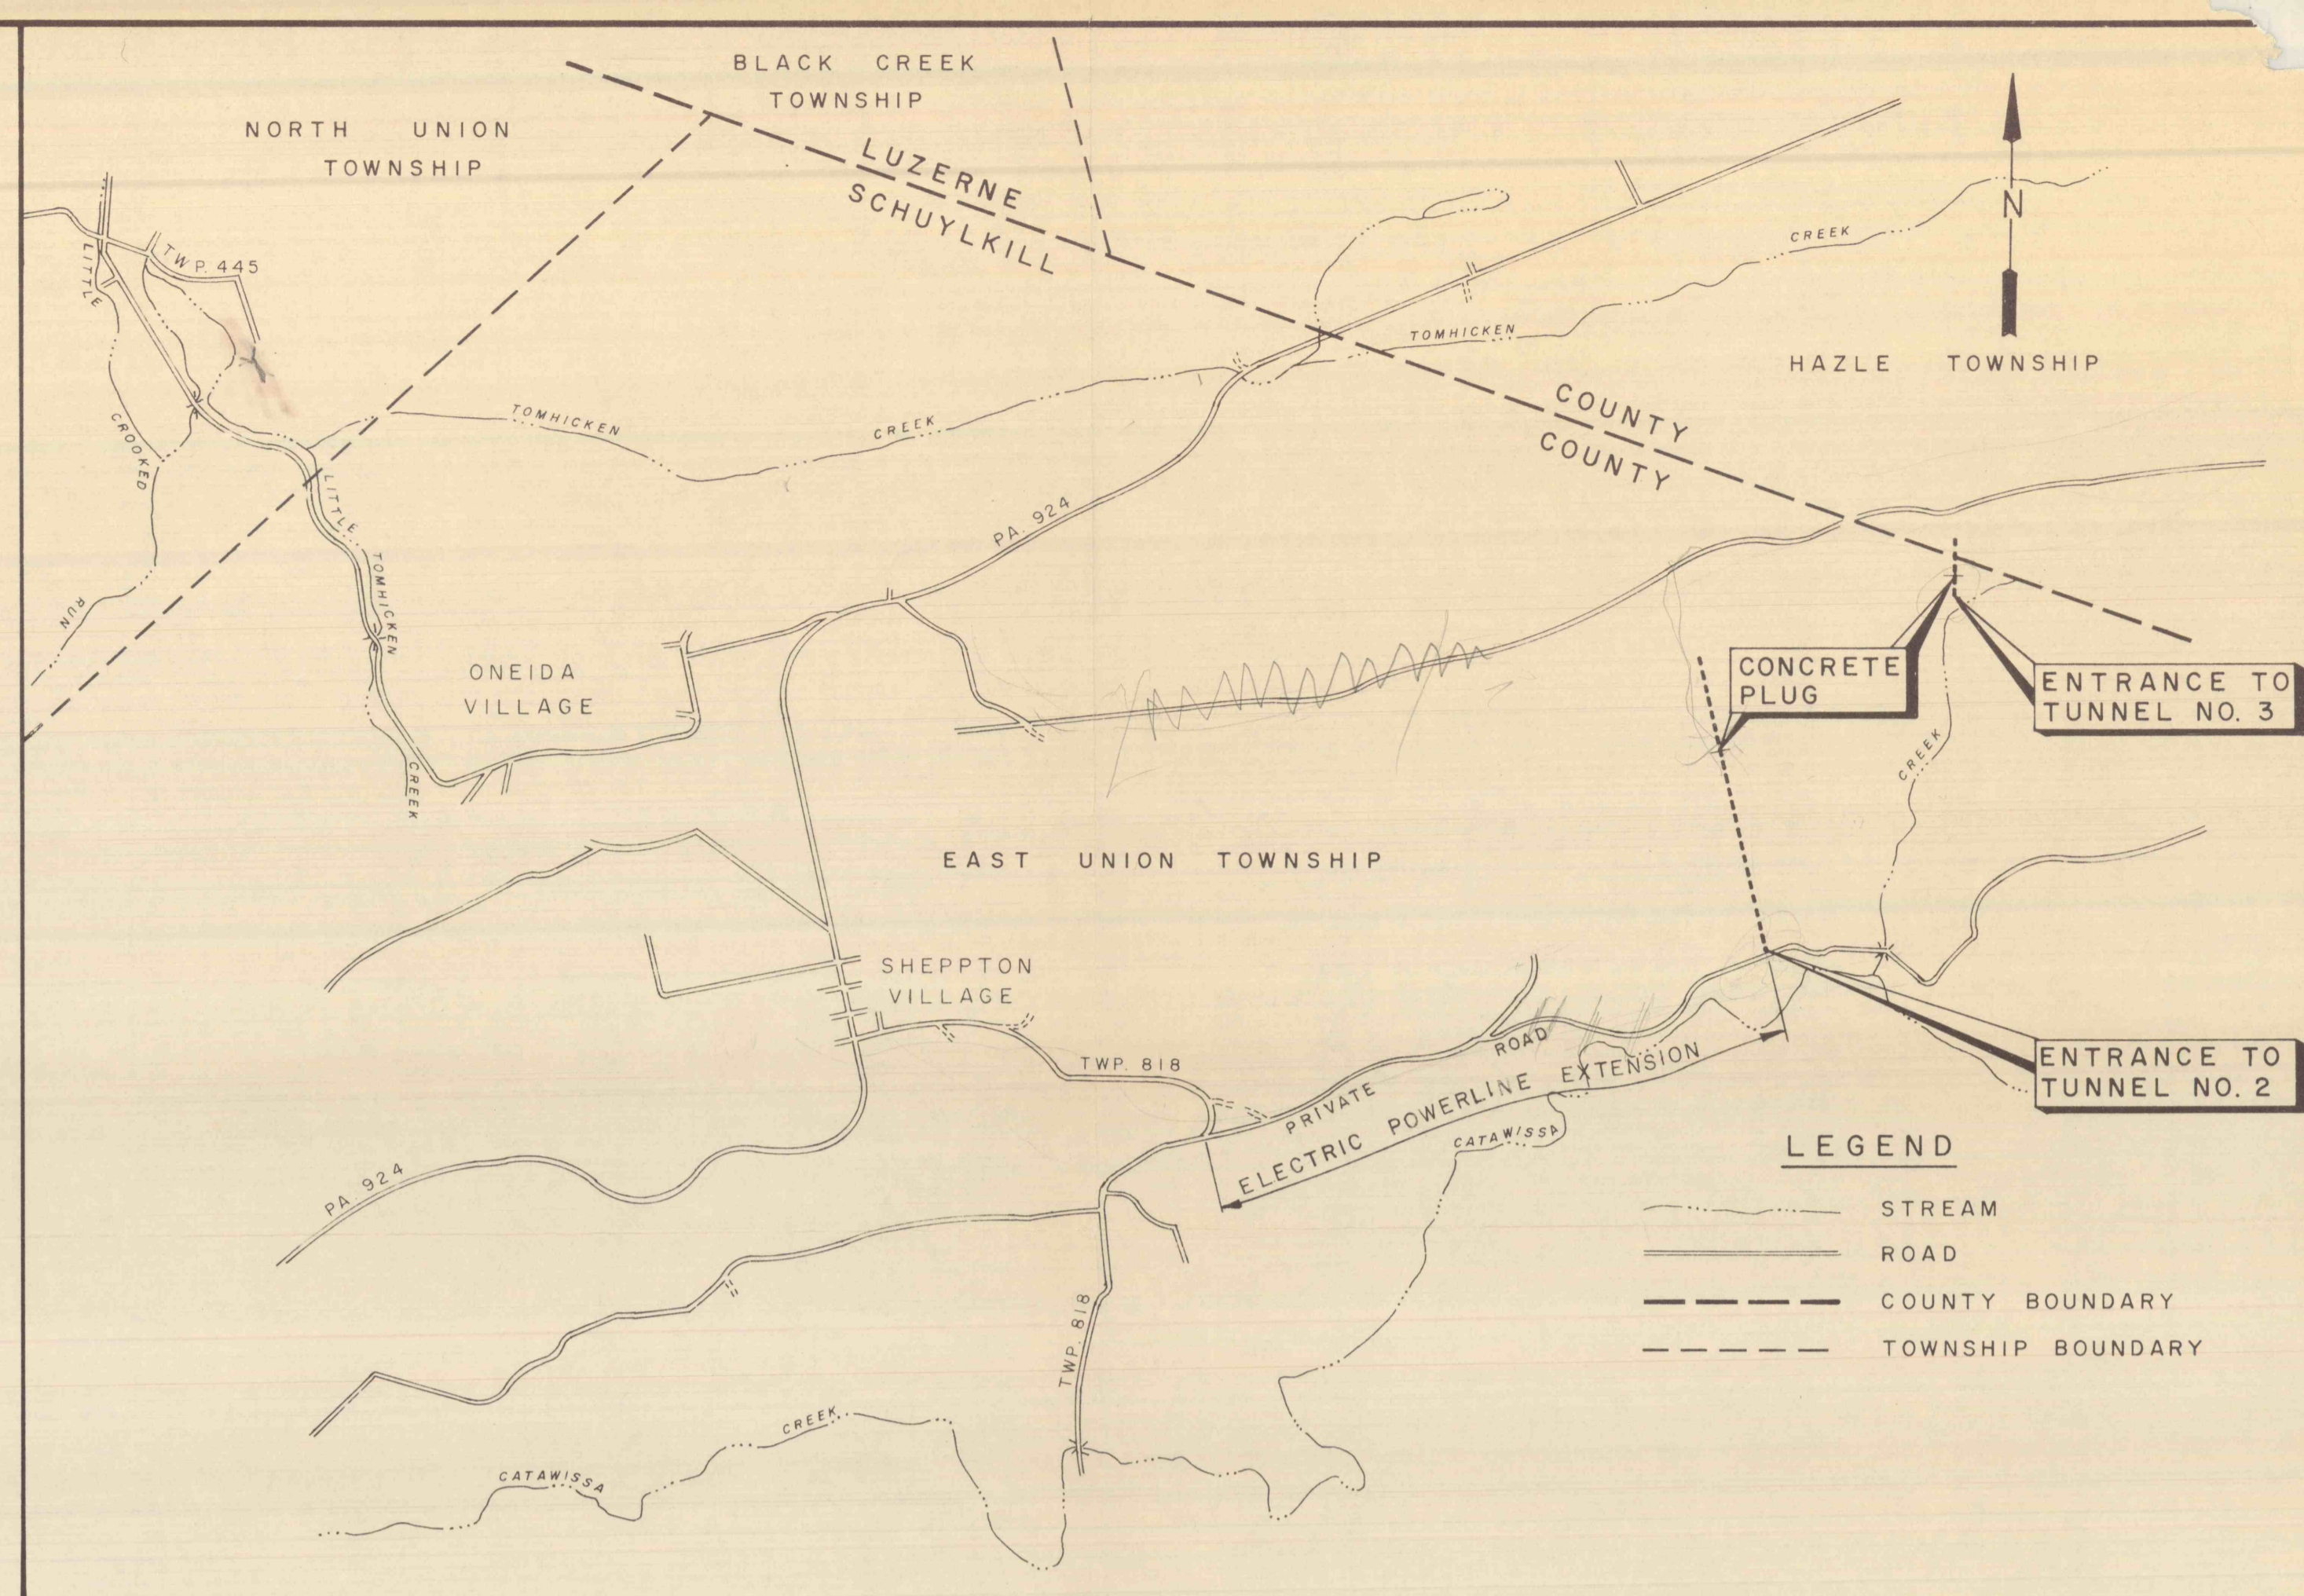


LOCATION PLAN
SCALE: 1"=2000'

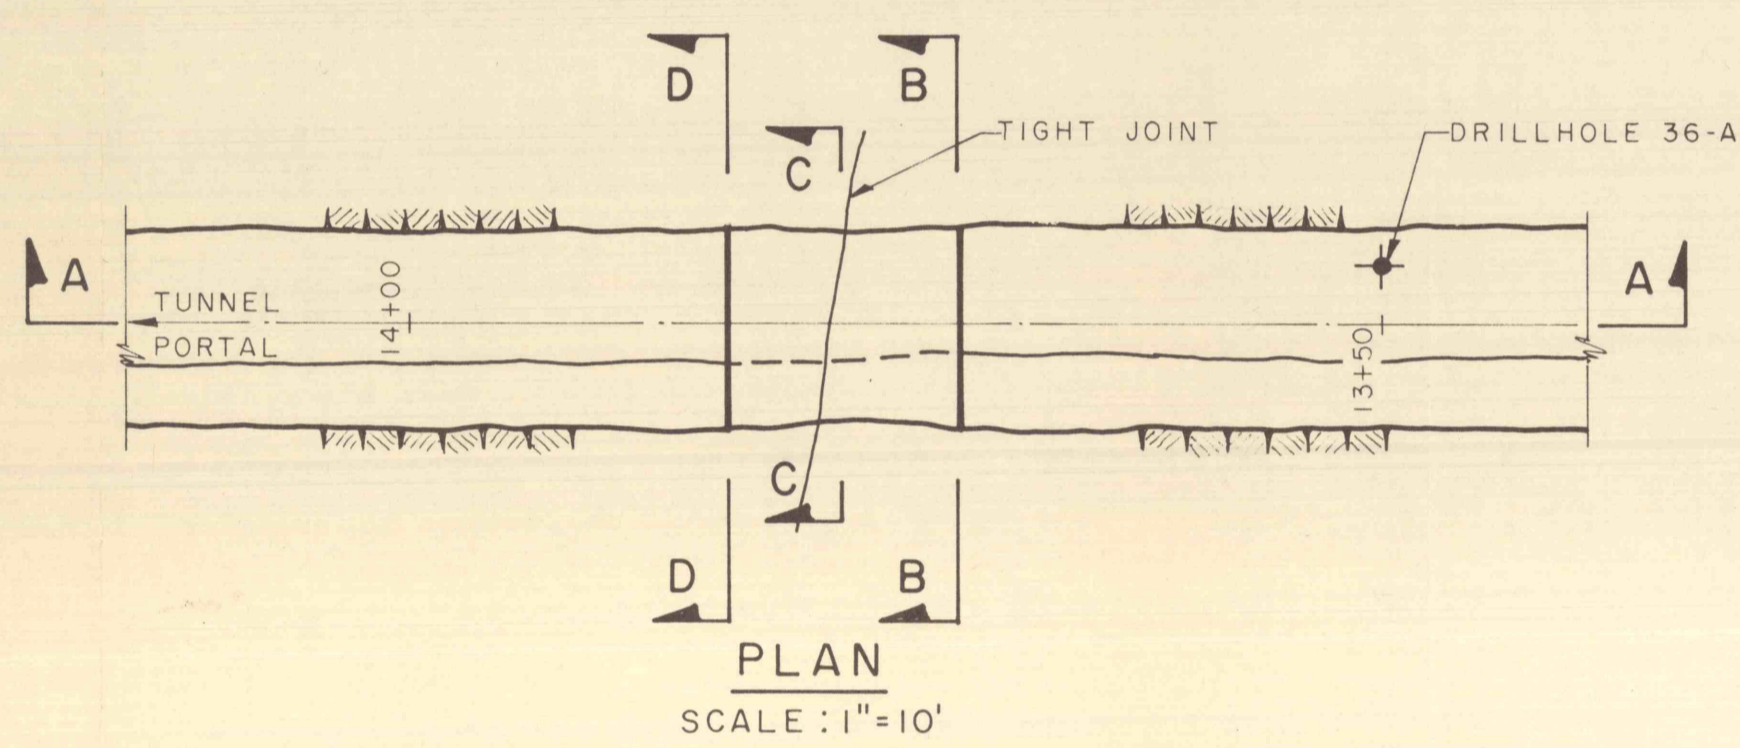


PLAN
SCALE: 1"=10'


*Access?
Property Lines?*

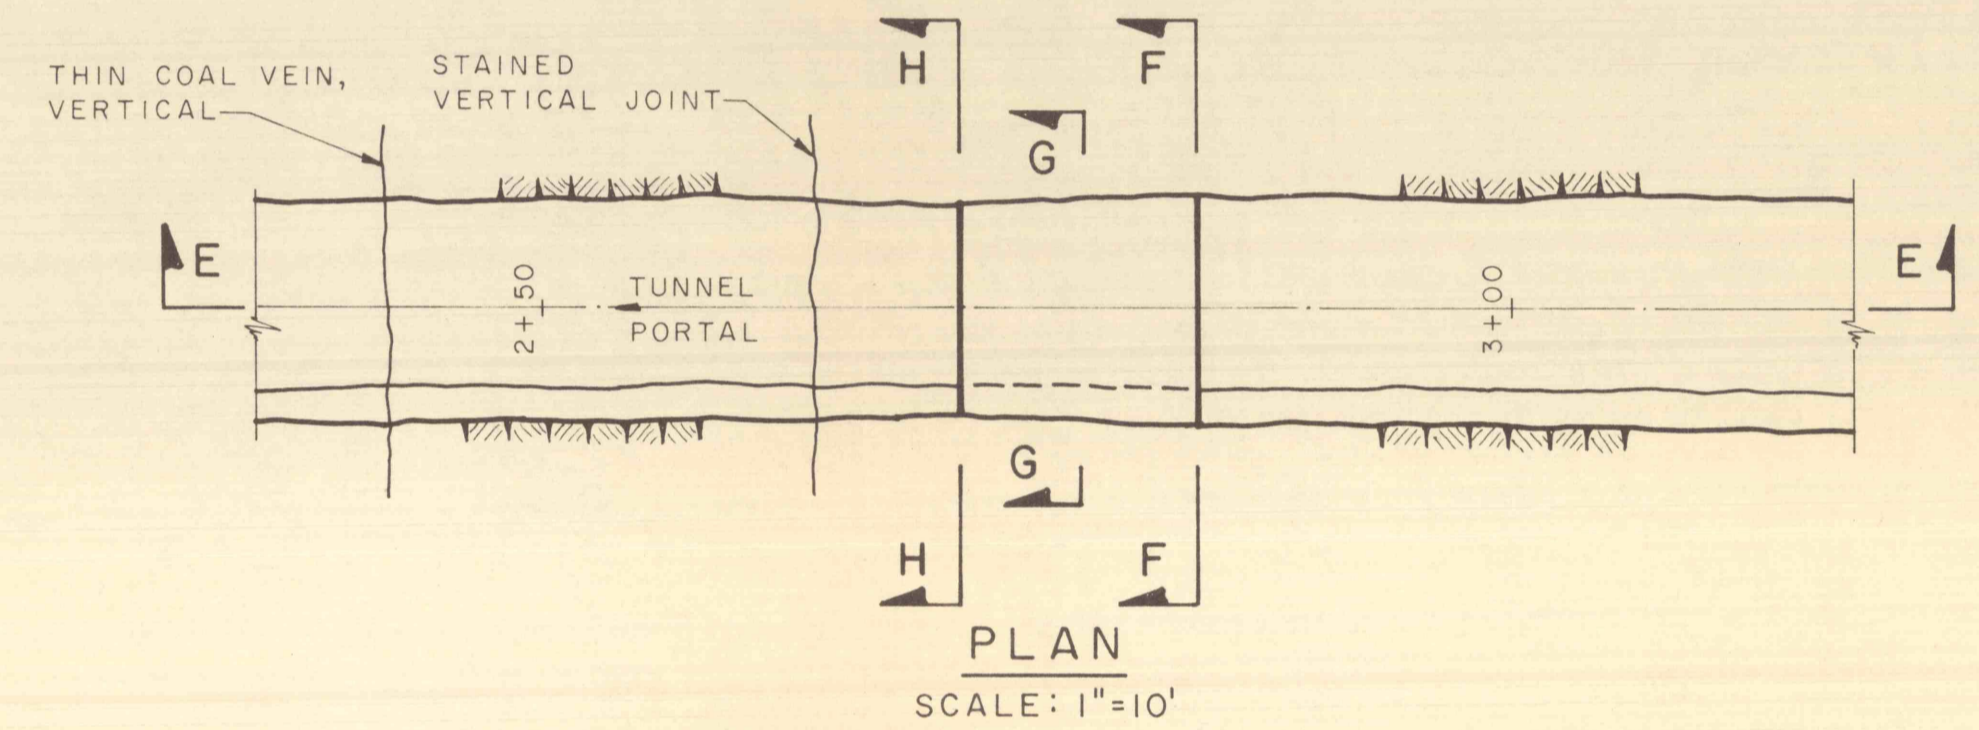


PLAN
SCALE: 1"=10'

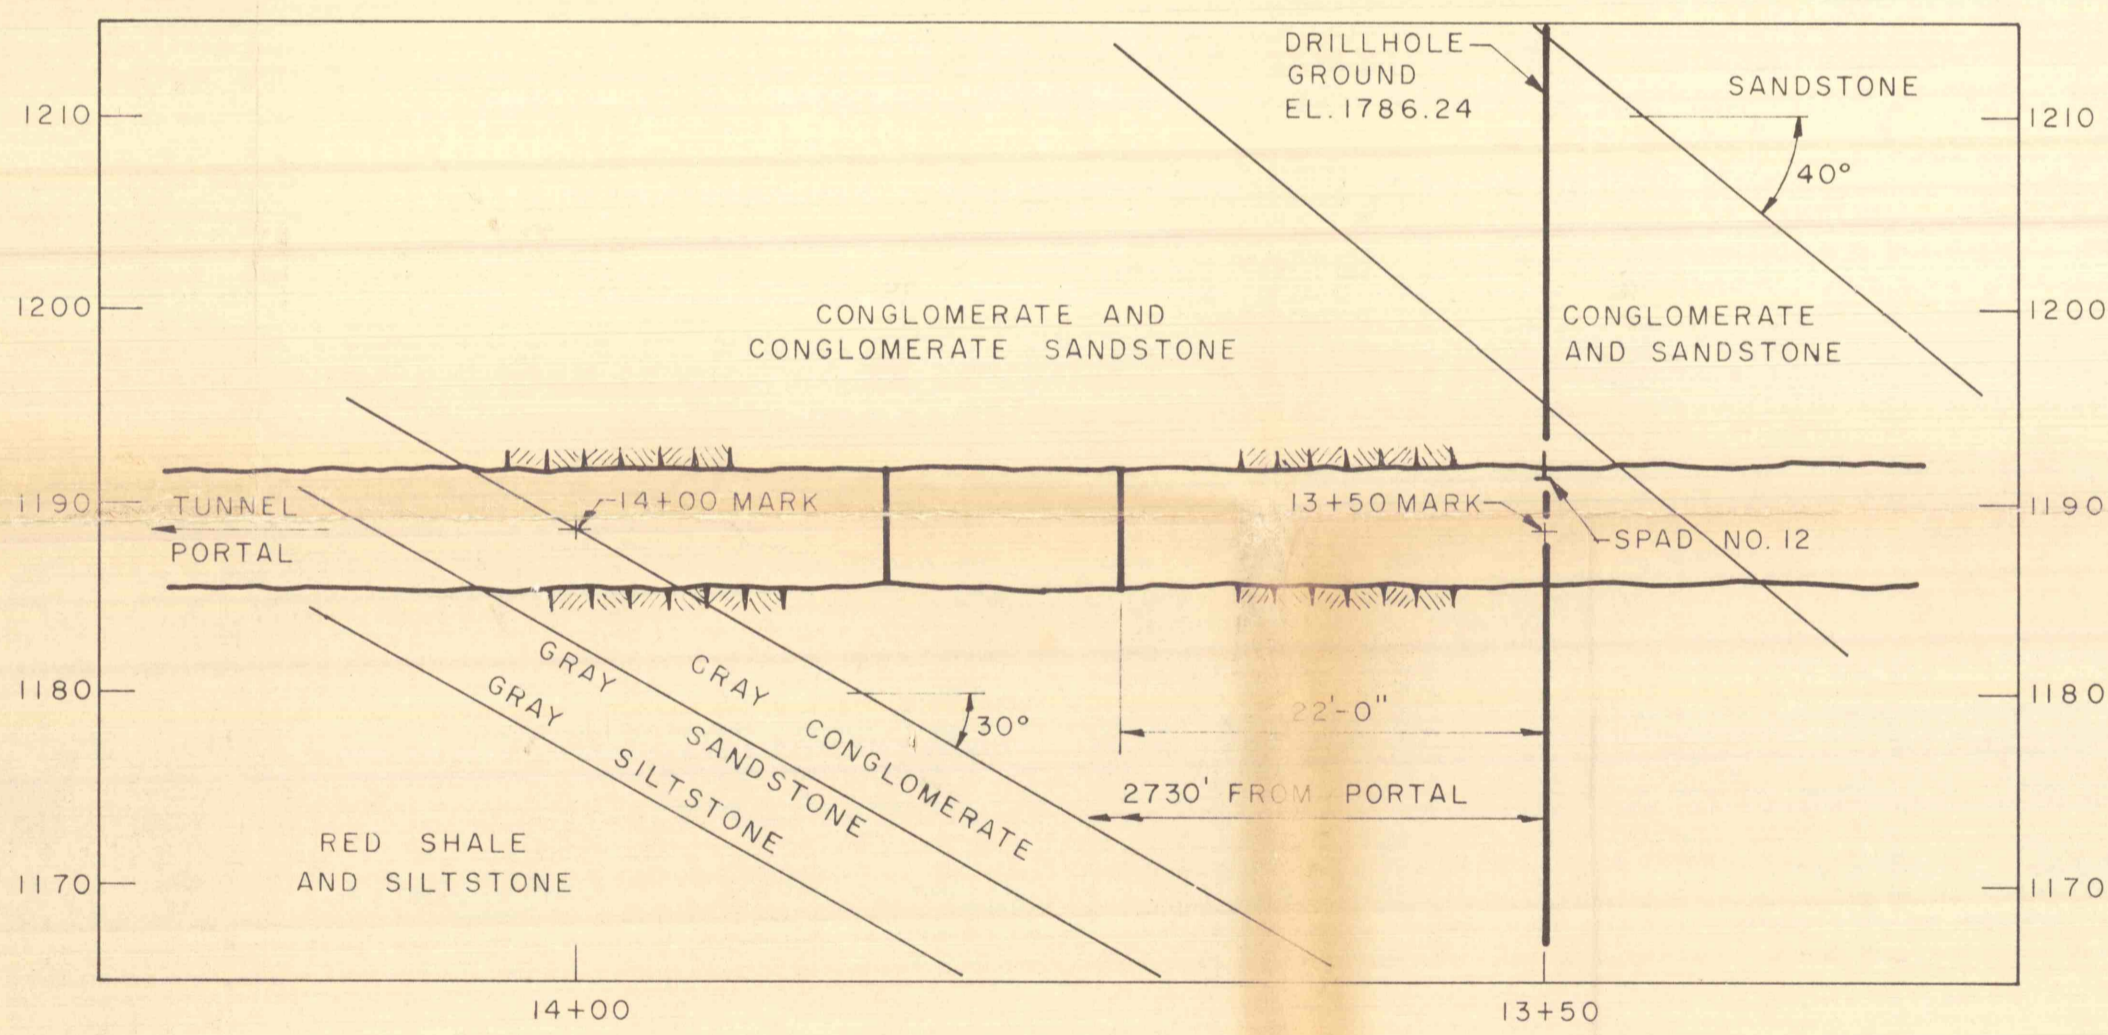


SECTION A-A
SCALE: 1"=10'

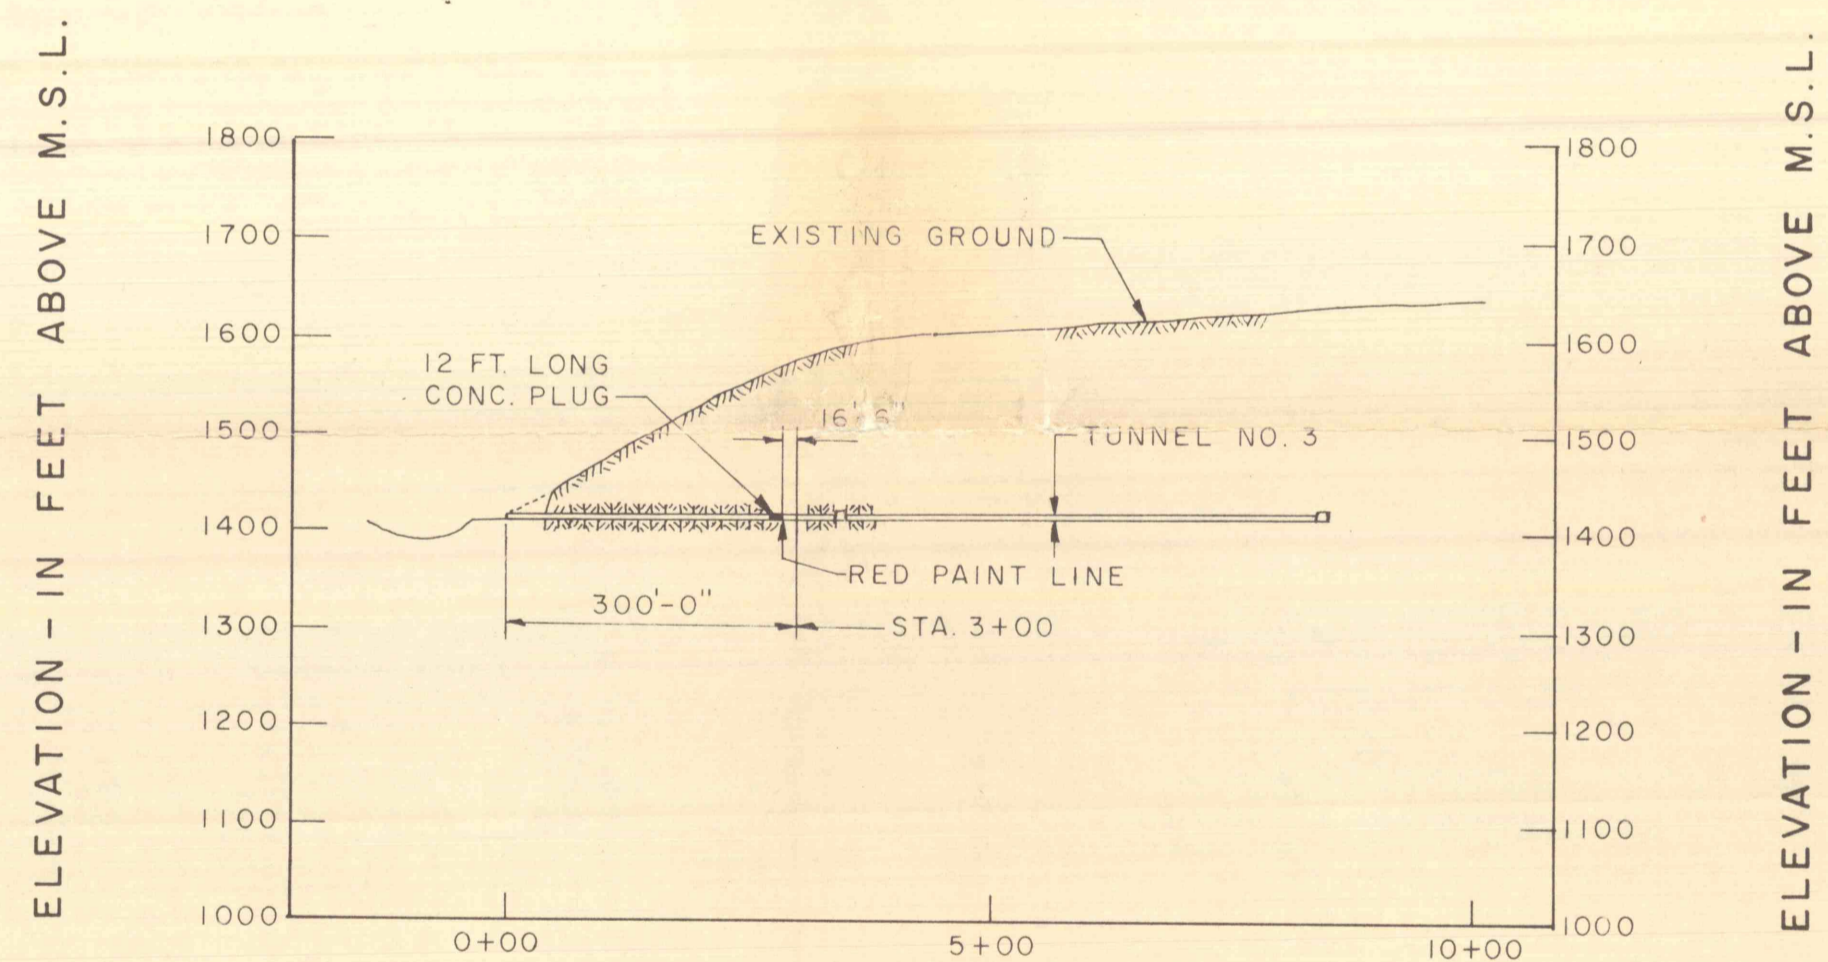


PROFILE-TUNNEL NO. 3
SCALE: 1"=200'

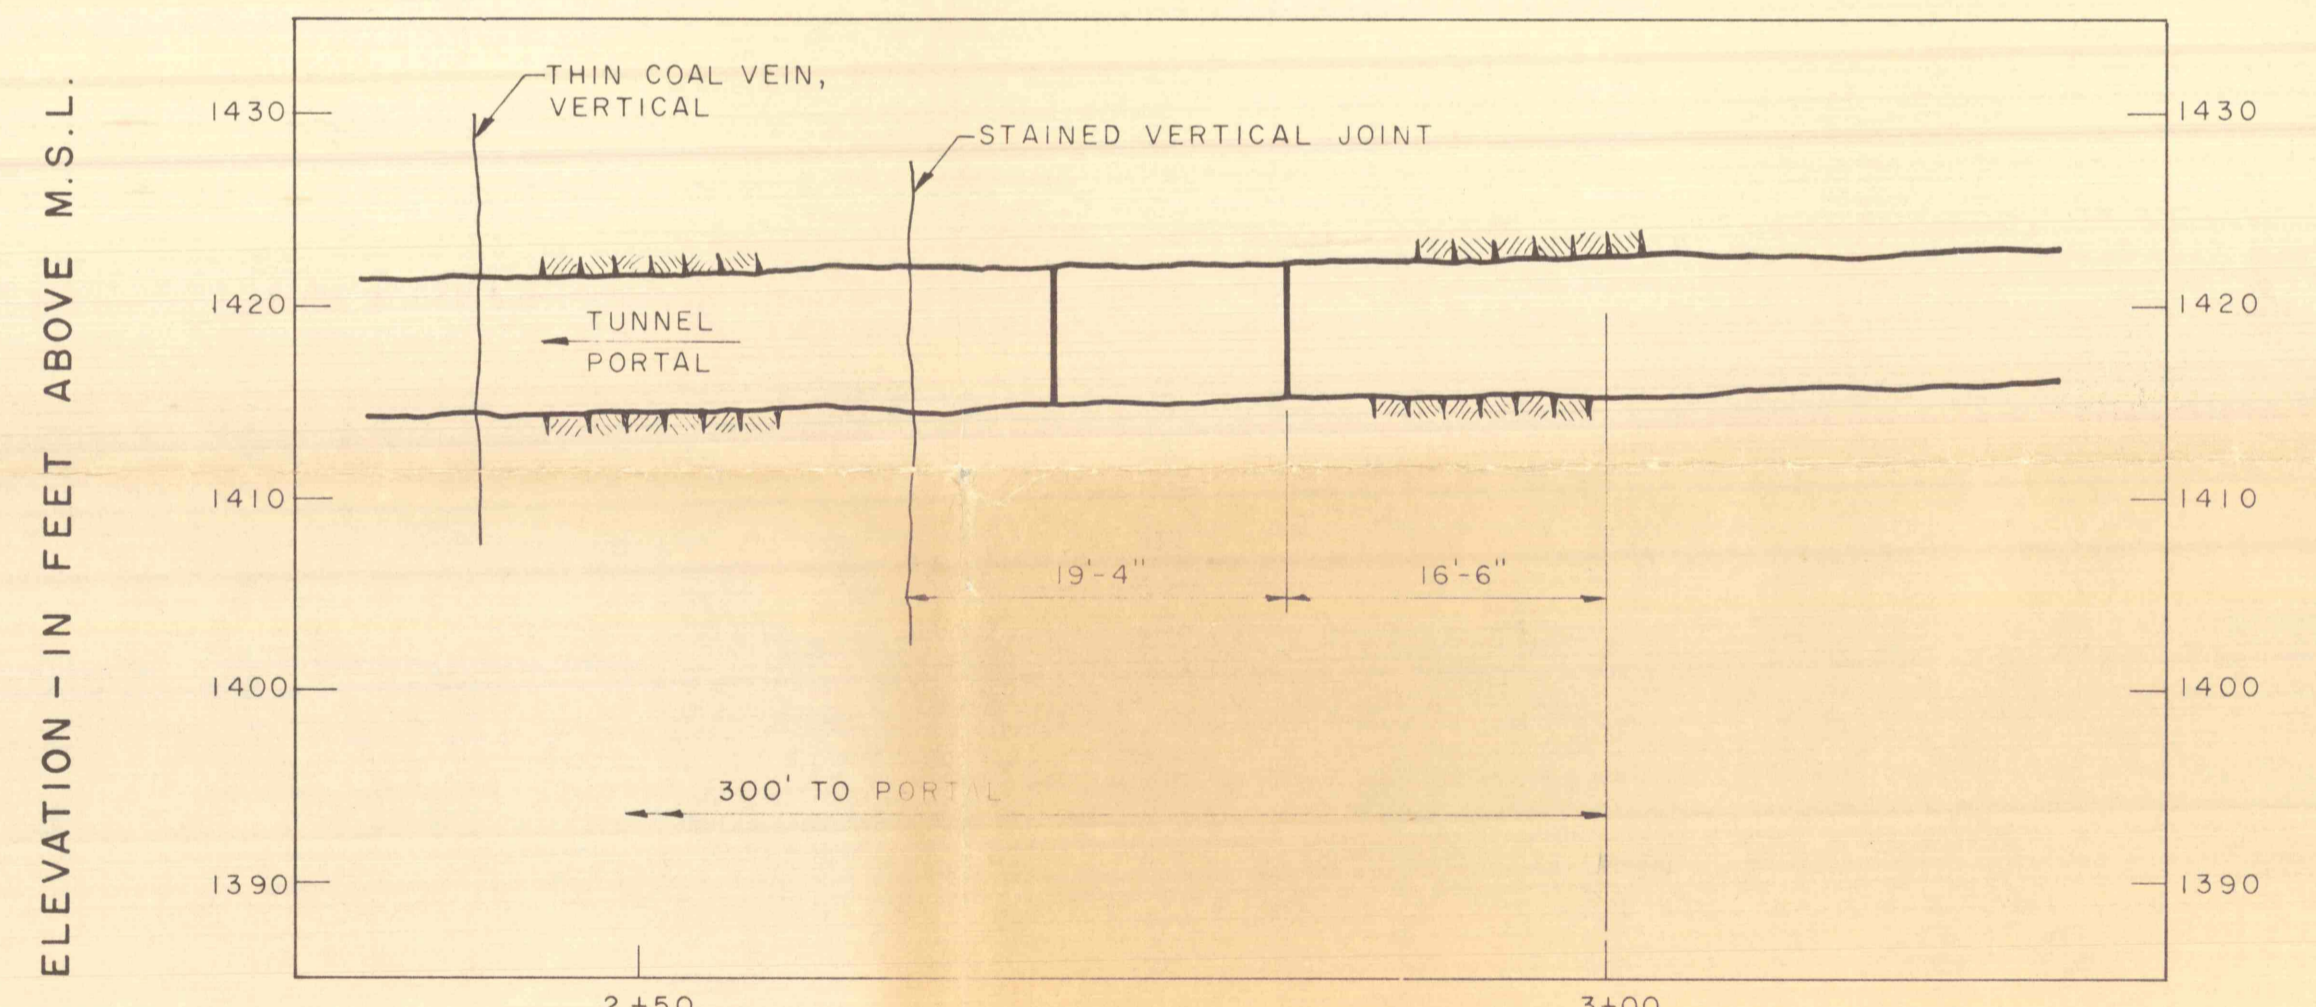


SECTION E-E
SCALE: 1"=10'

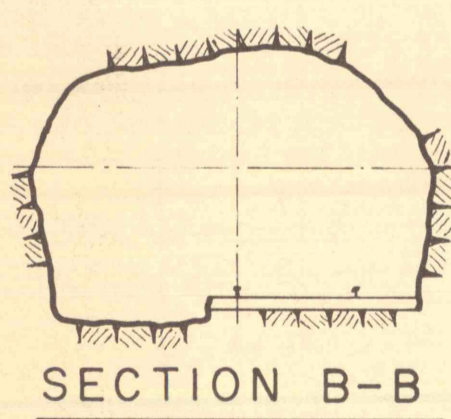

SECTION B-B

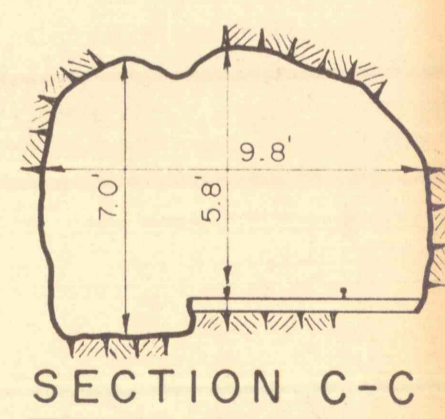


SECTION C-C

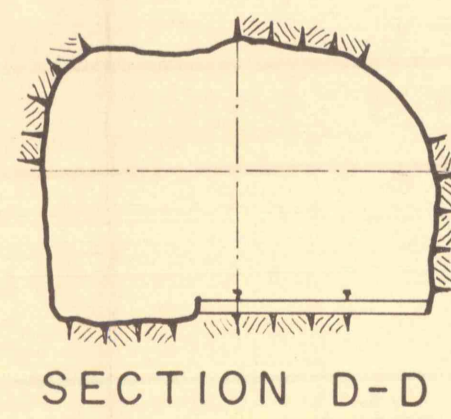


SECTION D-D


EXISTING DETAILS-TUNNEL NO. 2

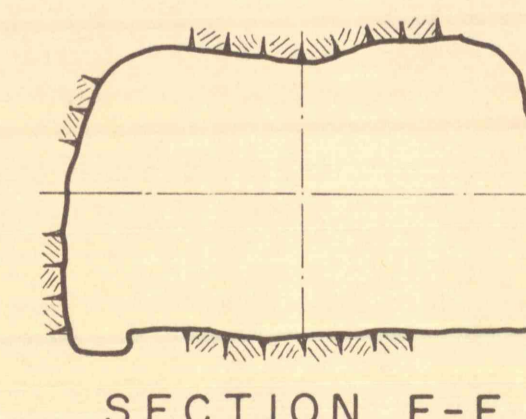

SECTION F-F

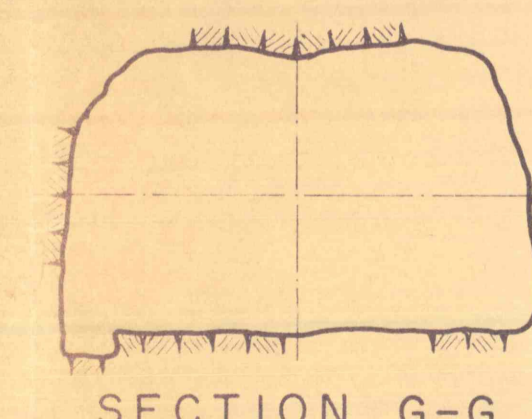

SECTION G-G

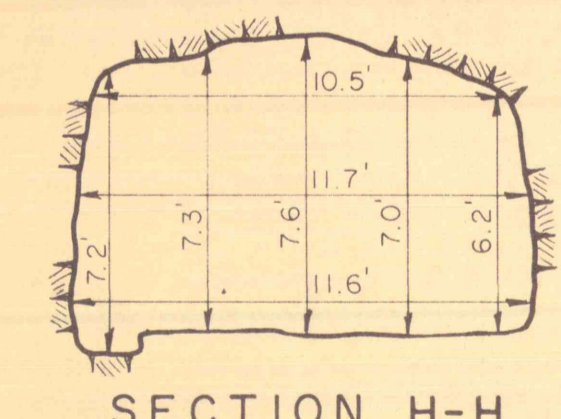

SECTION H-H

EXISTING DETAILS-TUNNEL NO. 3

REVISIONS			
NO.	DESCRIPTION	DATE	BY

DRAWN	GANNETT FLEMING CORDRY & CARPENTER, INC. ENGINEERS HARRISBURG, PENNSYLVANIA	JOB NO.	5081	COMMONWEALTH OF PENNSYLVANIA DEPARTMENT OF ENVIRONMENTAL RESOURCES CATAWISSA CREEK MINE DRAINAGE POLLUTION ABATEMENT PROJECT NO. SL-135	SHEET NO.	1
TRACED		SCALE	AS SHOWN		DRAWING NO.	
CHECKED		DATE				
APPROVED						
APPROVED						