



SECTION B-B
SCALE 1/4"=1'-0"
SEE PIPING LAYOUT PLAN C-4/C-5

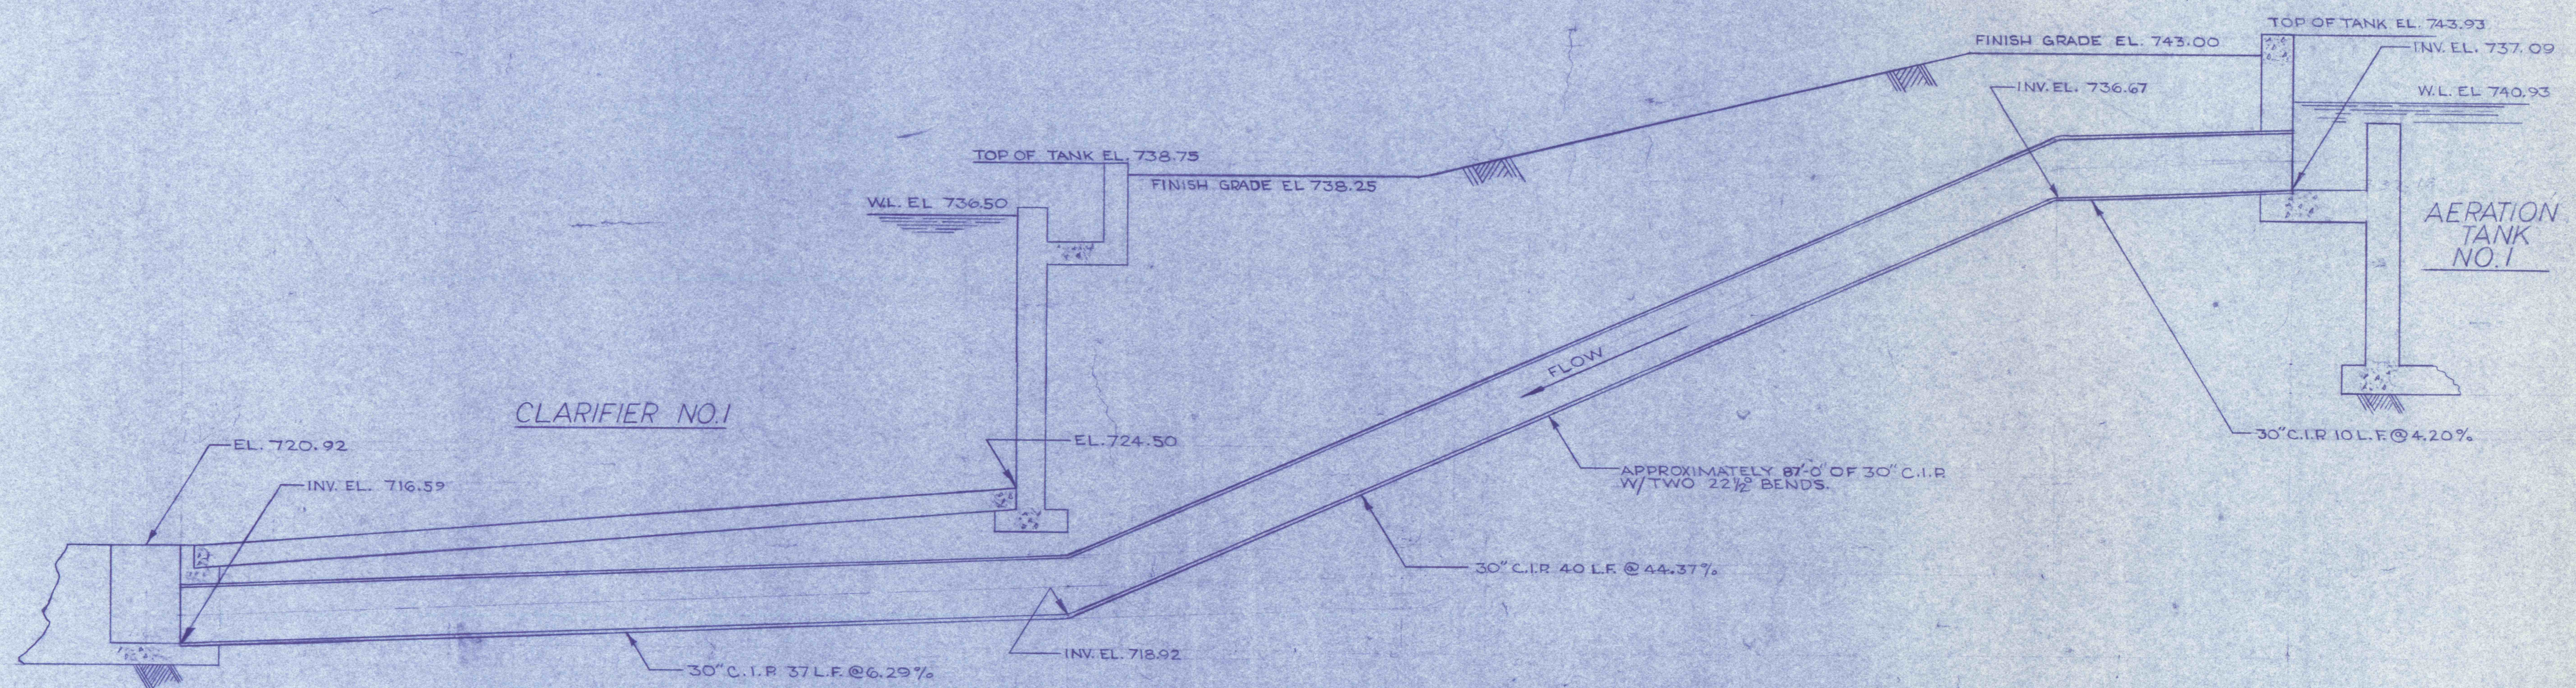

SECTION A-A
SCALE 1/4"=1'-0"
SEE PIPING LAYOUT PLAN C-4/C-5

PRE-FINAL

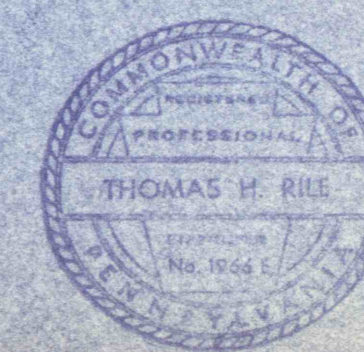

REVISIONS	
PIPING LAYOUT PLAN III	
CONSTRUCTION OF TREATMENT FACILITIES FOR ACID MINE DRAINAGE RAUSCH CREEK WATERSHED SCHUYLKILL COUNTY, PENNSYLVANIA	
JOB NO. 8808 DATE: NOV. 1992 SCALE: AS NOTED DRAWN: J. MILTON APPROVED: THE JLL	DRAWING NO. C-6
ANTHRACITE RESEARCH & DEVELOPMENT CO. INC. consulting engineers POTTSVILLE TAMAGUA PENNSYLVANIA	