



DECK PLAN
SCALE: 1/4" = 1'-0"


SEE PLUMBING FLOOR PLAN THIS SHEET FOR DRAIN LINE & BODILY DEF. LOCATIONS

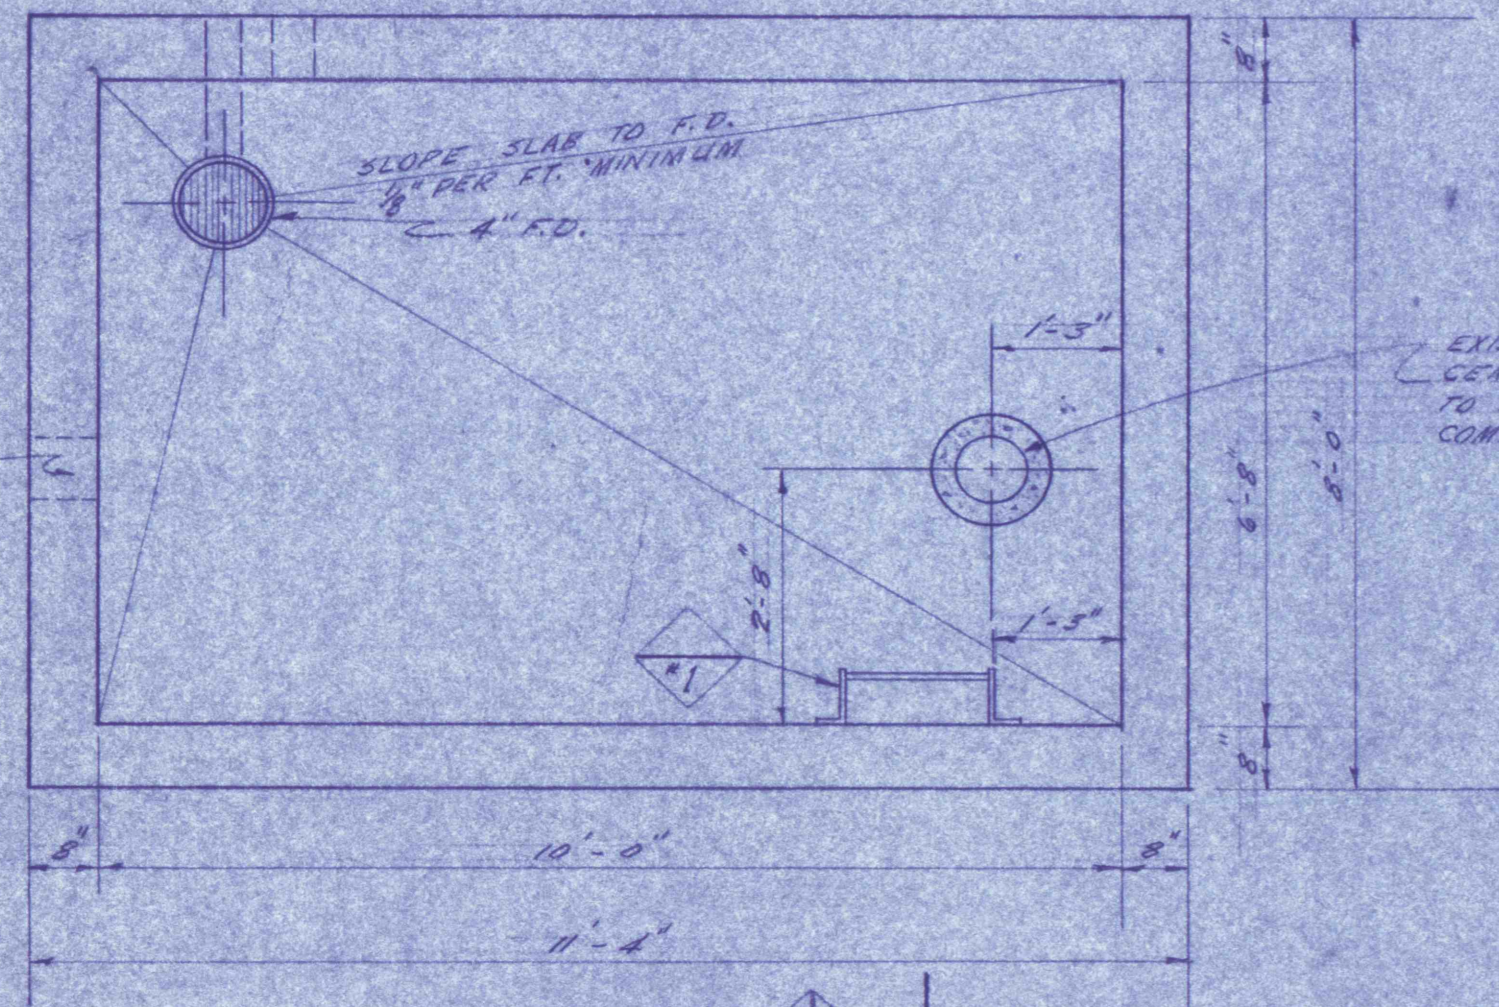


FLOOR PLAN
SCALE: 1/4" = 1'-0"

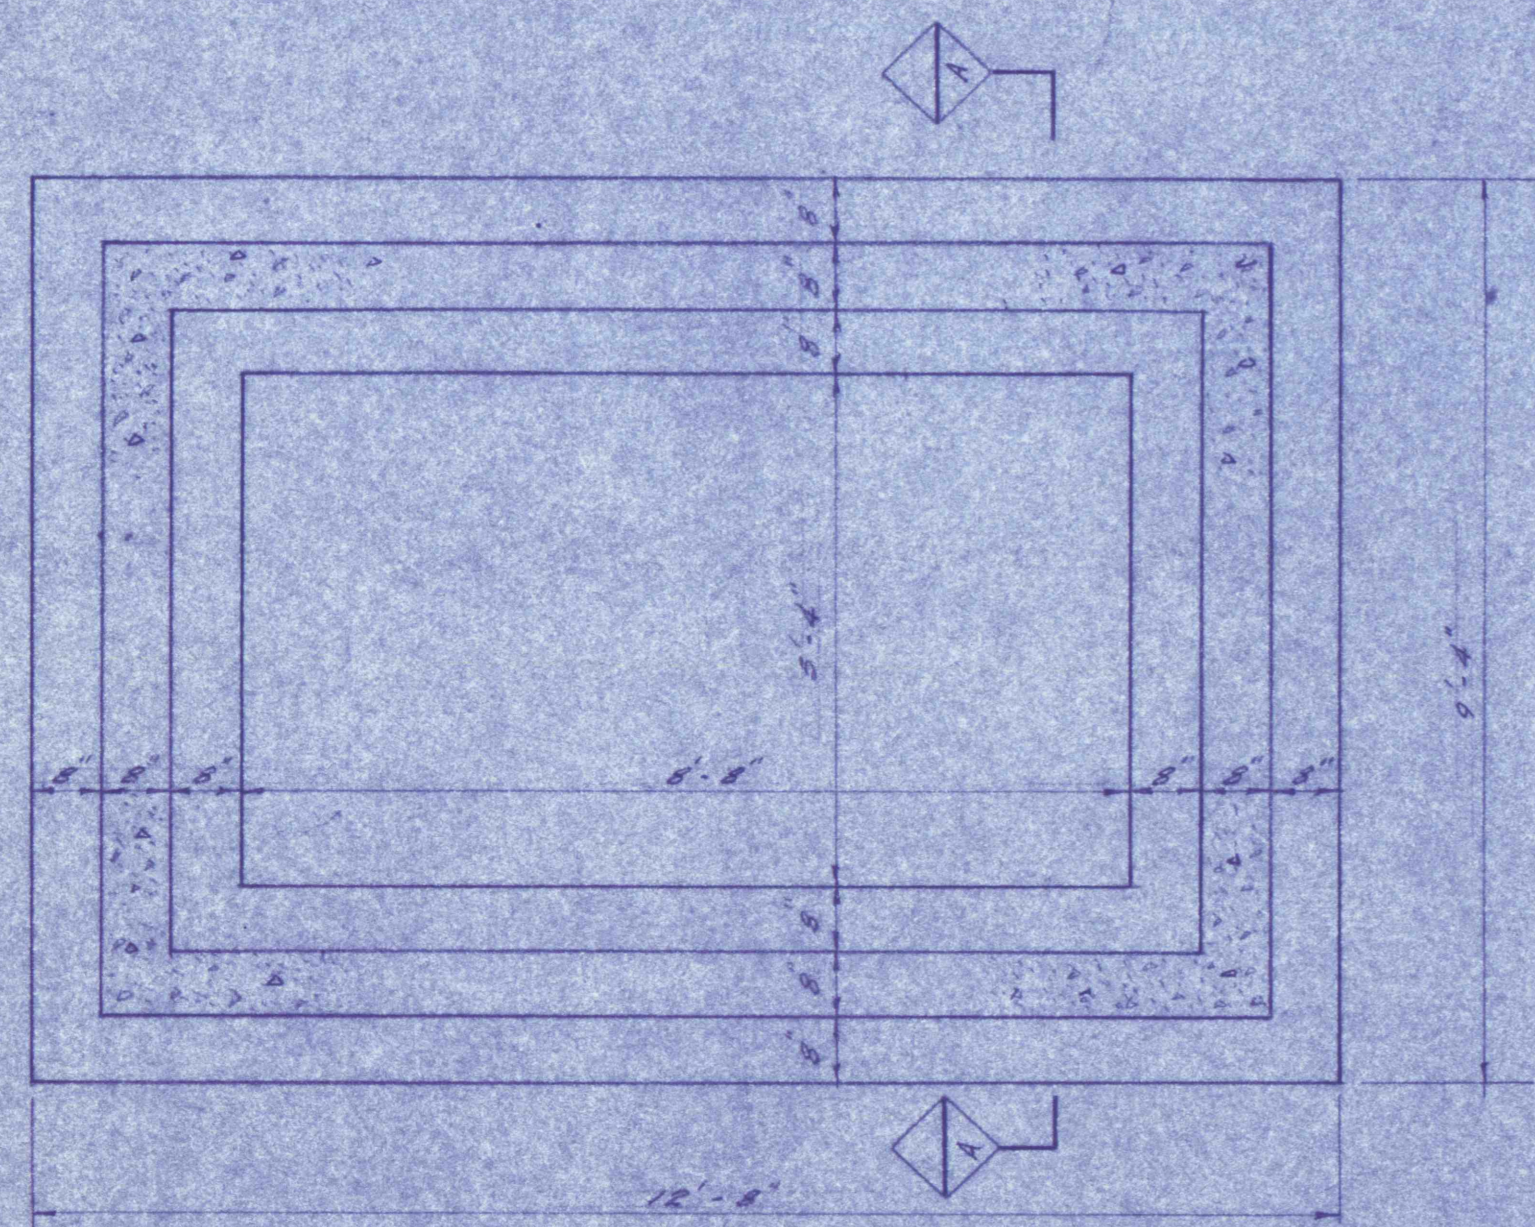


FOUNDATION PLAN
SCALE: 1/4" = 1'-0"

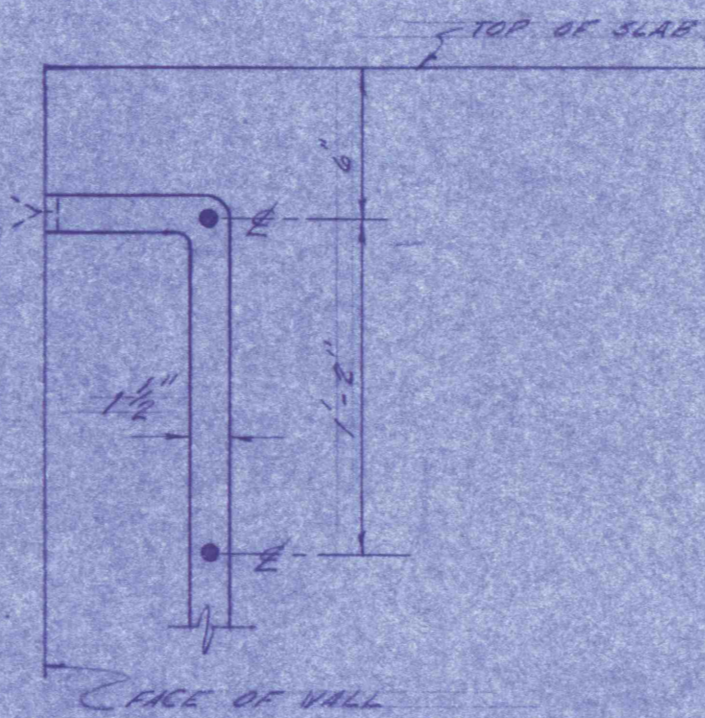


SECTION B-B
SCALE: 1/2" = 1'-0"

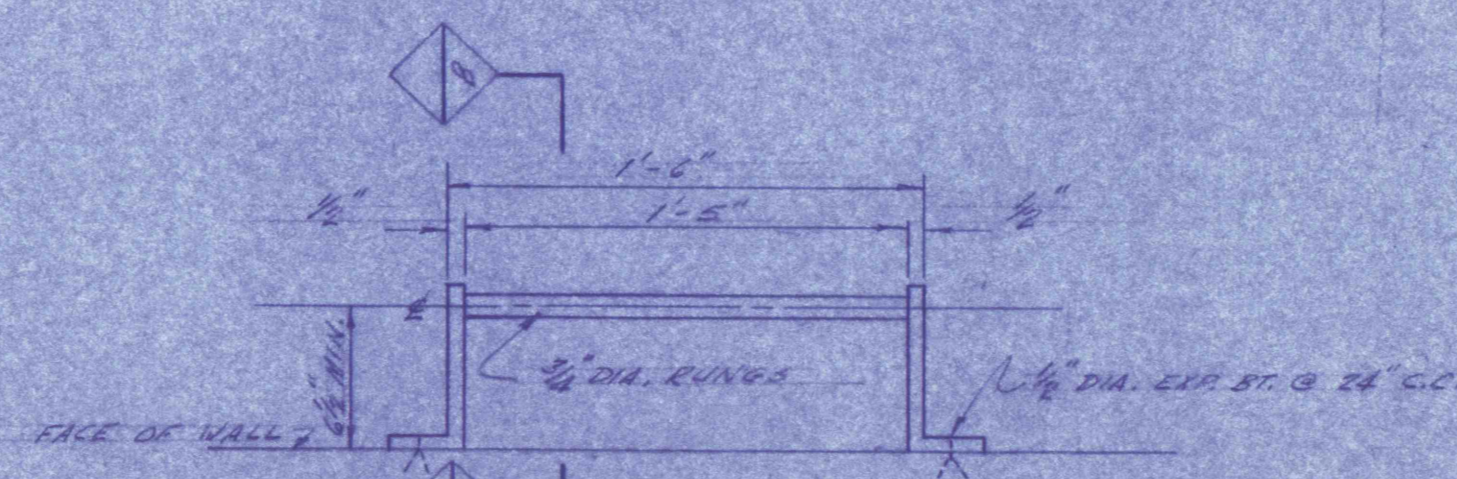


SHIP'S LADDER PLAN
SCALE: 1/2" = 1'-0"

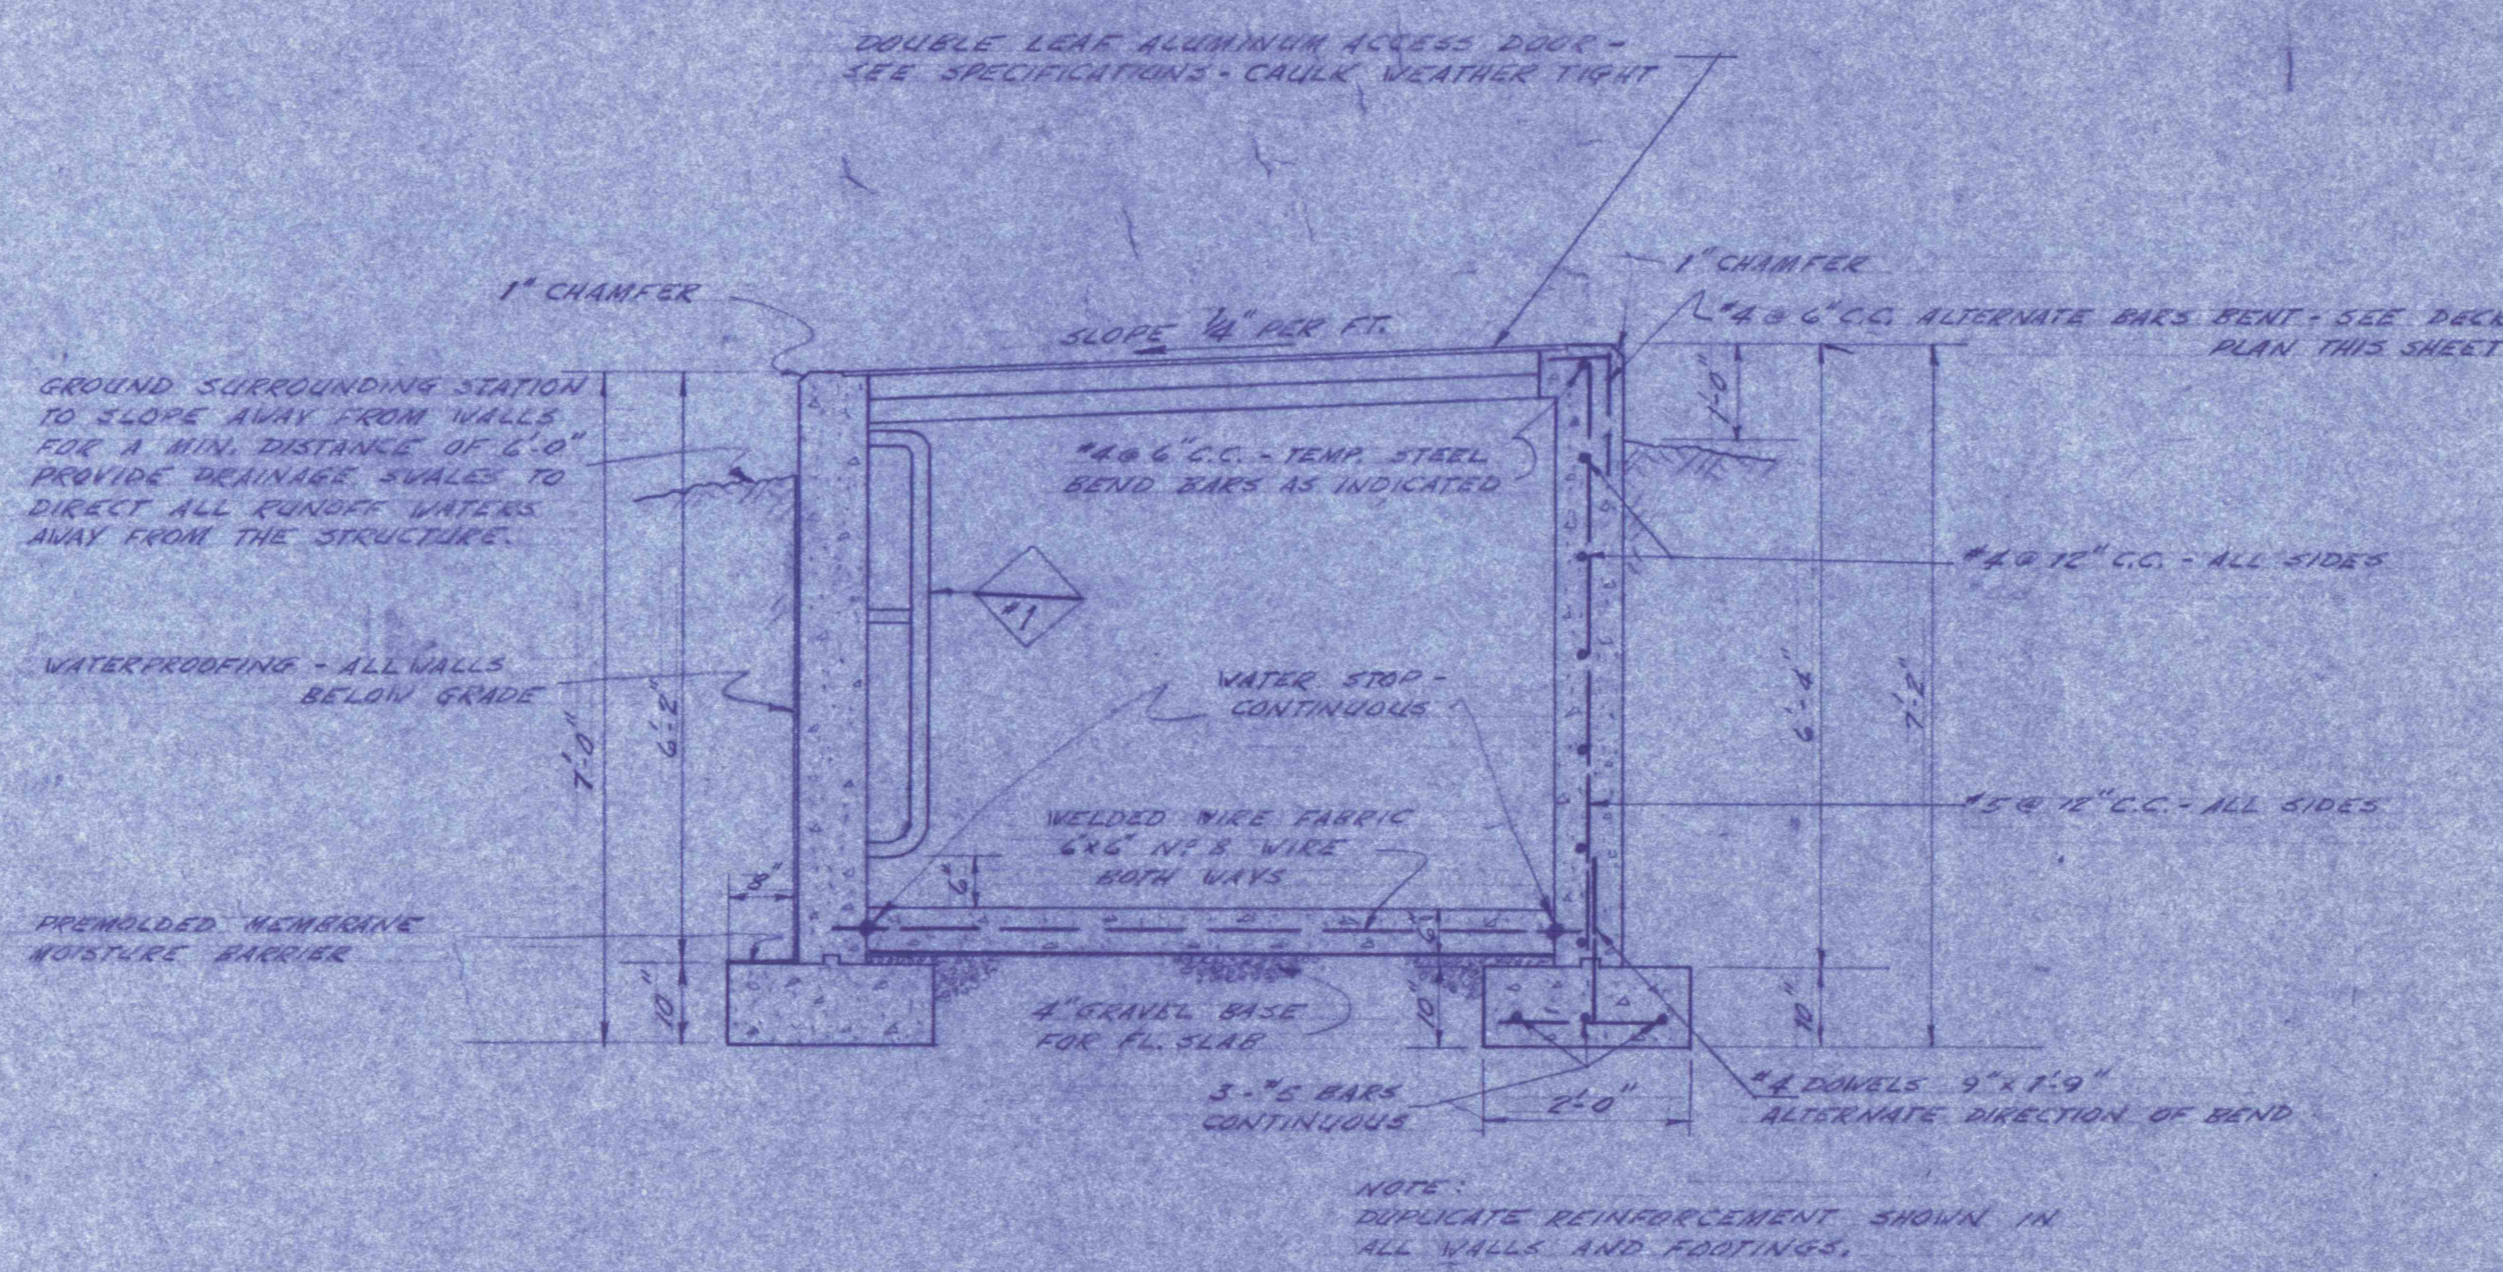


SECTION A-A
SCALE: 1/2" = 1'-0"

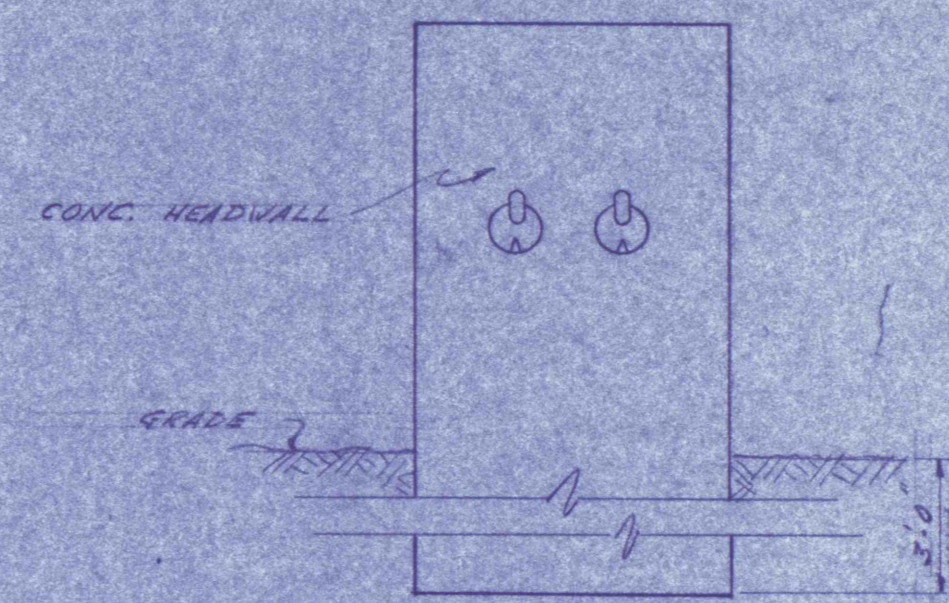


FRONT ELEV.
SCALE: 1/2" = 1'-0"

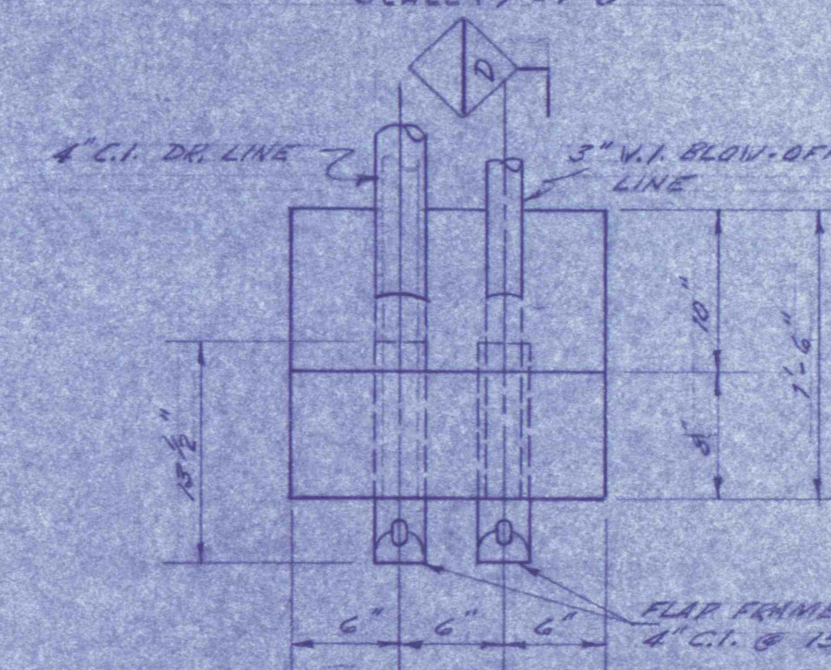


PLAN
SCALE: 1'-1" = 0"

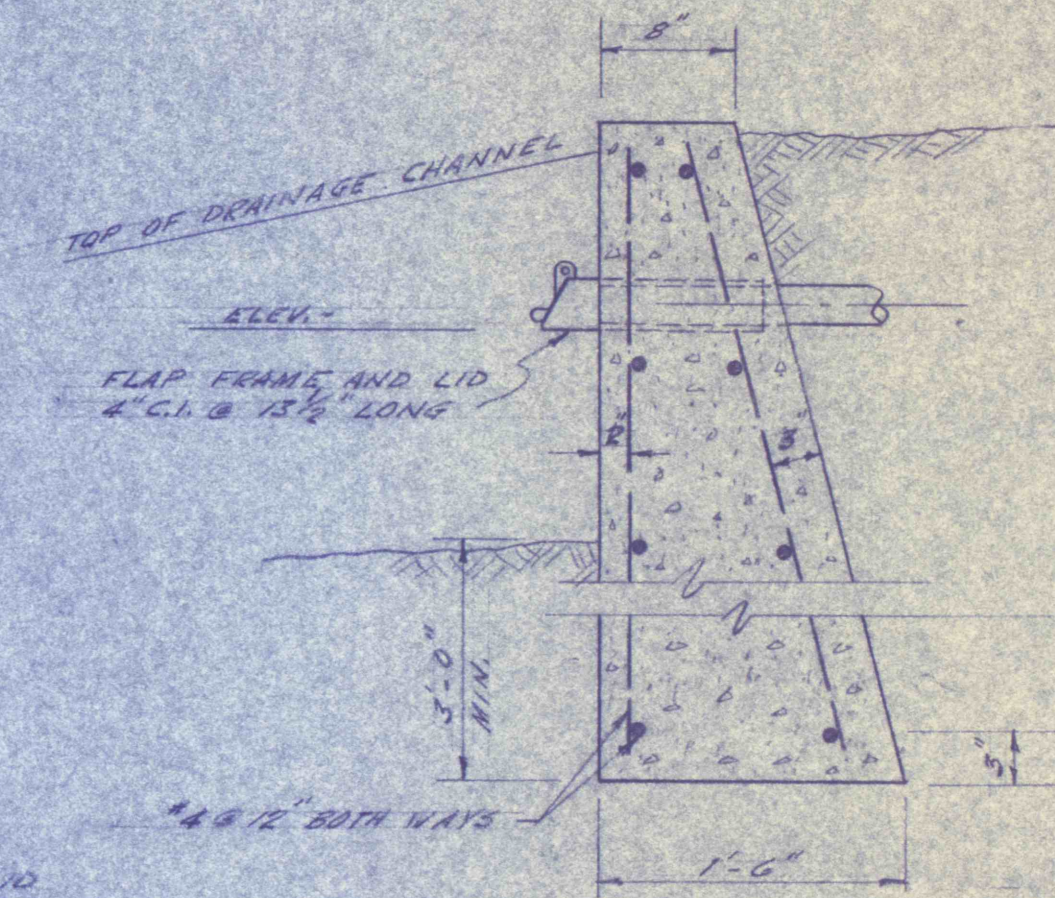

SECTION D-D
SCALE: 1" = 1'-0"

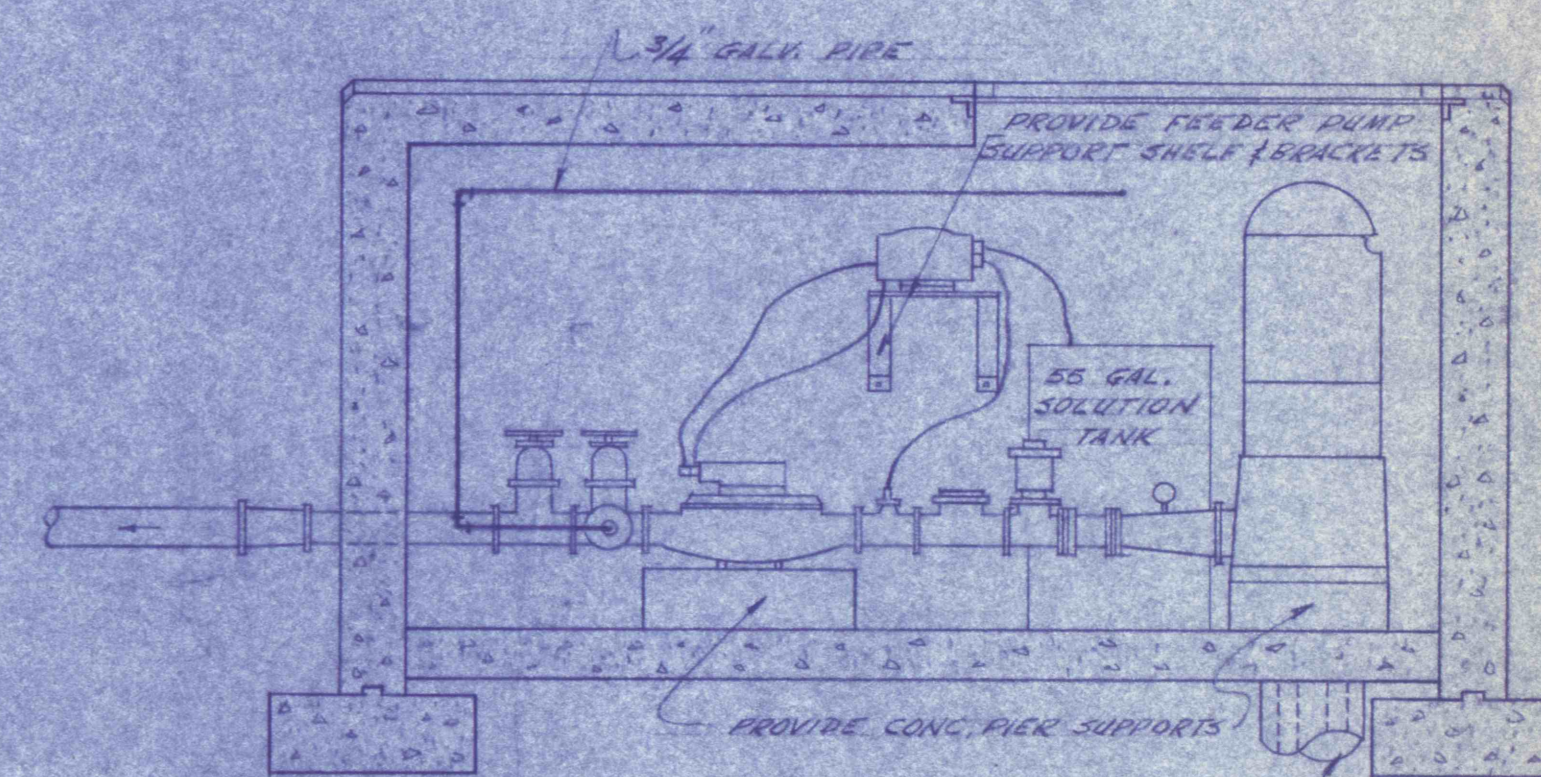

SECTION C-C
SCALE: 1/2" = 1'-0"

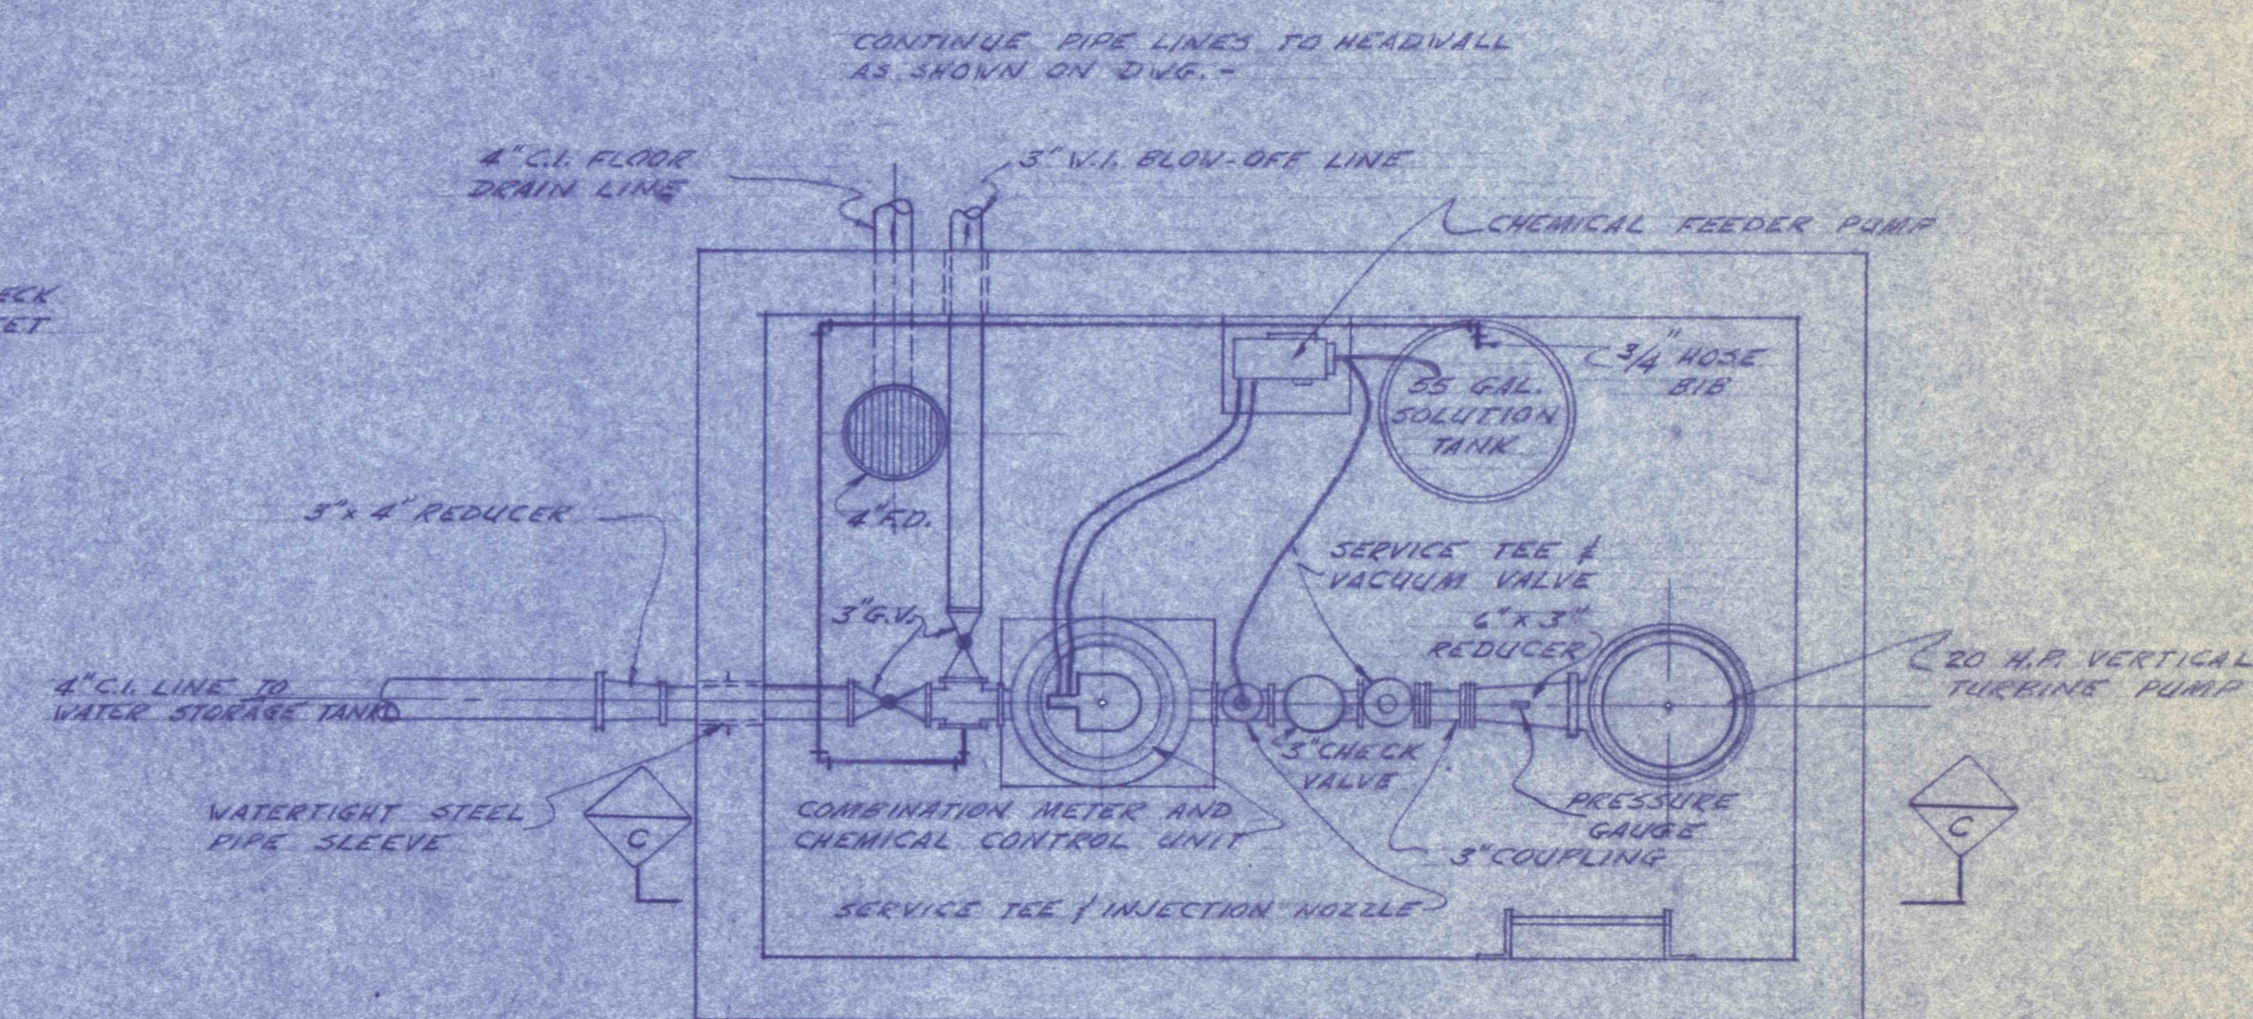

PLAN
SCALE: 1/2" = 1'-0"

PRE-FINAL

REVISIONS			
WELL PUMPING STATION			
CONSTRUCTION OF TREATMENT FACILITIES FOR ACID MINE DRAINAGE			
RAUSCH CREEK WATERSHED			
SCHUYLKILL COUNTY PENNSYLVANIA			
ANTHRACITE RESEARCH & DEVELOPMENT CO. INC. consulting engineers		TAMAGUA	
POTTSVILLE		PENNSYLVANIA	
JOB NO. 6495	DATE: 10-30-69	SCALE: AS NOTED	DRAWN: J.M.B.
APPROVED: [Signature]		DRAWING NO. C-35	

