




**ROOF PLAN**  
SCALE: 1/8" = 1'-0"

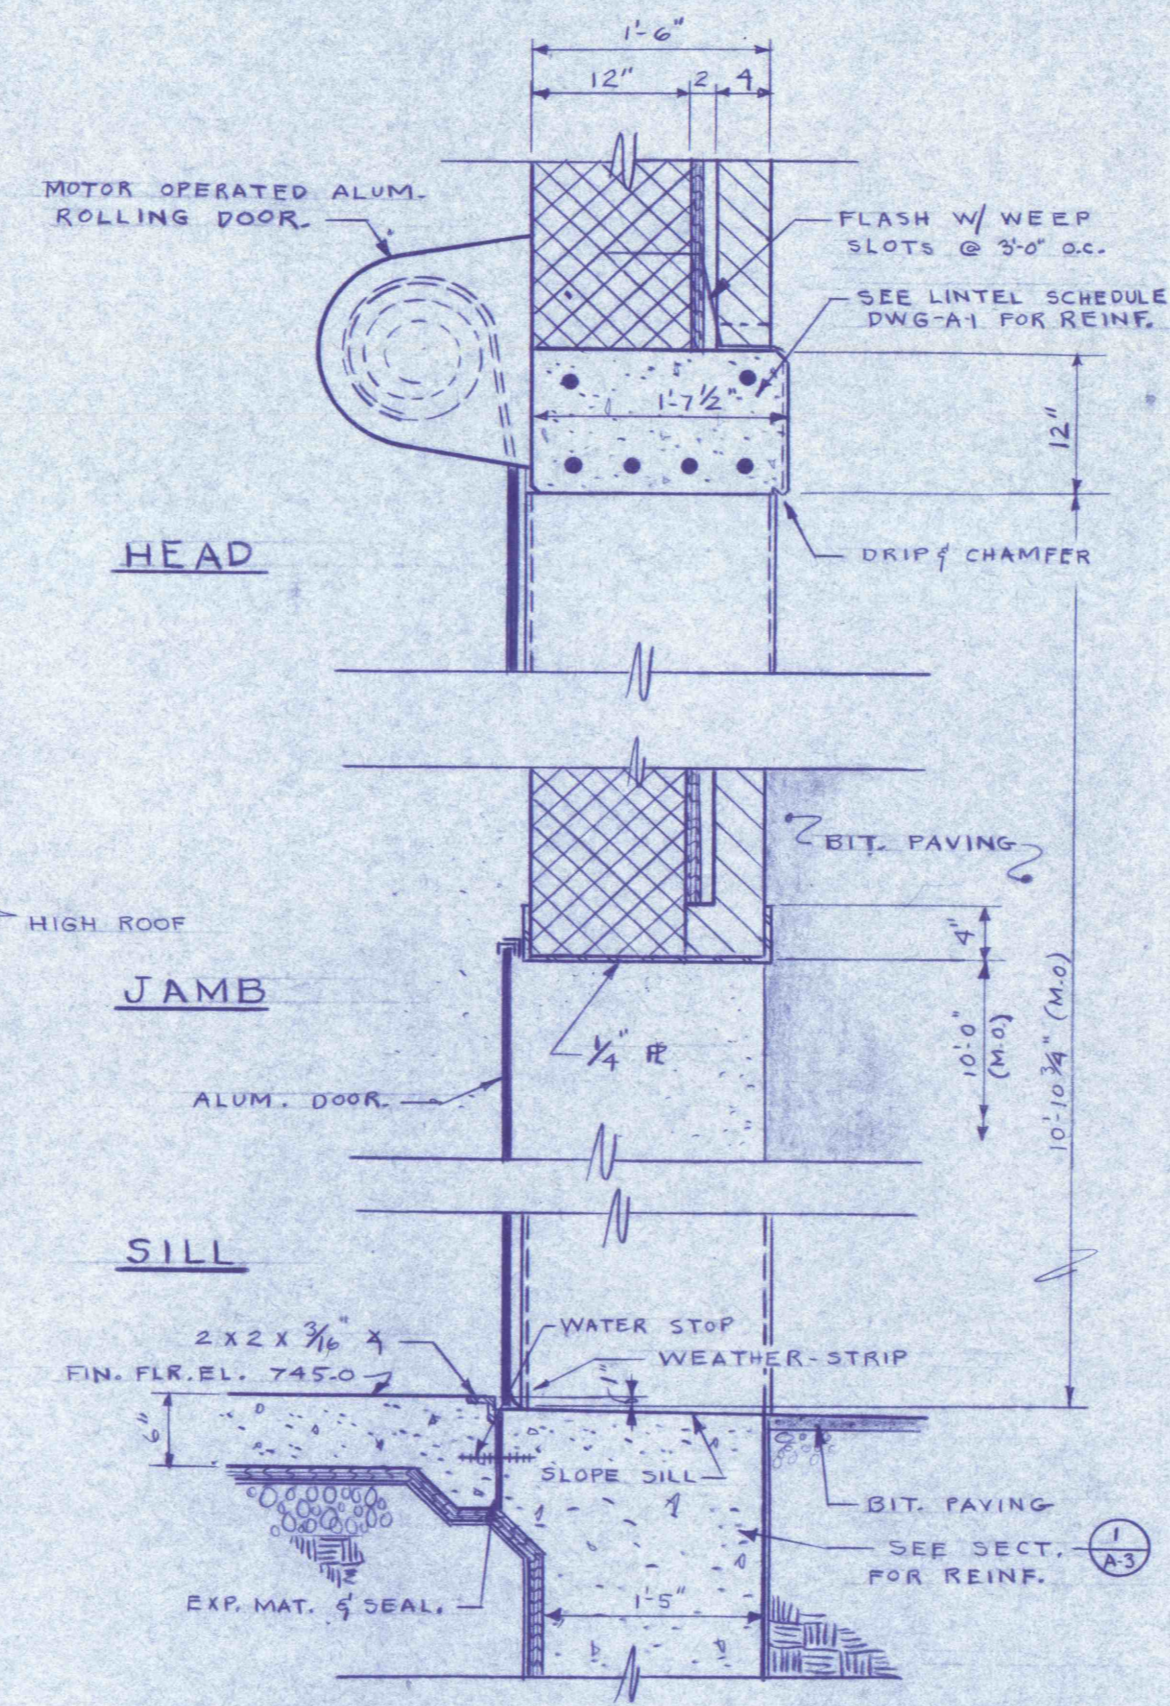


**SECTION**  
SCALE: 1/8" = 1'-0"

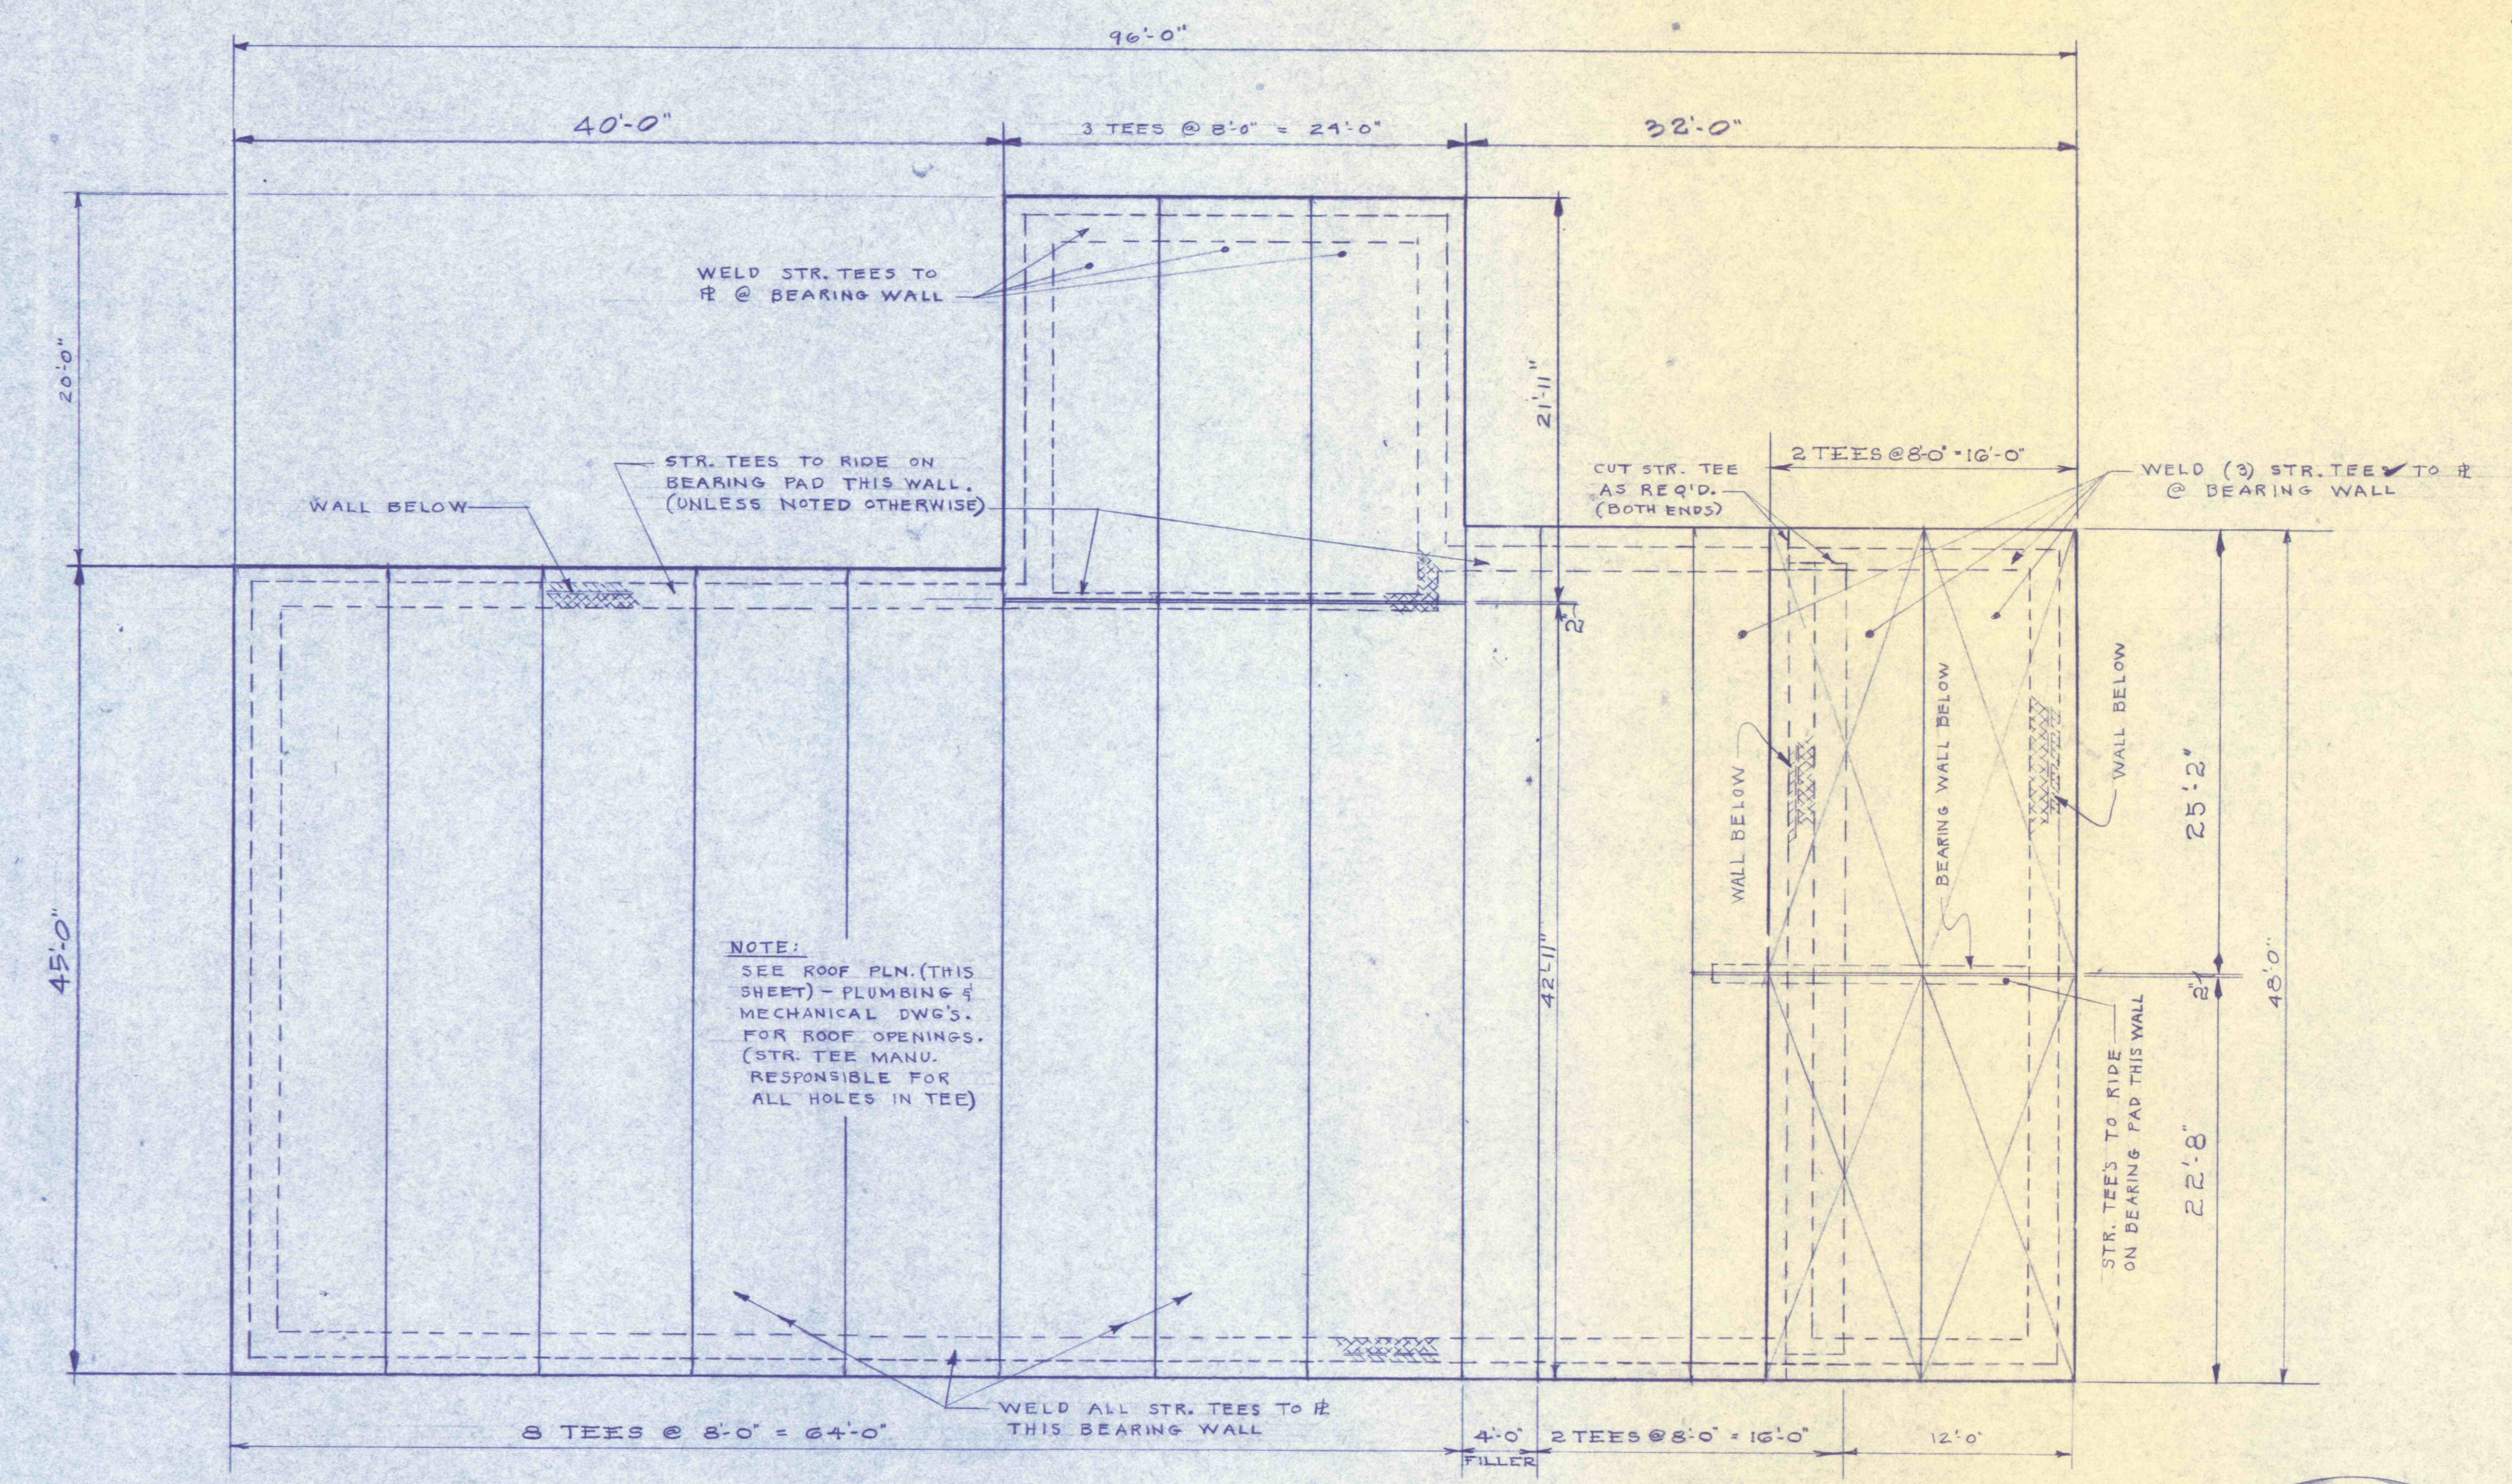


**ROOF FRAMING PLAN**  
SCALE: 1/8" = 1'-0"

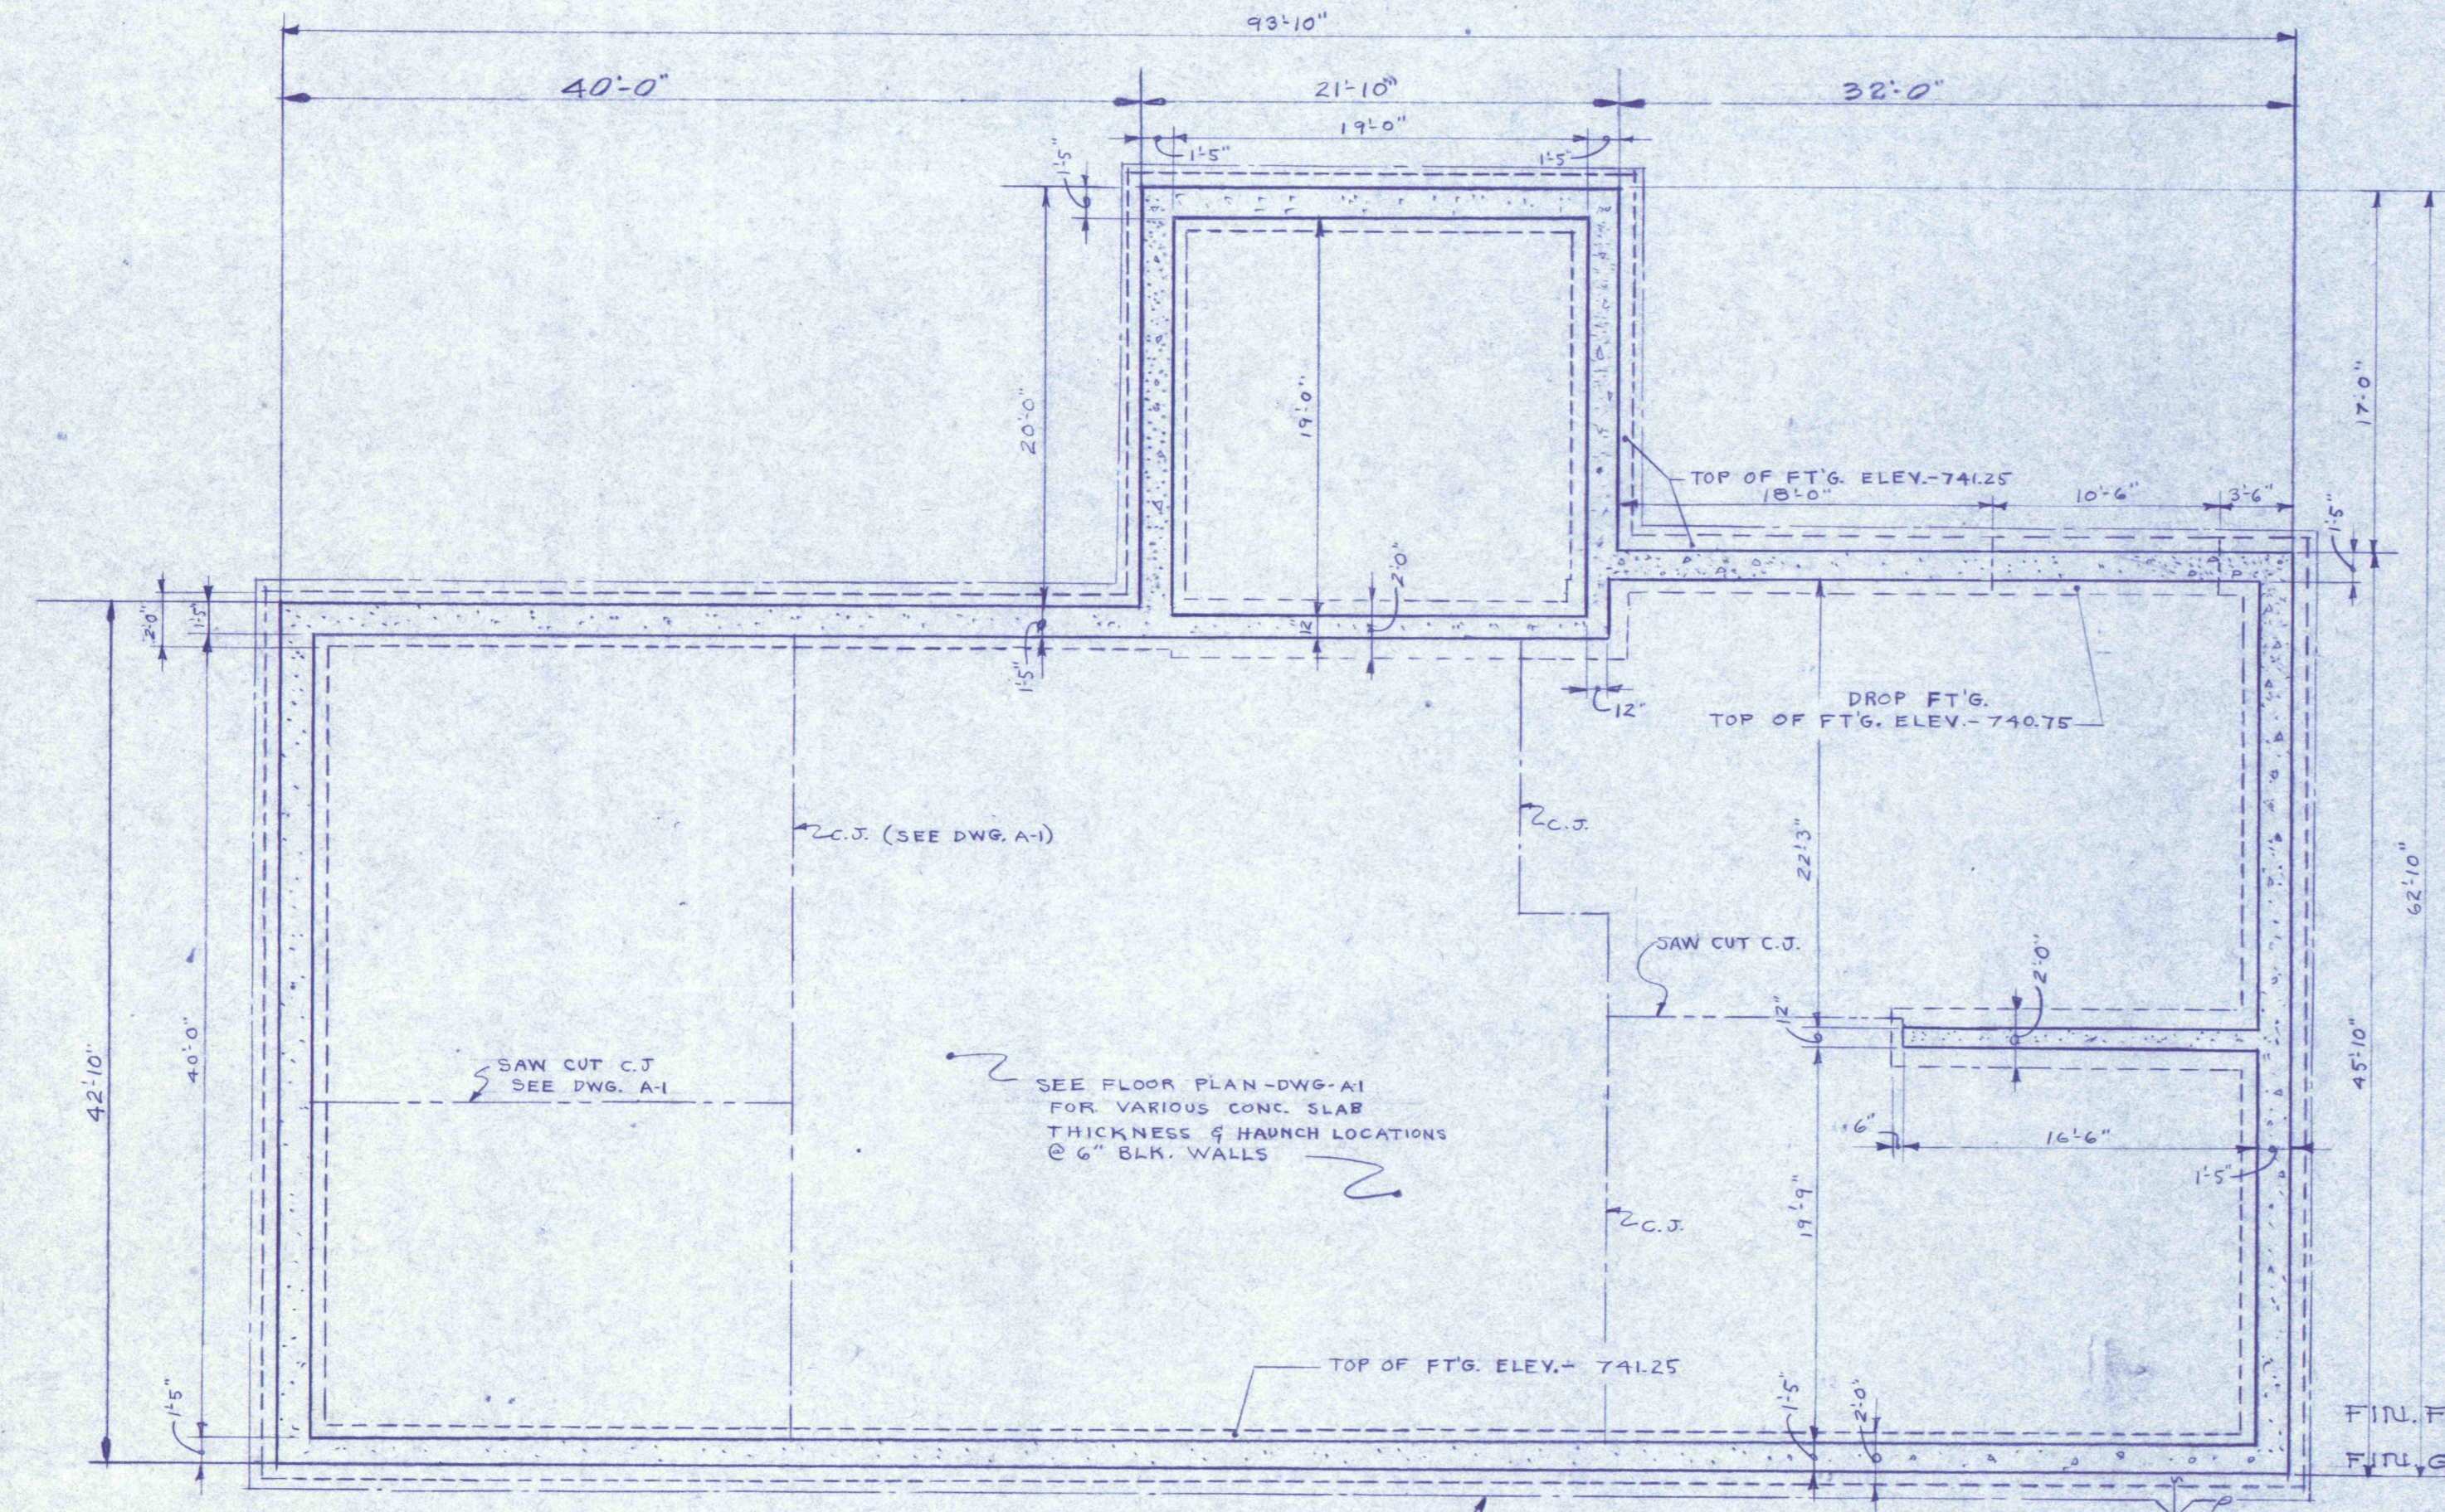


**FOUNDATION PLAN**  
SCALE: 1/8" = 1'-0"

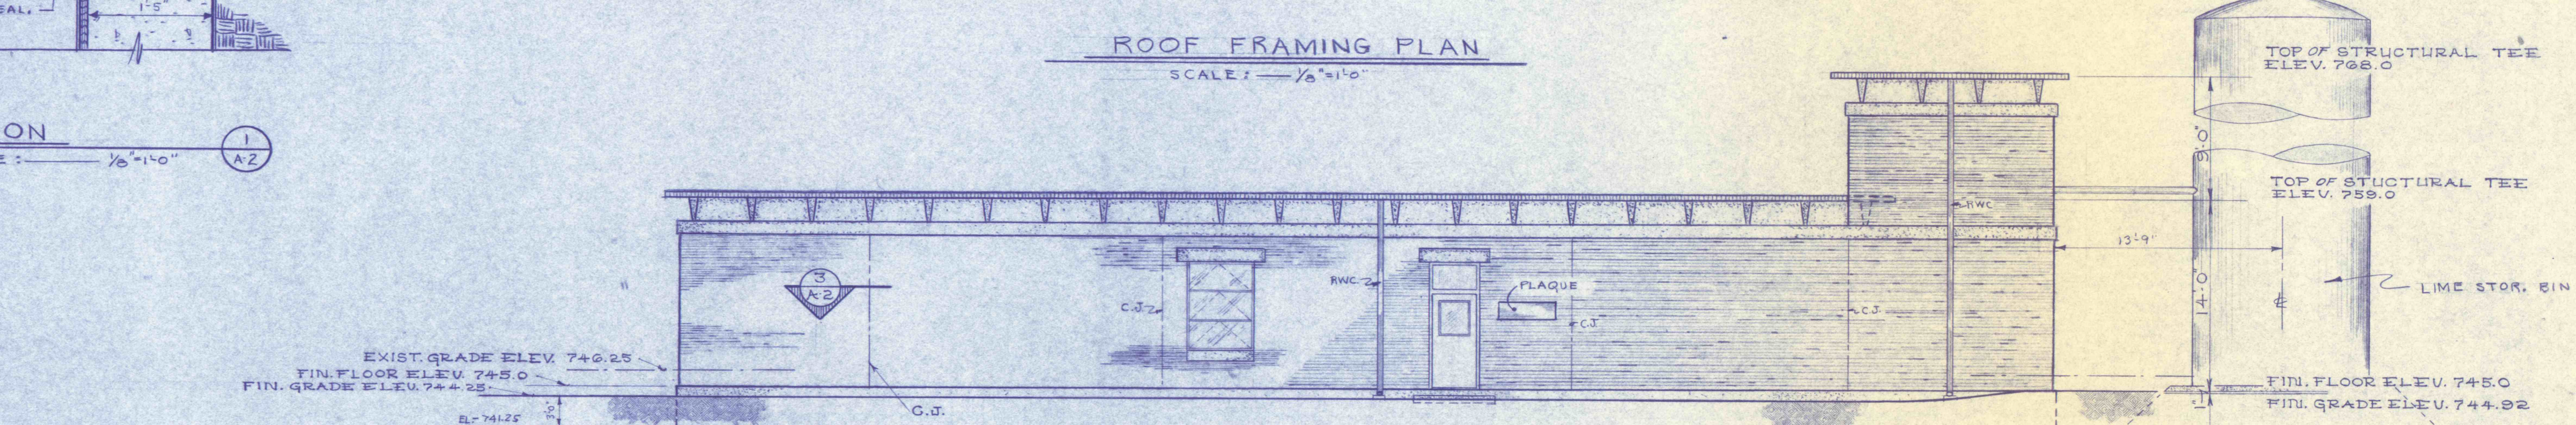

**WEST ELEVATION**  
SCALE: 1/8" = 1'-0"

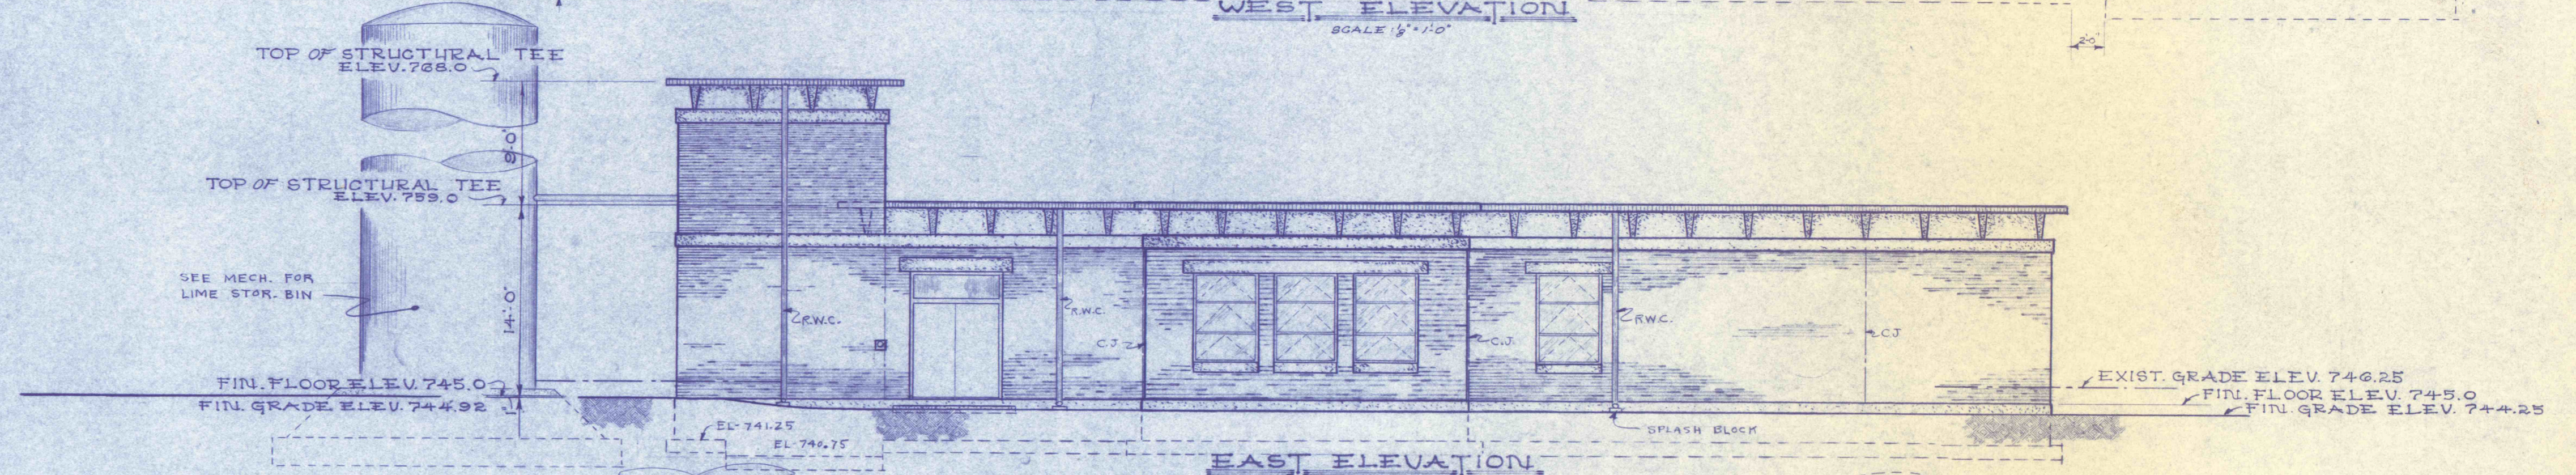


**EAST ELEVATION**  
SCALE: 1/8" = 1'-0"

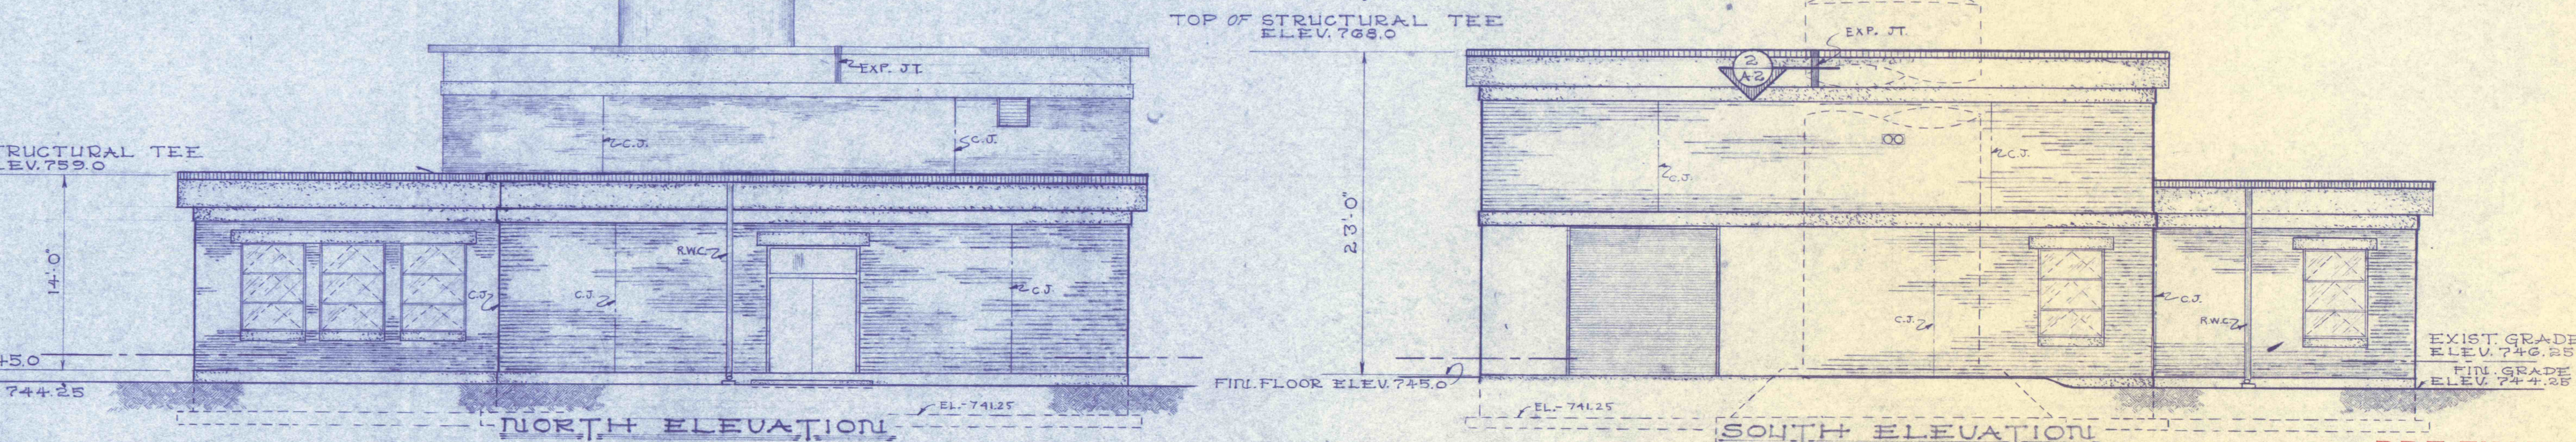

**NORTH ELEVATION**  
SCALE: 1/8" = 1'-0"

**SOUTH ELEVATION**  
SCALE: 1/8" = 1'-0"

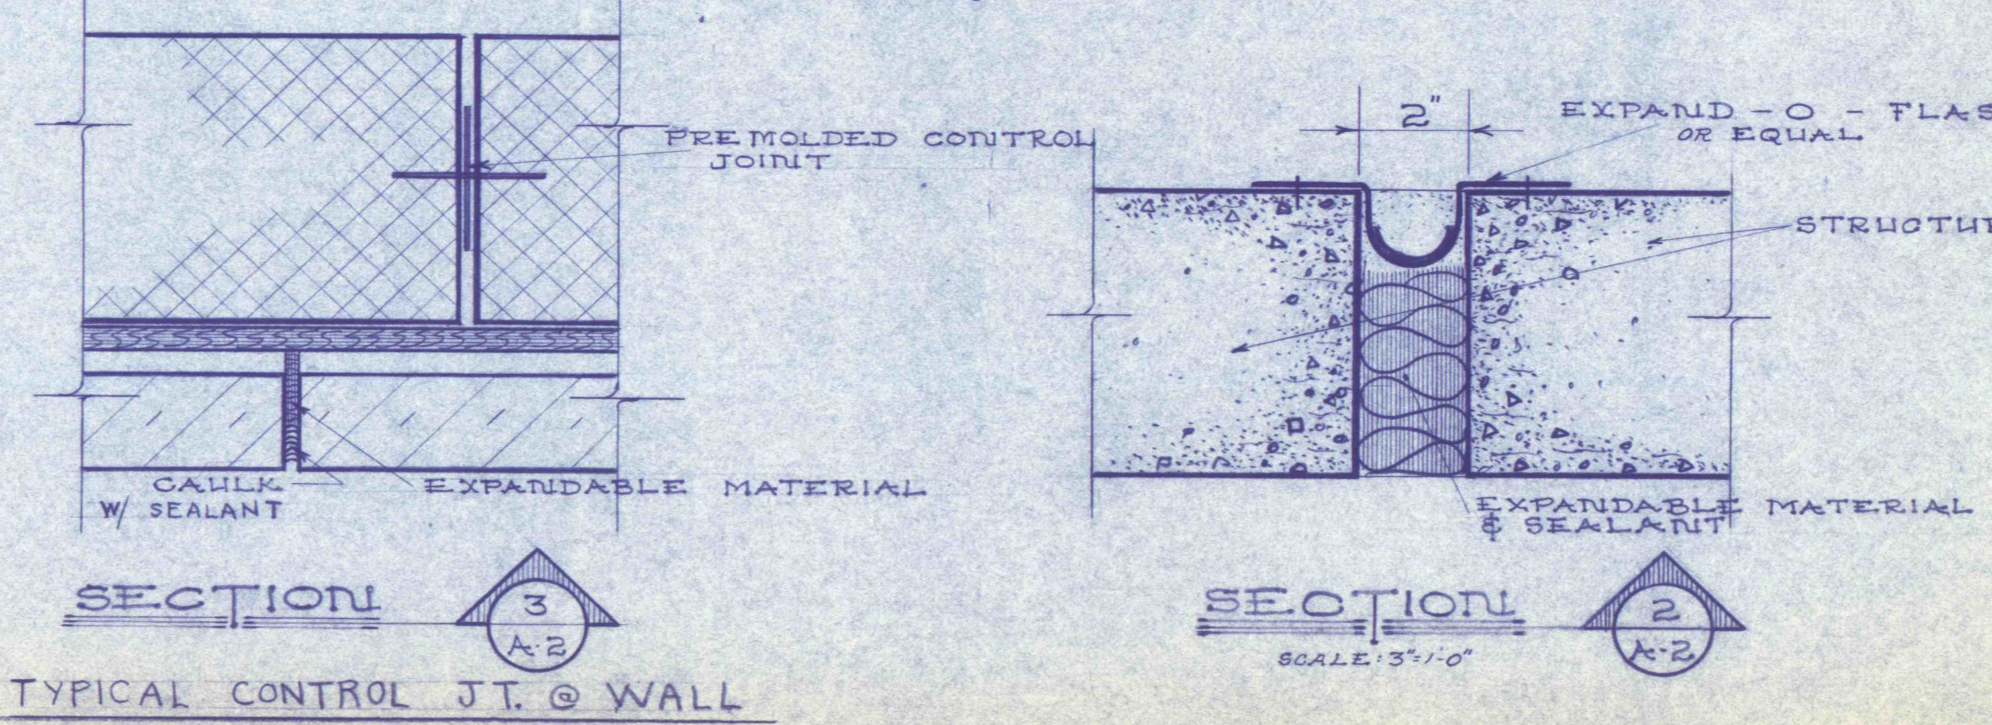

**SECTION**  
TYPICAL CONTROL JT. @ WALL

**SECTION**  
SCALE: 1/8" = 1'-0"



REVISIONS	

**PLANS - ELEVATIONS & DETAILS**

CONSTRUCTION OF TREATMENT FACILITIES FOR ACID MINE DRAINAGE  
**RAUSCH CREEK WATERSHED**  
 SCHUYLKILL COUNTY PENNSYLVANIA

ANTHRACITE RESEARCH & DEVELOPMENT CO. INC.  
 consulting engineers TAMAGUA

JOB NO: 6805  
 DATE: 10/11/64  
 SCALE: 1/8" = 1'-0"  
 DRAWN: DUEFF W.R.  
 APPROVED: T.H.R., J.L.L.

DRAWING NO:  
**A-2**

PRE-FINAL