


ELECTRICAL SYMBOLS

- FLUORESCENT LIGHTING FIXTURE
- WALL MTD INCANDESCENT LIGHTING FIXTURE
- CEILING MTD INCANDESCENT LIGHTING FIXTURE
- S SINGLE POLE SWITCH
- S₃ THREE WAY SWITCH
- ⊖ THERMOSTAT
- ⊕ JUNCTION BOX
- ⊖ DUPLEX RECEPTACLE 15A-125V-1ϕ-W/GND
- ⊖ SINGLE RECEPTACLE 15A-125V-1ϕ-W/GND
- ⊖ CLOCK OUTLET
- ☎ TELEPHONE OUTLET
- ⊗ CONTACTOR
- ⊗ COMBINATION CONTACTOR & DISCONNECT SWITCH
- ⊗ MOTOR HP AS NOTED
- ▭ ELECTRIC DUCT HEATER
- ▭ DRY TYPE TRANSFORMER

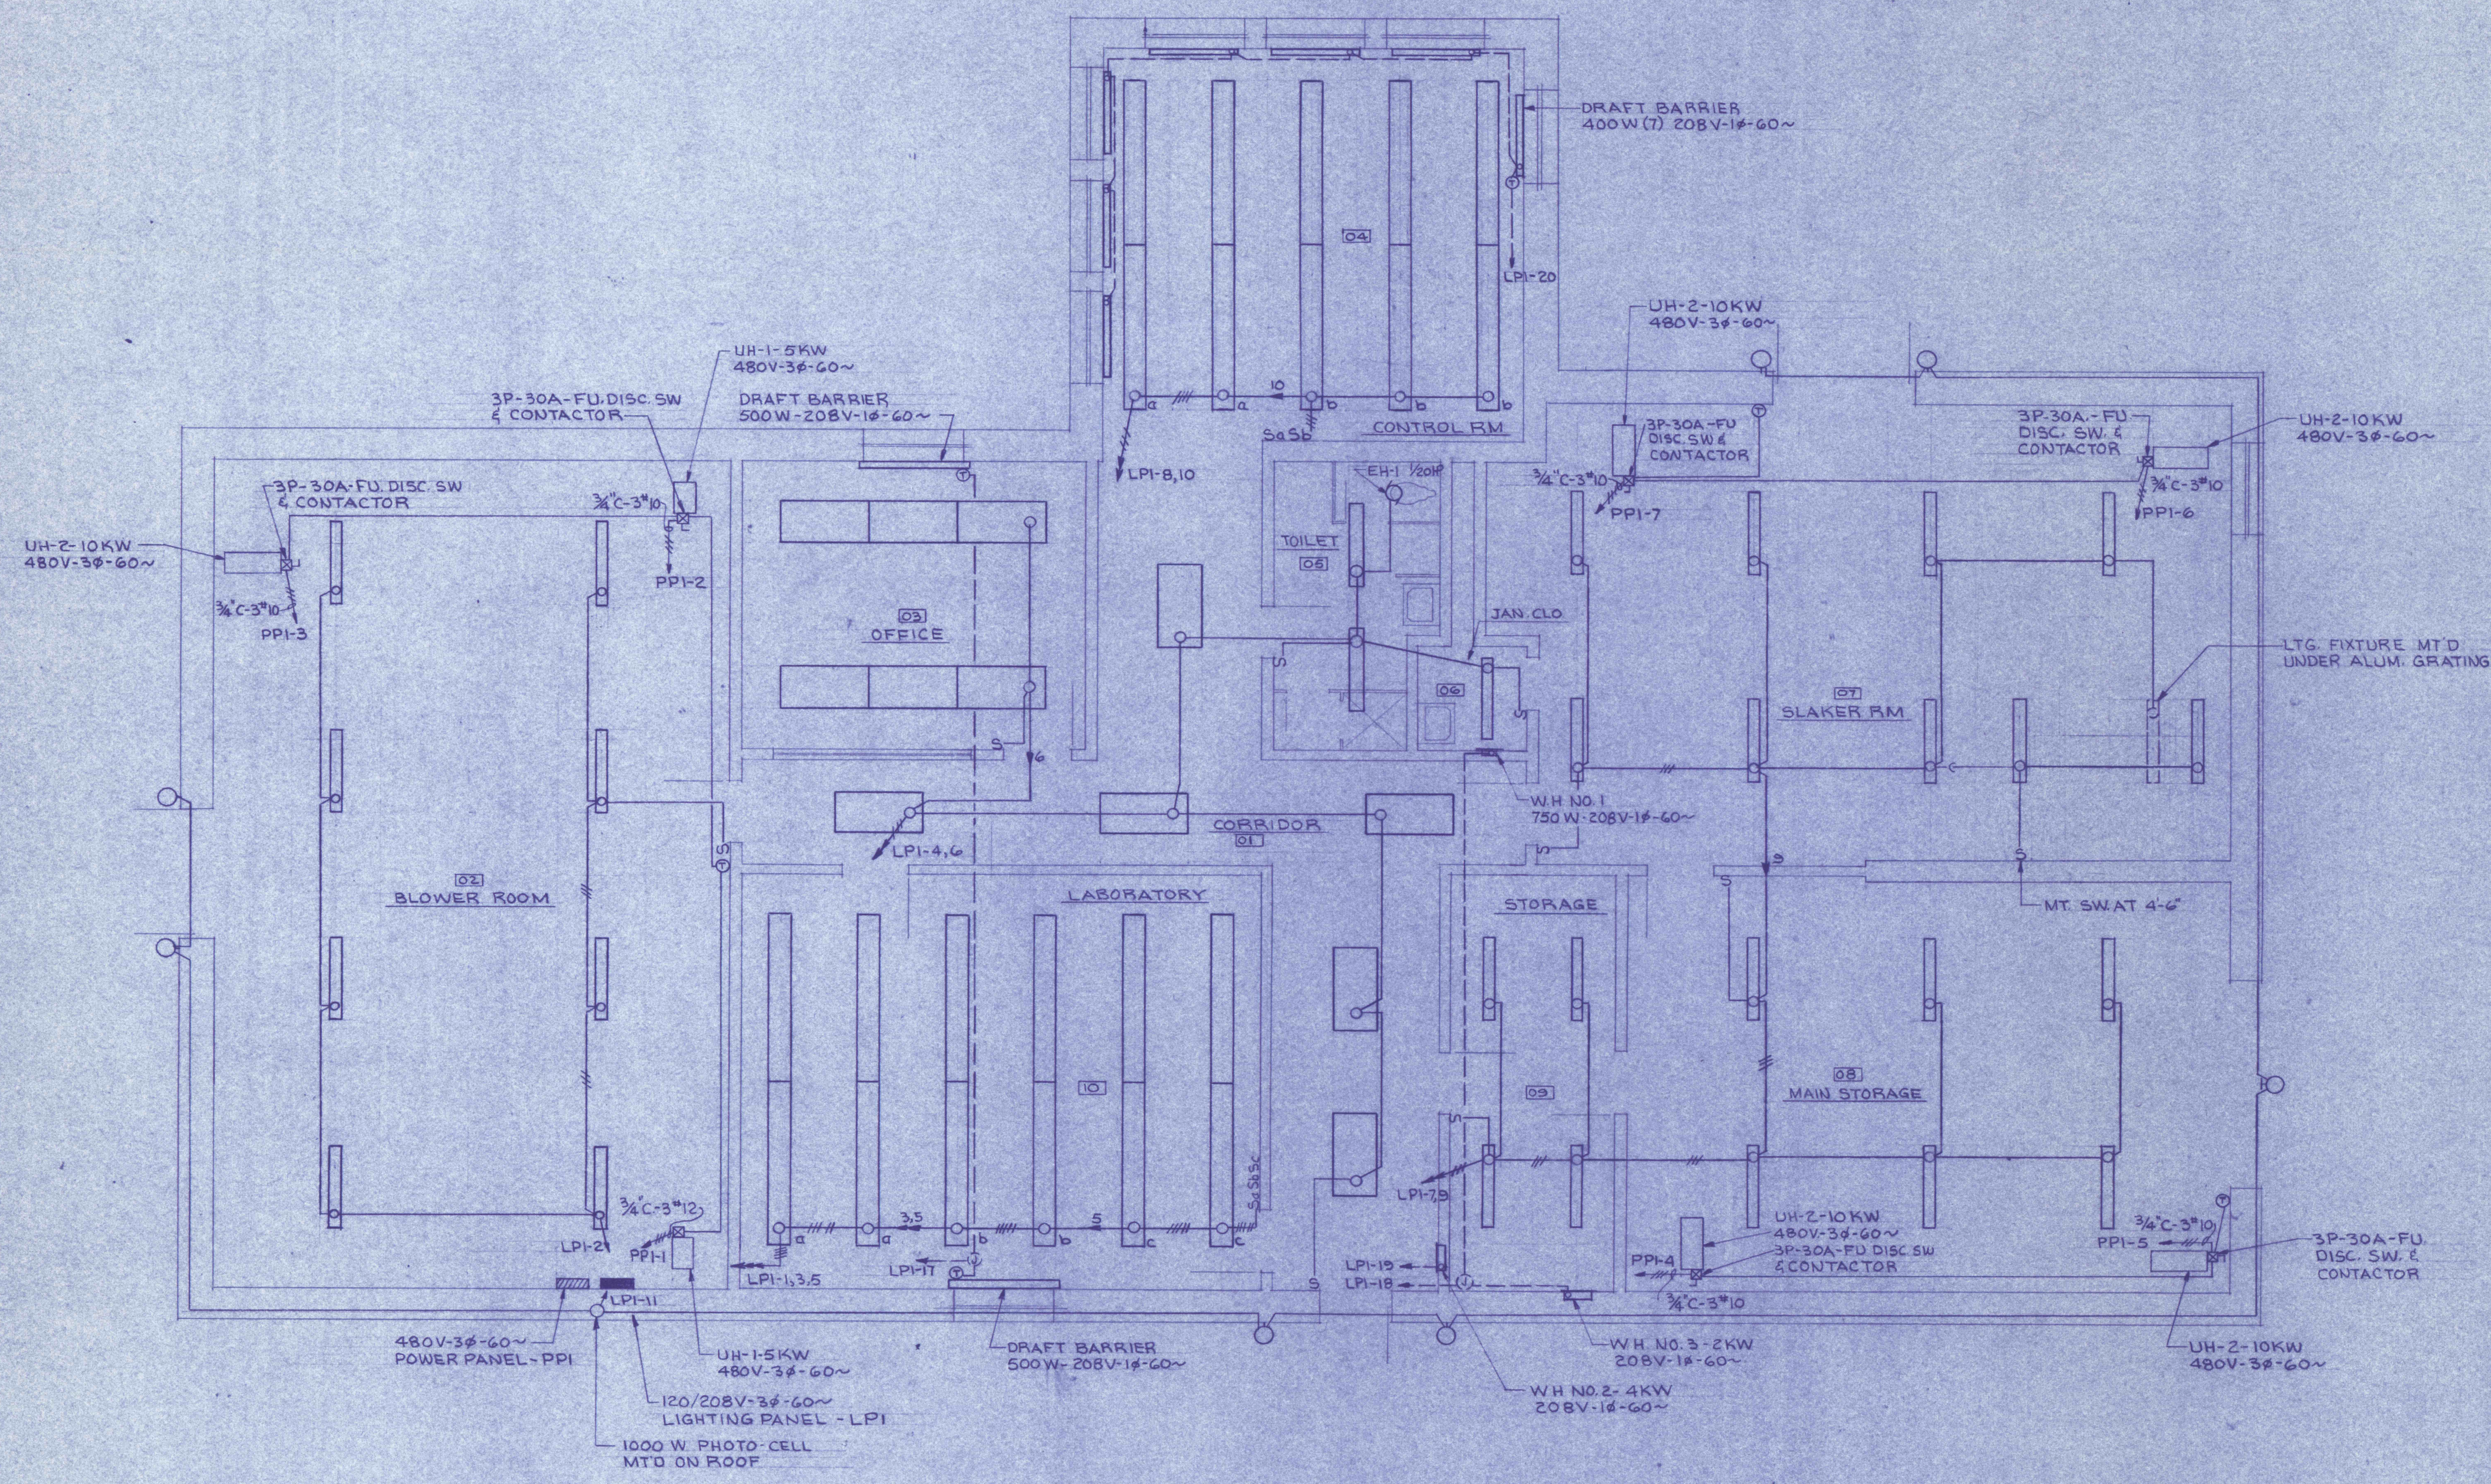

FLOOR PLAN
SCALE: 1/4" = 1'-0"

REVISIONS	
CONTROL BUILDING ELECTRICAL PLAN	
CONSTRUCTION OF TREATMENT FACILITIES FOR ACID MINE DRAINAGE	
RAUSCH CREEK WATERSHED	
SCHUYLKILL COUNTY, PENNSYLVANIA	
JOB NO. 6805	DATE: NOV 1969
SCALE: AS NOTED	DRAWN: JJJ
APPROVED:	
ANTHRACITE RESEARCH & DEVELOPMENT CO. INC.	
consulting engineers	
POTTSVILLE	TANAGUA
PENNSYLVANIA	
E-2	