

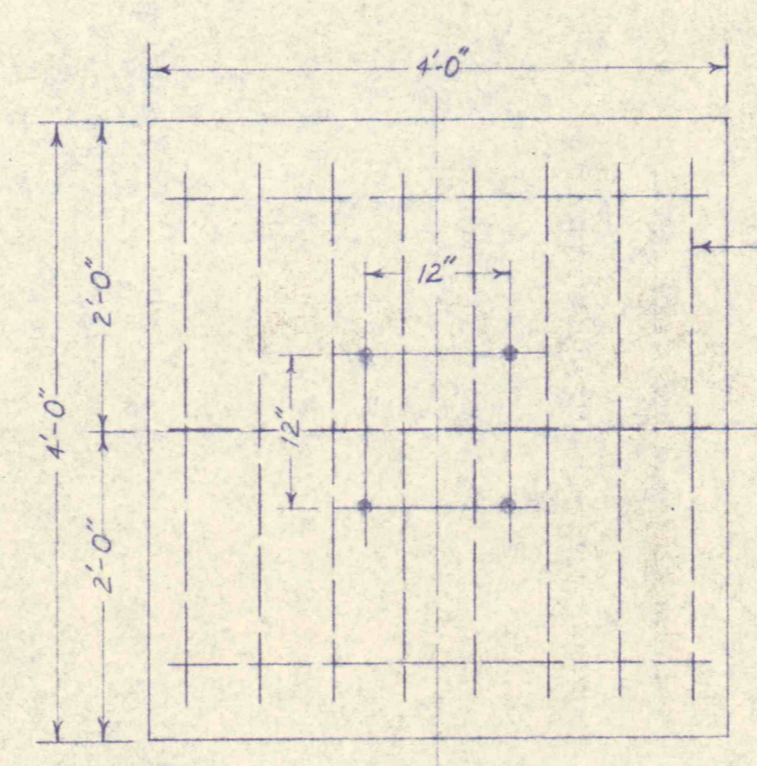
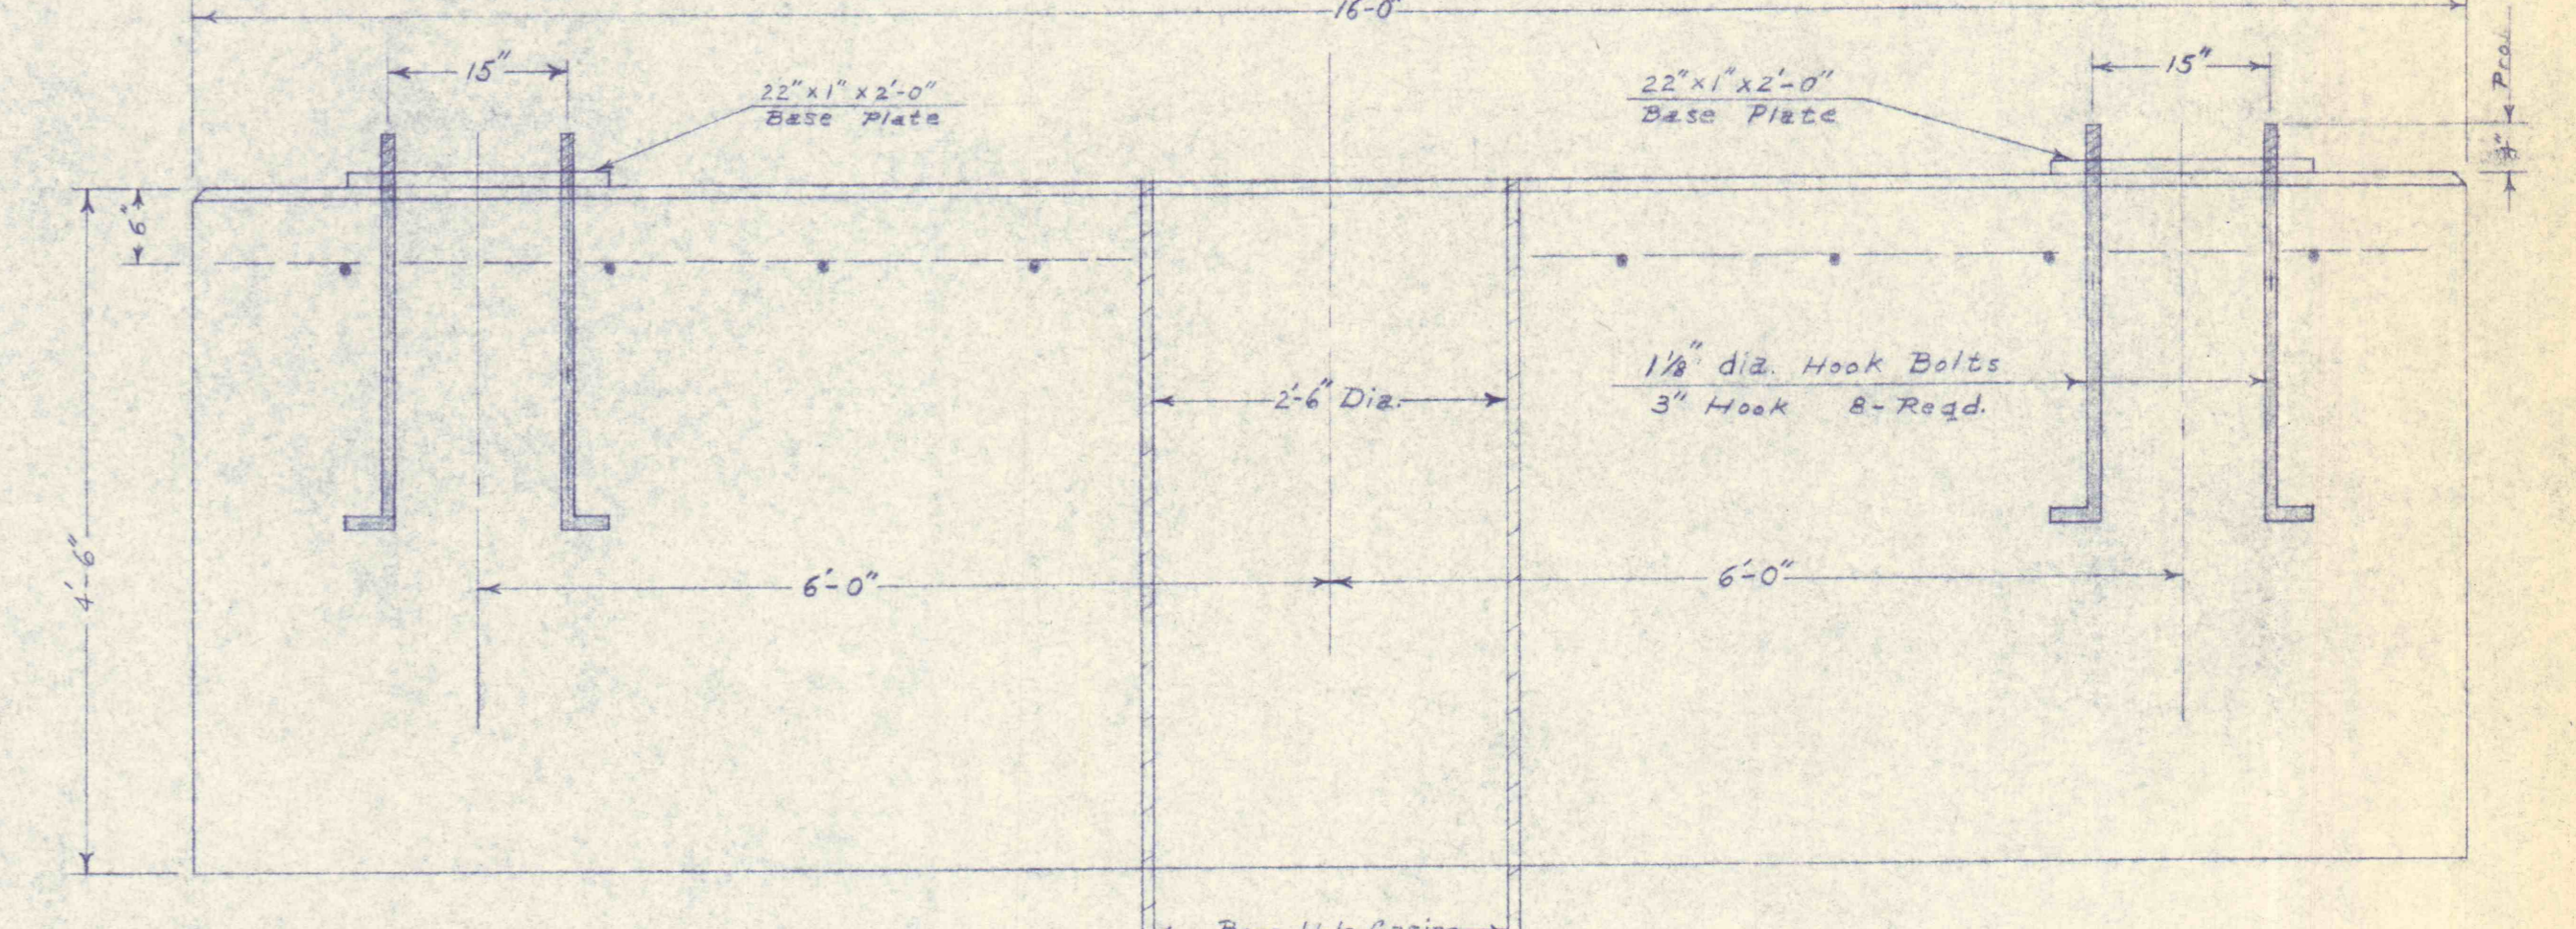


5-DAY OILER CABINET
ALL WELDED CONSTRUCTION
ONE REQD - R-180418
SCALE 1"=10"

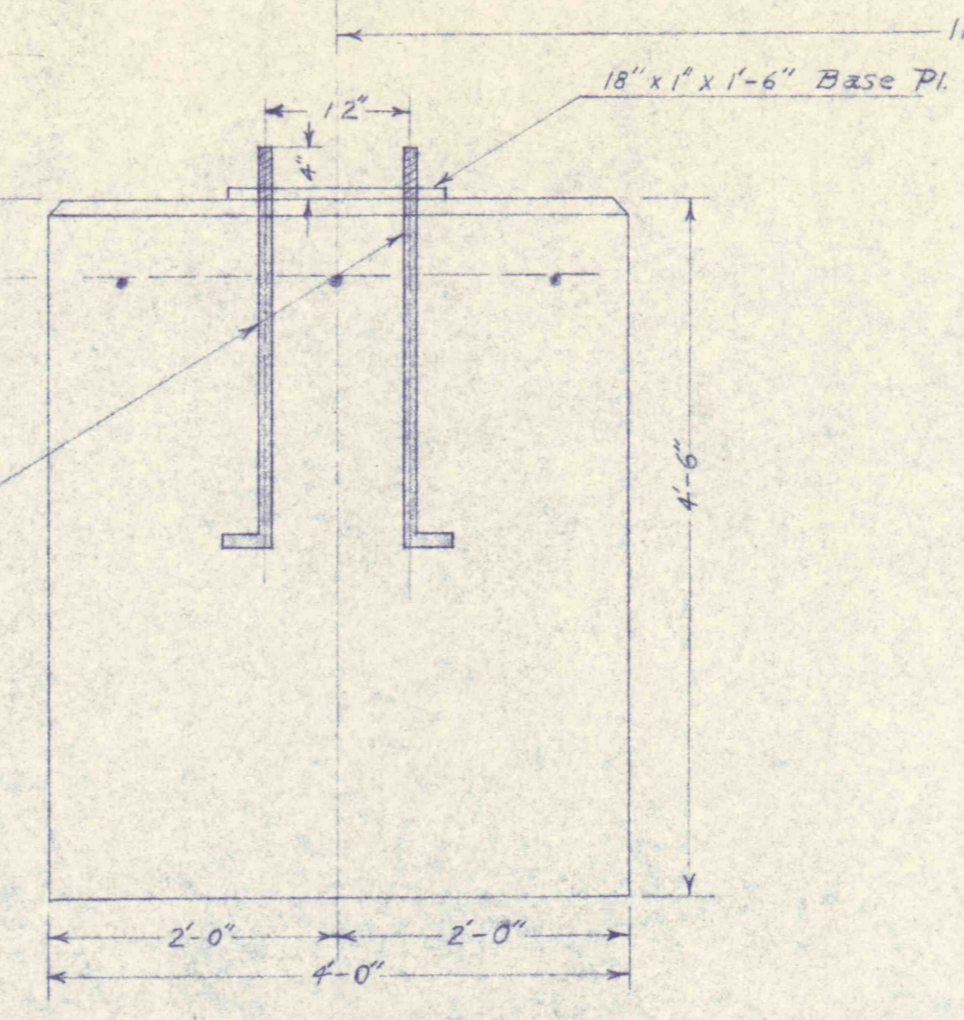


4-1/8" dia Hook Bolts
3" Hook - 4" Proj.

Tower Pier Y

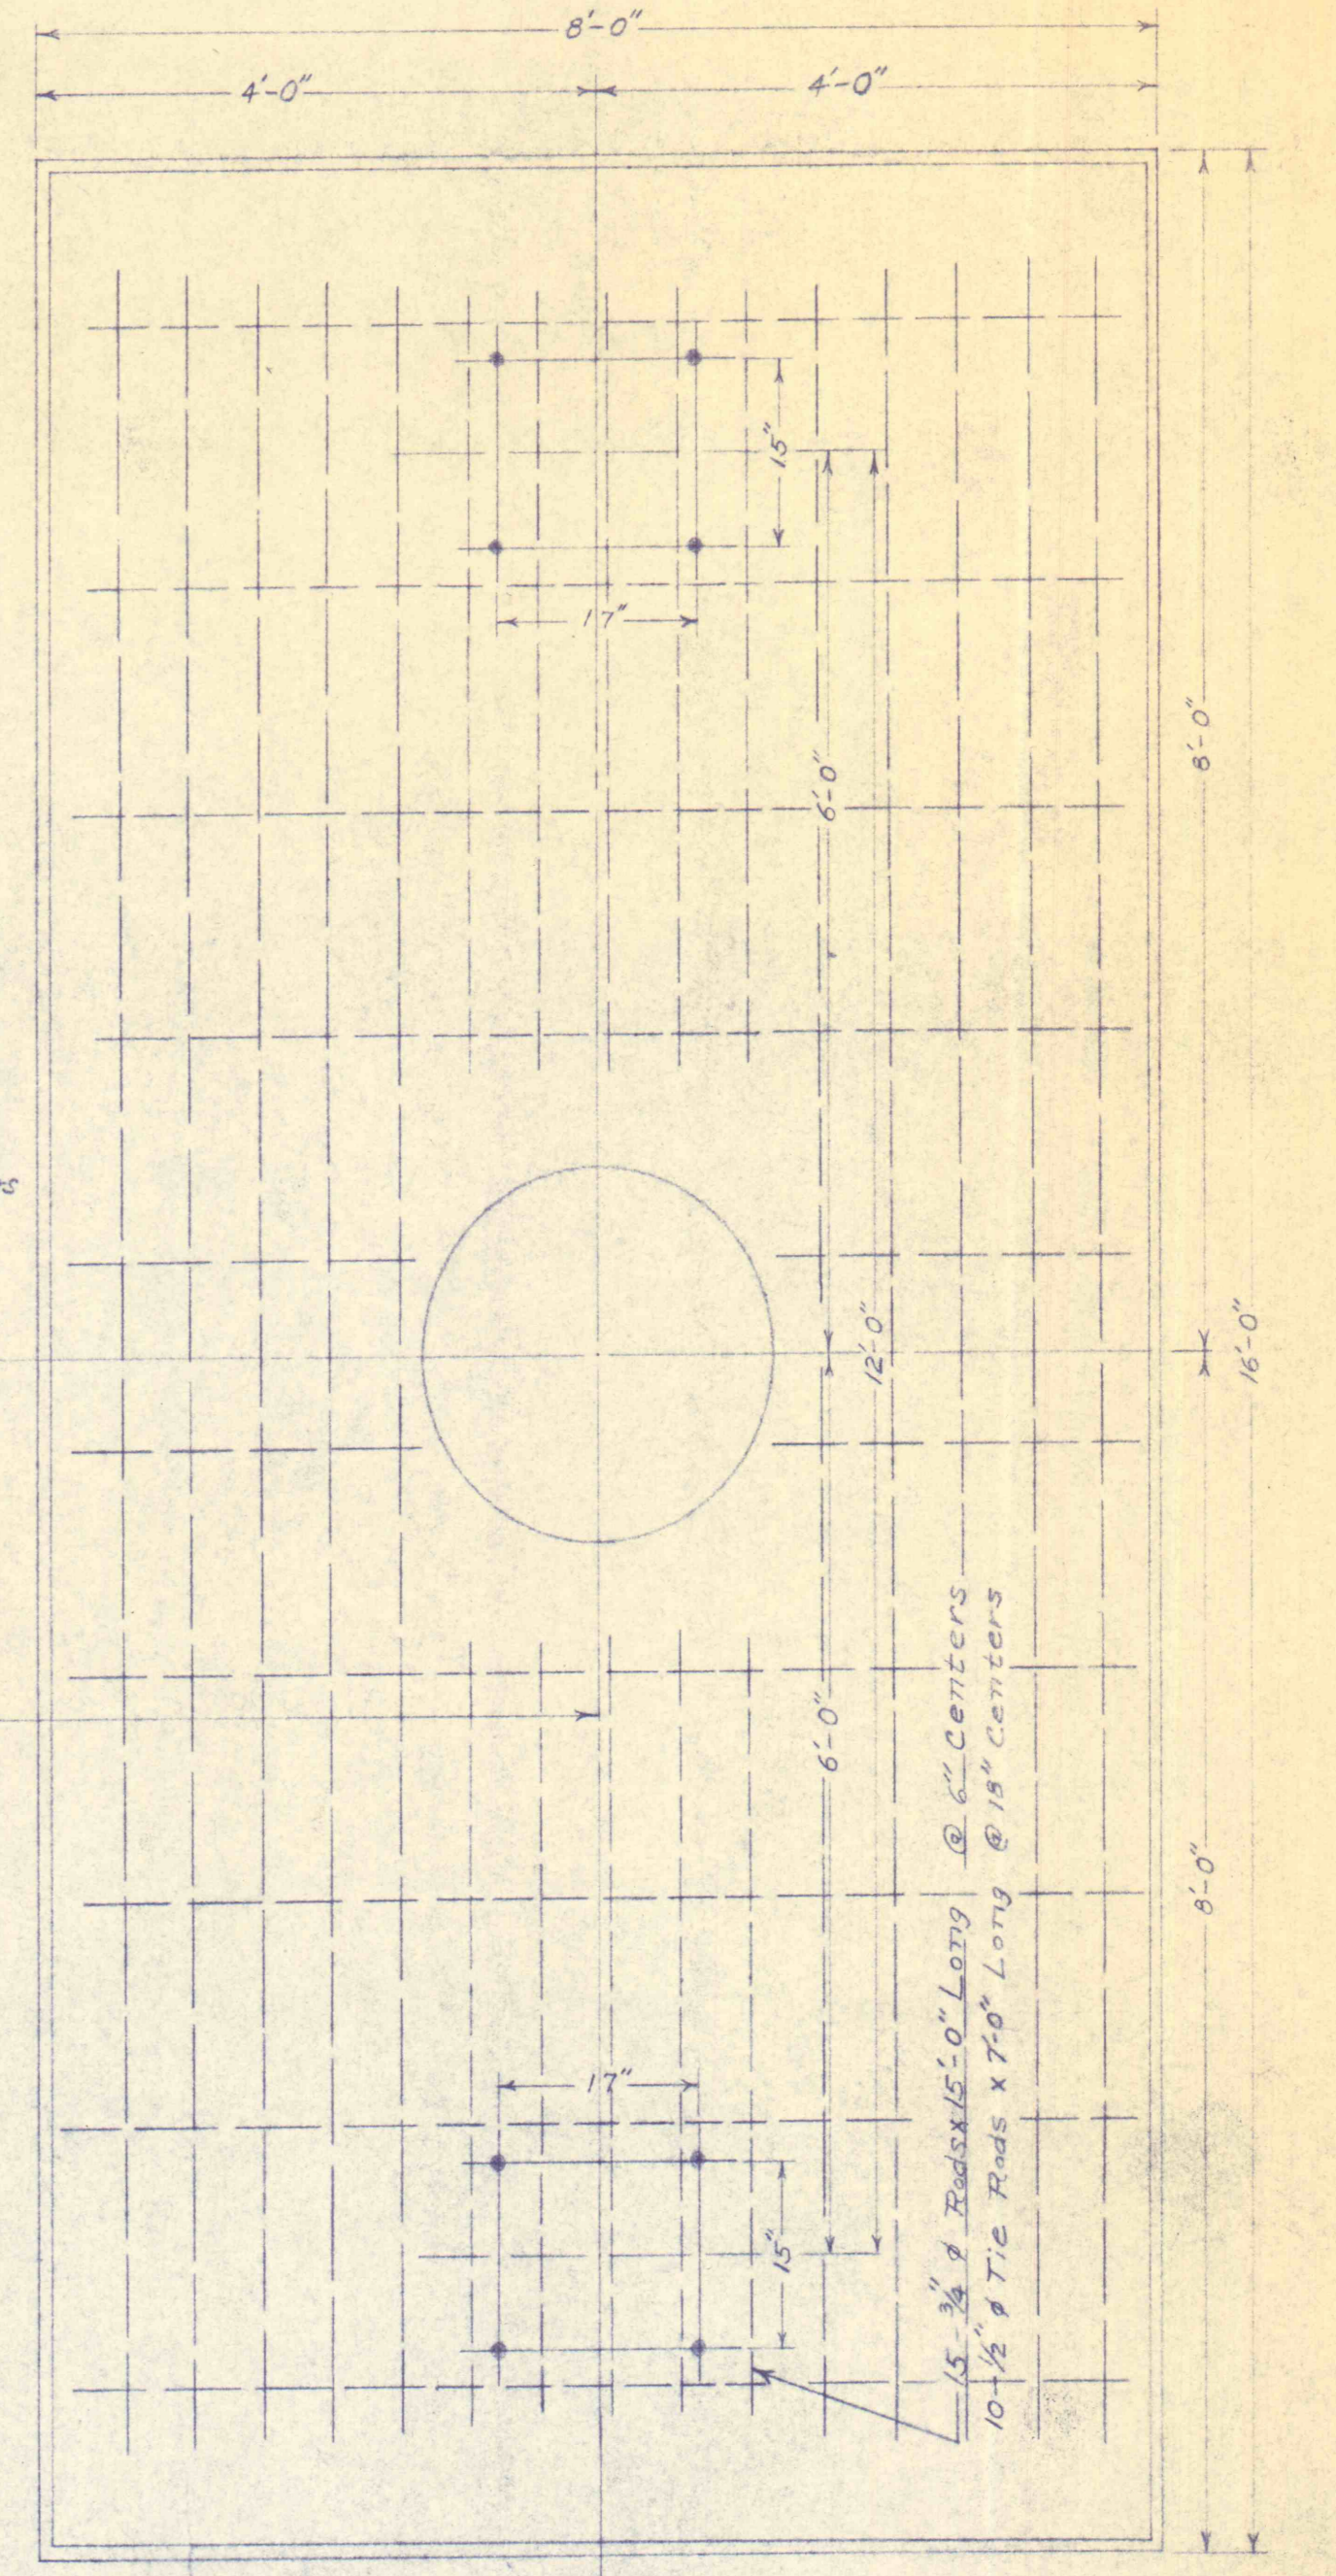


Longitudinal Sect. A-A
Tower Pier-X
HEADFRAME & PUMP FOUNDATION scale 3/4"=1'

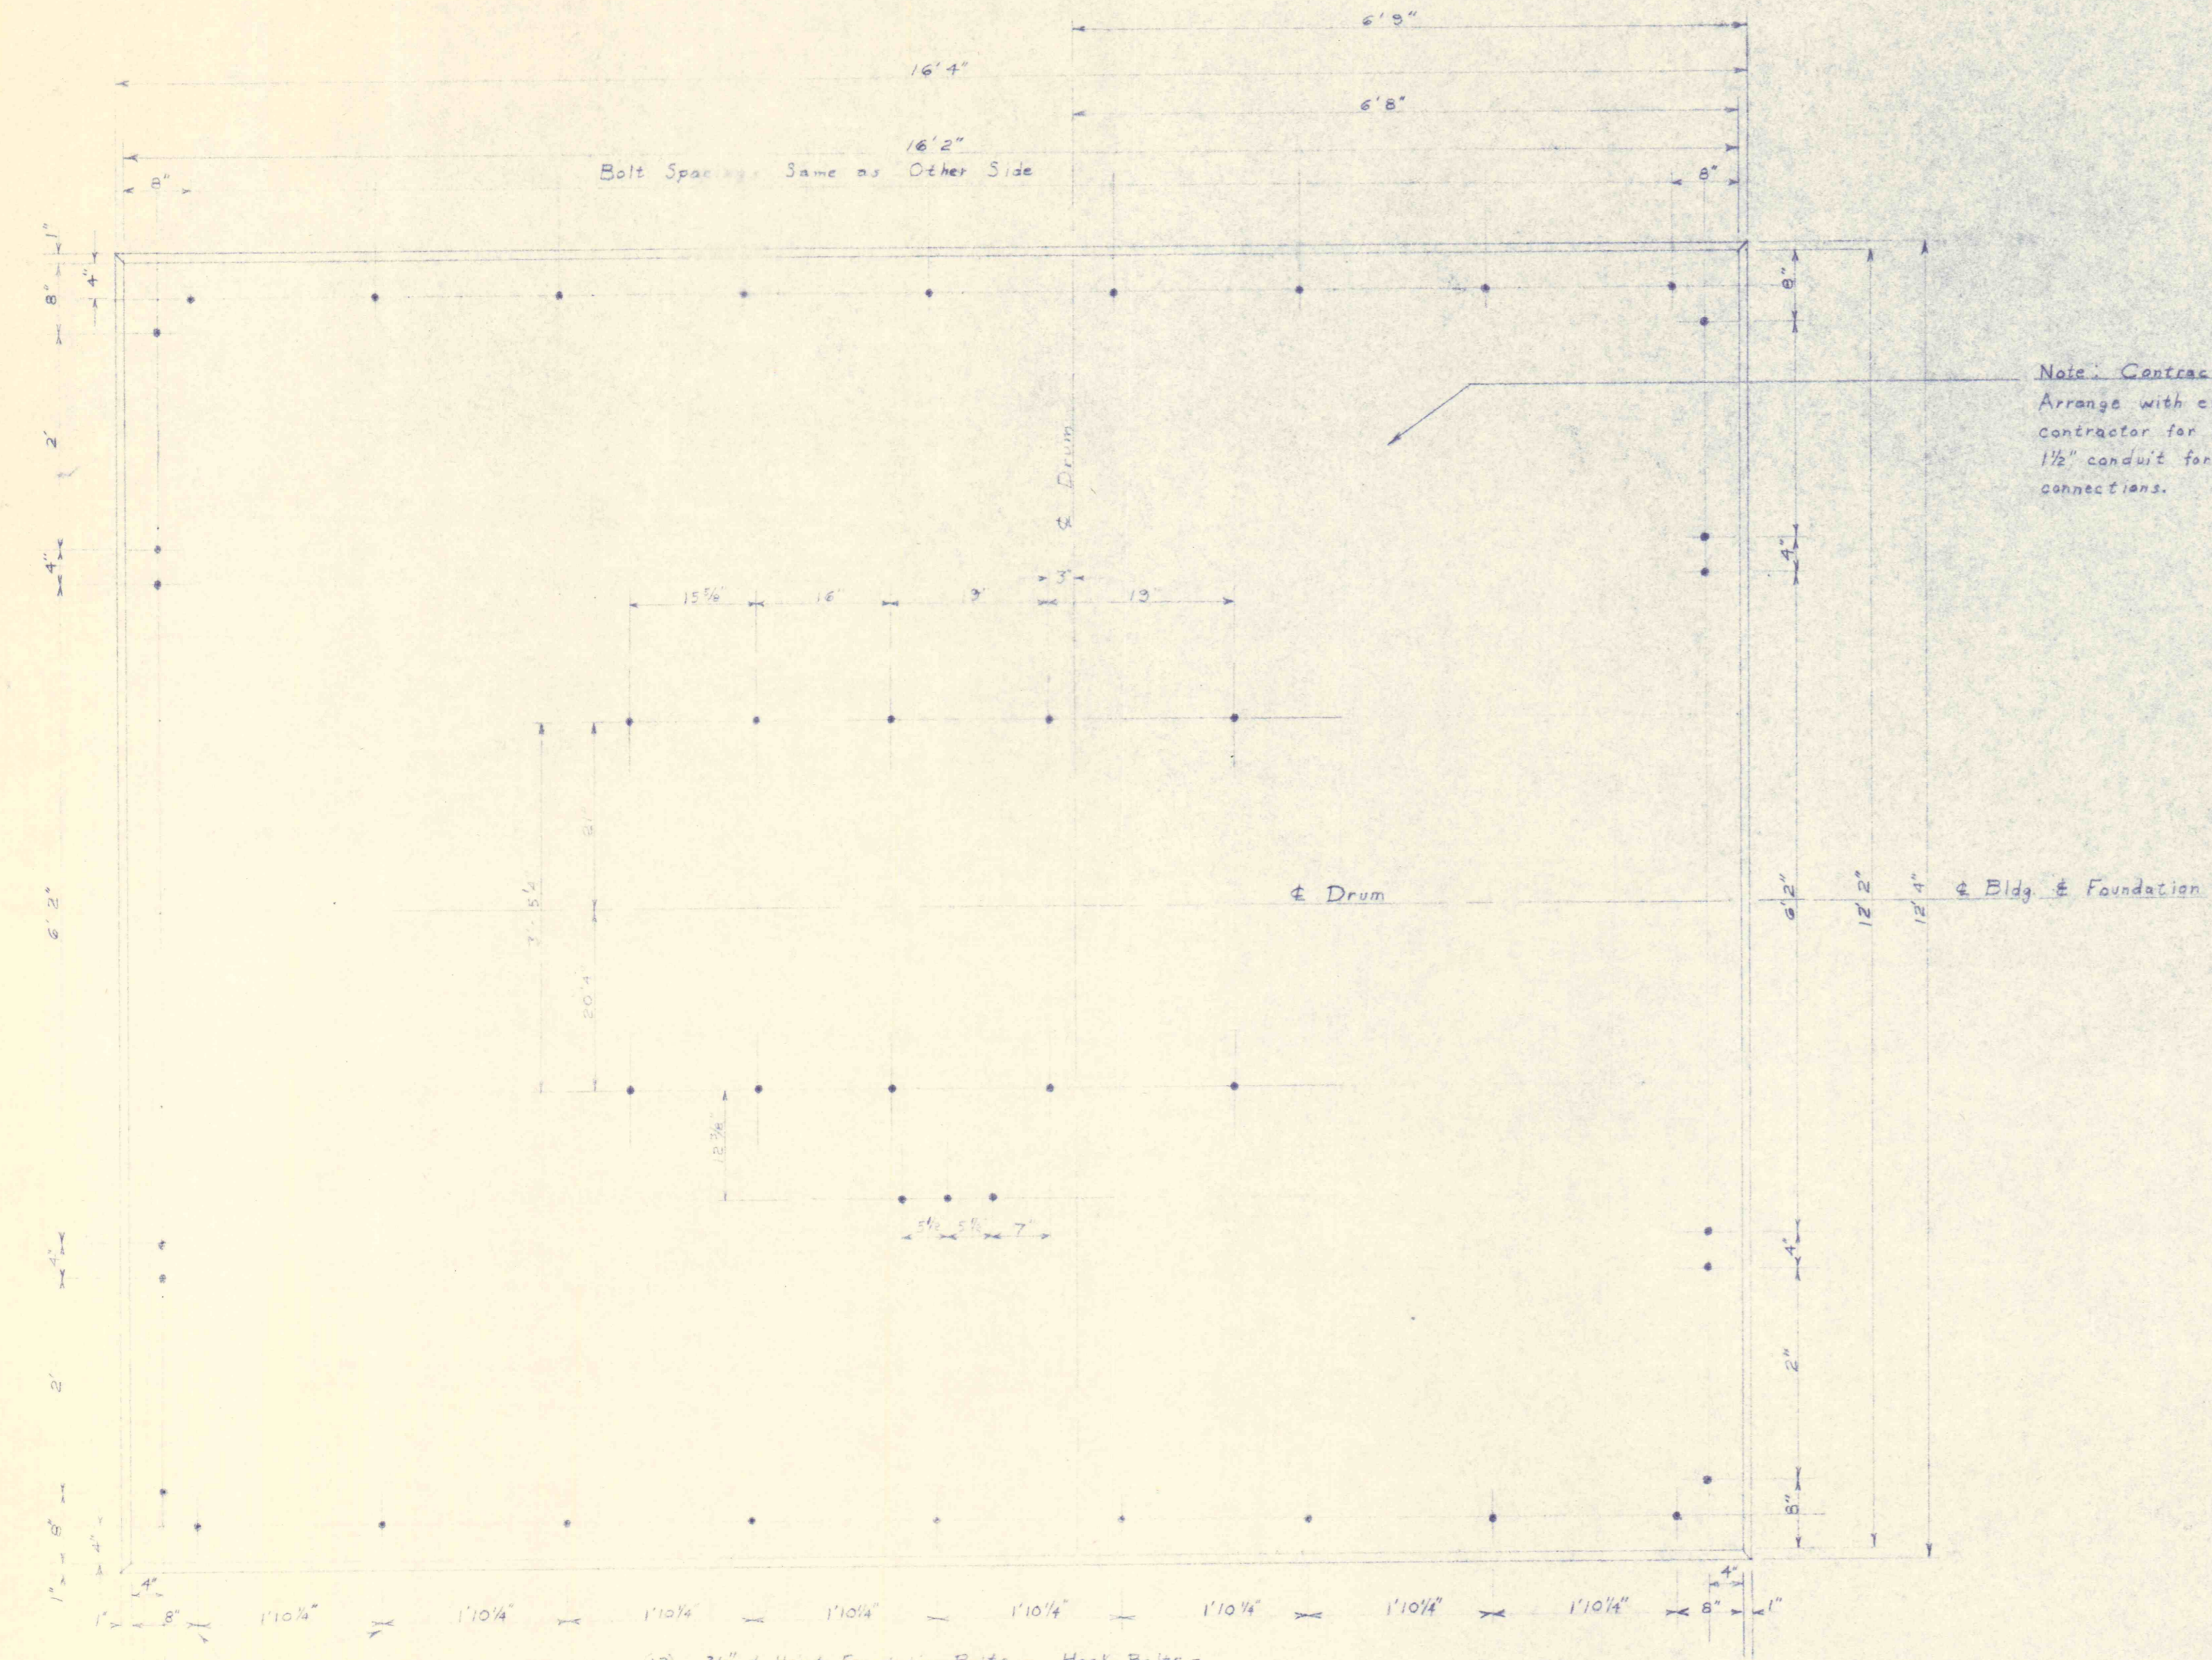


Note: Contractor -
Arrange with electrical
contractor for location of
1/2" conduit for motor
connections.

5-1/2" # Rods x 14" Long @ 12" Centers
12-1/2" # Rods x 4'-6" Long @ 12" Centers

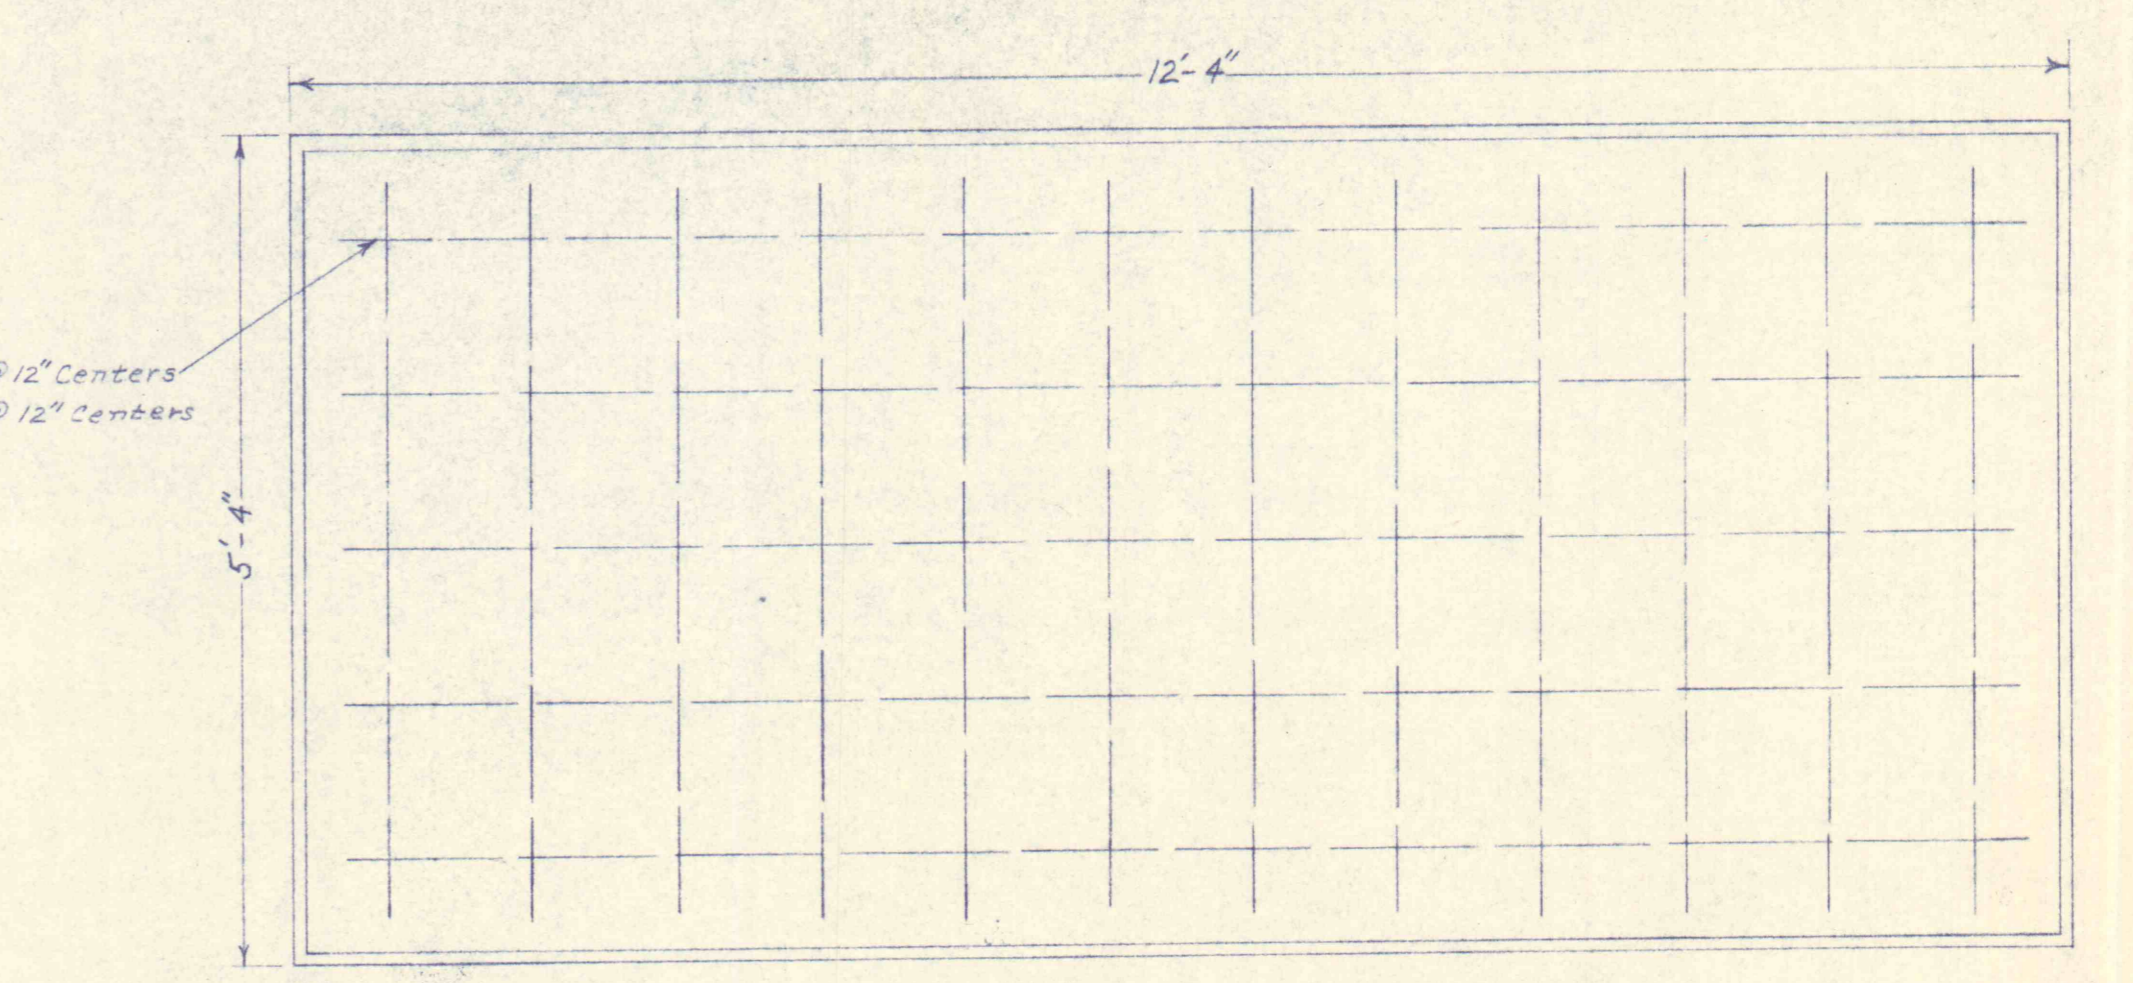

CONTROL FOUNDATION scale 3/4"=1'

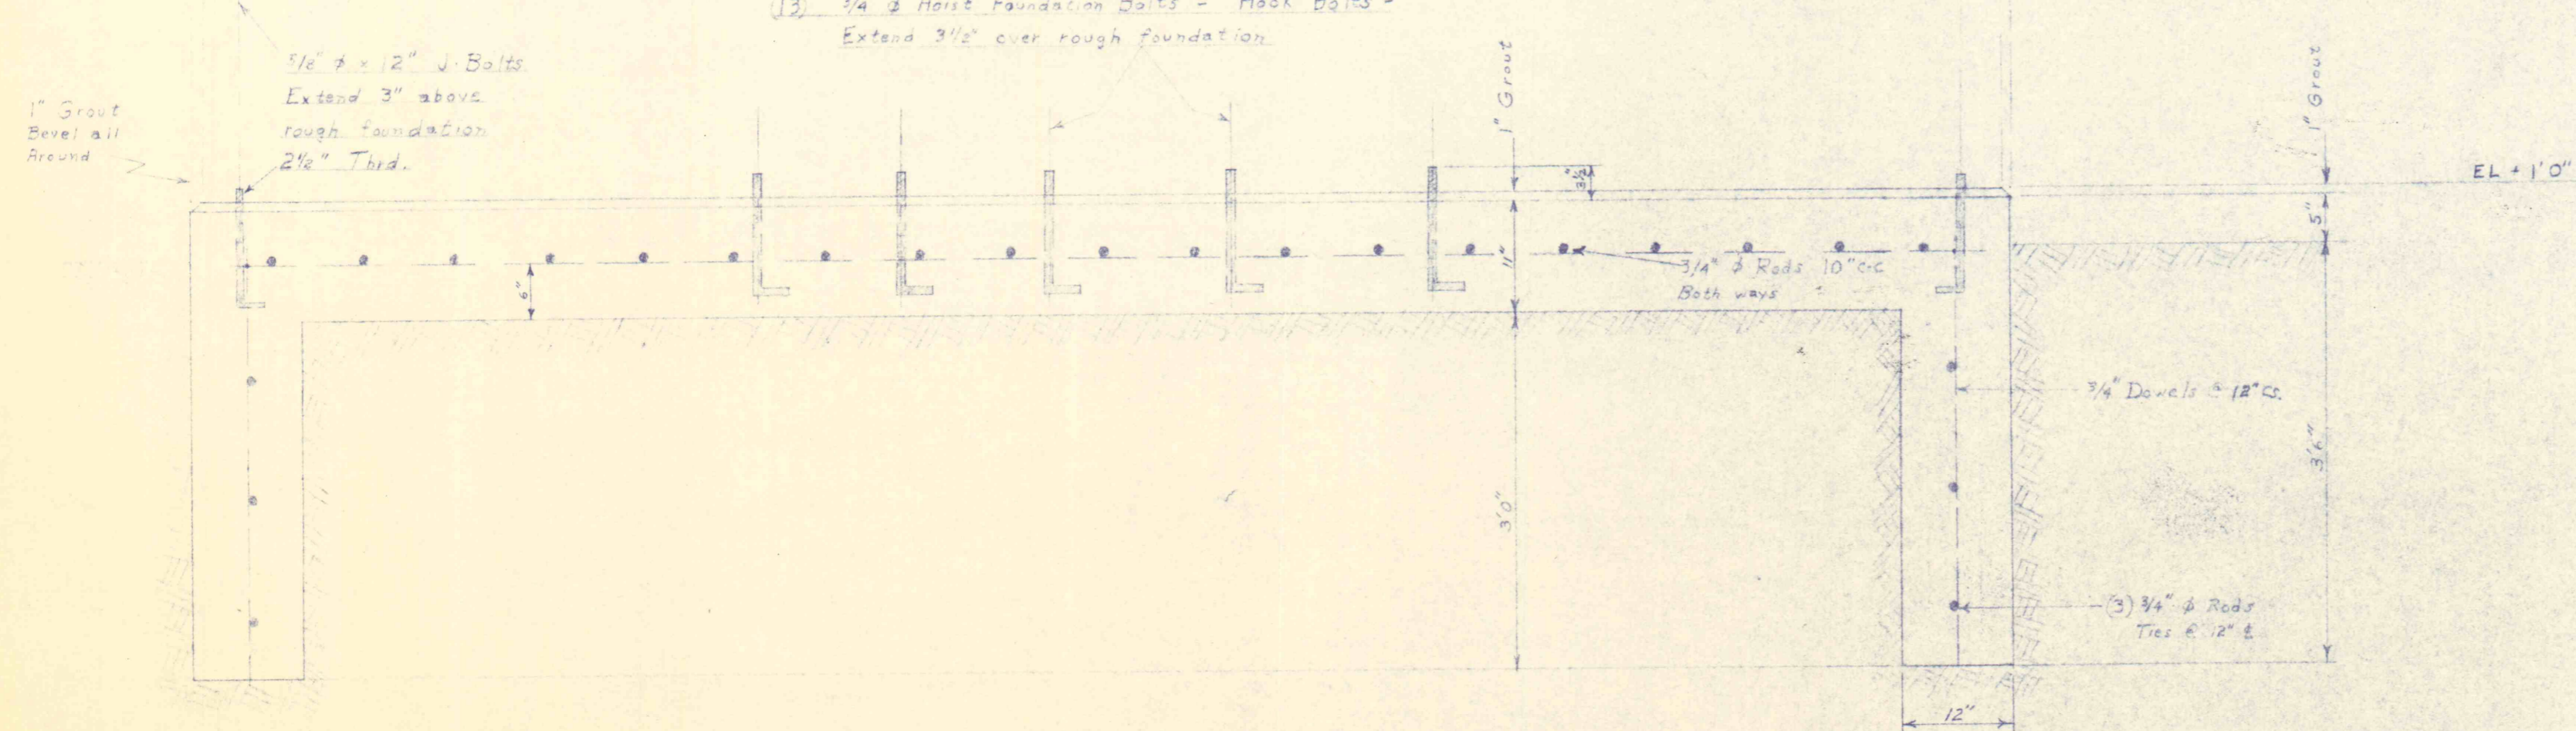

DETAIL "E"
FOUNDATIONS FOR HOIST & HOIST BLDG. Scale 3/4"=1'

FOUNDATION PLAN
of Proposed
DEEP WELL PUMP INSTALLATION
situated at
MARVINE COLLIERY
in
CITY OF SCRANTON, LACKAWANNA COUNTY, PENNA.
DEPARTMENT OF MINES AND MINERAL INDUSTRIES
90 East Union Street Wilkes-Barre, Penna.
Scale: 3/4"=1' March 17, 1957
Plan No-3 Drawn By Pete Wilgus