

GANNETT FLEMING CORDDRY AND CARPENTER, INC. (HEREIN REFERRED TO AS GFCC) HEREBY STATES THAT, PURSUANT TO THE PROVISIONS OF ACT NO. 287 OF DECEMBER 10, 1974, OF THE PENNSYLVANIA LEGISLATURE, IT HAS PERFORMED THE FOLLOWING IN PREPARING THESE DRAWINGS REQUIRING EXCAVATION OR DEMOLITION WORK AT SITES WITHIN THE POLITICAL SUBDIVISION(S) SHOWN ON THE DRAWINGS:

(1) PURSUANT TO SECTION 4, CLAUSE (1) OF SAID ACT, GFCC INSPECTED OR OBTAINED A COPY OF THE LIST OF USERS, AS PRESCRIBED BY SECTION 3, OF SAID ACT, IN SAID POLITICAL SUBDIVISION(S). "USER" IS DEFINED IN SECTION 1 OF SAID ACT TO INCLUDE "PUBLIC UTILITY, MUNICIPAL CORPORATION, MUNICIPALITY, AUTHORITY, RURAL ELECTRIC COOPERATIVE OR OTHER PERSON WHO OR WHICH USES A LINE TO PROVIDE SERVICE TO ONE OR MORE CONSUMERS".


(2) PURSUANT TO SECTION 4, CLAUSE (2) OF SAID ACT, GFCC REQUESTED FROM EACH USER'S OFFICE DESIGNATED ON SUCH LIST THE INFORMATION PRESCRIBED BY SECTION 2, CLAUSE (4) OF SAID ACT, BEING "INFORMATION AS TO THE APPROXIMATE LOCATION AND TYPE OF THE USER'S LINES" AT THE SITES OF EXCAVATION OR DEMOLITION WORK. "LINE" IS DEFINED IN SAID ACT AS MEANING "AN UNDERGROUND CONDUCTOR USED IN PROVIDING ELECTRIC OR COMMUNICATION SERVICE, OR AN UNDERGROUND PIPE USED IN PROVIDING GAS, OIL OR OIL PRODUCT DELIVERY, SEWAGE, WATER OR OTHER SERVICE TO ONE OR MORE CONSUMERS OF SUCH SERVICE".

(3) PURSUANT TO SECTION 4, CLAUSE (3) OF SAID ACT, GFCC HAS SHOWN UPON THESE DRAWINGS "THE APPROXIMATE LOCATION AND TYPE OF EACH LINE, DERIVED PURSUANT TO THE REQUEST MADE AS REQUIRED BY CLAUSE (2) OF SECTION 4 OF SAID ACT, AND THE USER'S NAME, OFFICE ADDRESSES AND TELEPHONE NUMBERS, AS SHOWN ON THE LIST DESCRIBED IN PARAGRAPH NO. 1 ABOVE.

AND GFCC DOES NOT MAKE ANY REPRESENTATION, WARRANTY, ASSURANCE OR GUARANTEE THAT THE INFORMATION RECEIVED PURSUANT TO SAID REQUEST AND AS REFLECTED ON THESE DRAWINGS IS CORRECT OR ACCURATE, BUT GFCC IS REFLECTING SAID INFORMATION ON THESE DRAWINGS ONLY DUE TO THE REQUIREMENTS OF THE SAID ACT NO. 287 OF DECEMBER 10, 1974.

GANNETT FLEMING CORDDRY AND CARPENTER, INC.
BY: _____

DATE: JUNE 15, 1977

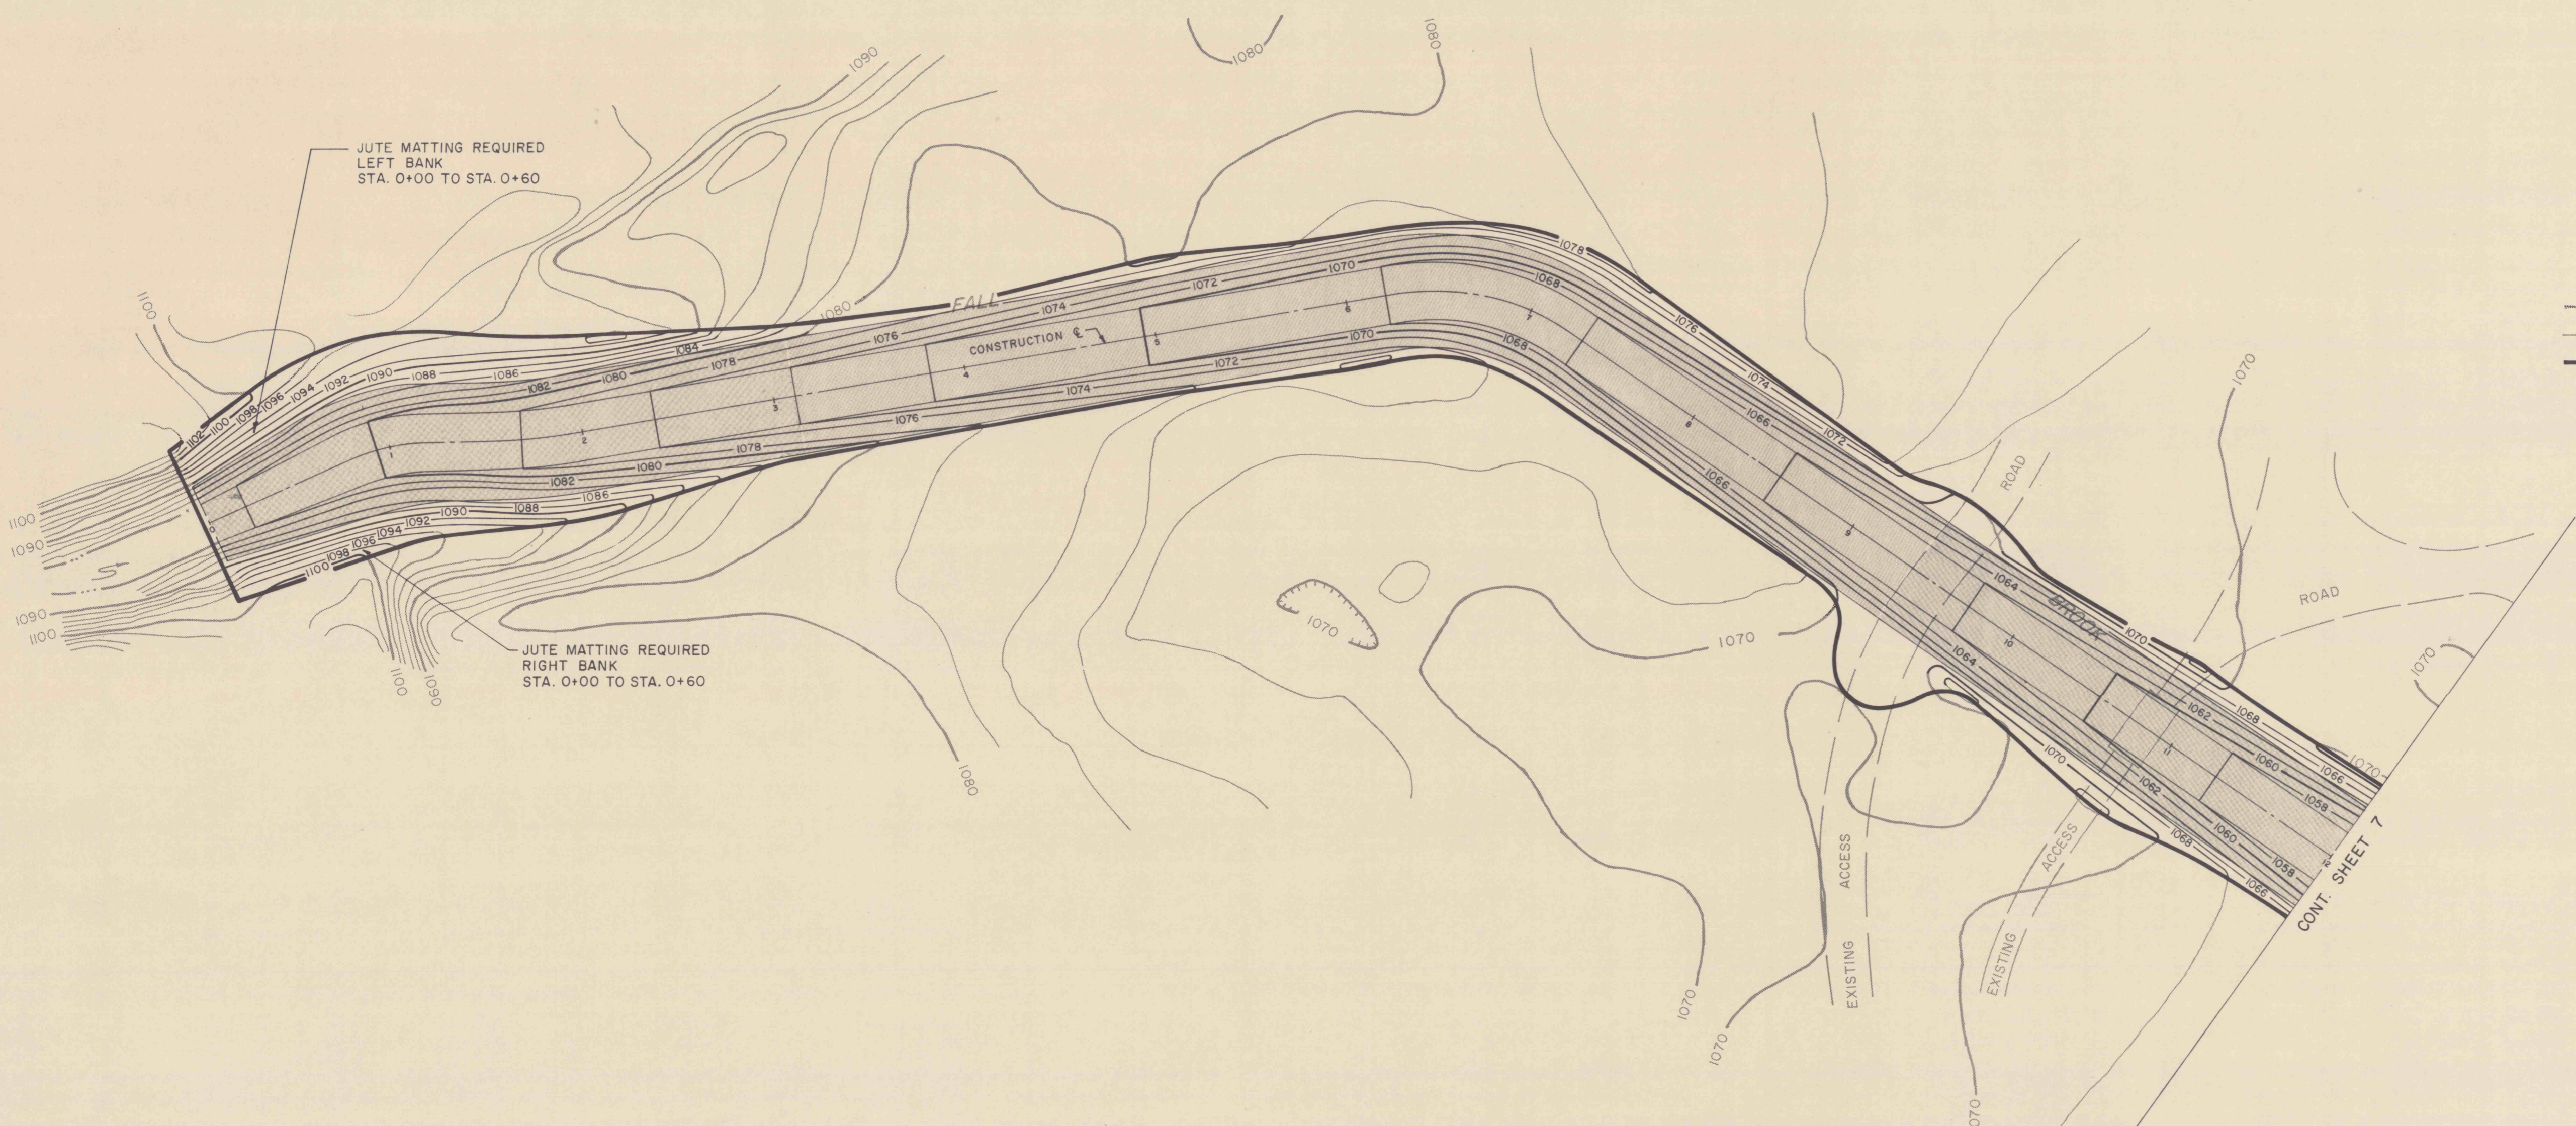

LEGEND

- EXISTING CONTOUR
- 1064- PROPOSED CONTOUR
- LIMIT OF GRADING AND REVEGETATION

NOTE:
CONTOUR INTERVAL 2 FEET.

NO.	DATE	REVISION	APPR.

SUBMITTED _____

PROFESSIONAL _____

APPROVED _____
CHIEF - DIVISION OF MINE RECLAMATION

APPROVED _____
DIRECTOR - BUREAU OF DESIGN

REGISTERED PROFESSIONAL ENGINEER _____

DATE _____

COMMONWEALTH OF PENNSYLVANIA
DEPARTMENT OF ENVIRONMENTAL RESOURCES
OFFICE OF RESOURCES MANAGEMENT

CONTRACT NO. SL 139-1-6-101.1

**MINE DRAINAGE POLLUTION ABATEMENT
FALL BROOK
LACKAWANNA RIVER WATERSHED
LACKAWANNA COUNTY
PENNSYLVANIA**

GANNETT FLEMING CORDDRY AND CARPENTER, INC.
Consulting Engineers
P.O. BOX 1963 HARRISBURG, PA.

GRADING PLAN

DRAWN BY R.C.L.	DATE MAY, 1977	DRAWING NO. 6 of 12
CHECKED BY D.J.B.	SCALE 1" = 50'	