



MIN. ACREAGE REQ.
 AREA I - 1.8 ACRES
 AREA II - 1.35 ACRES
 AREA III - 1.45 ACRES

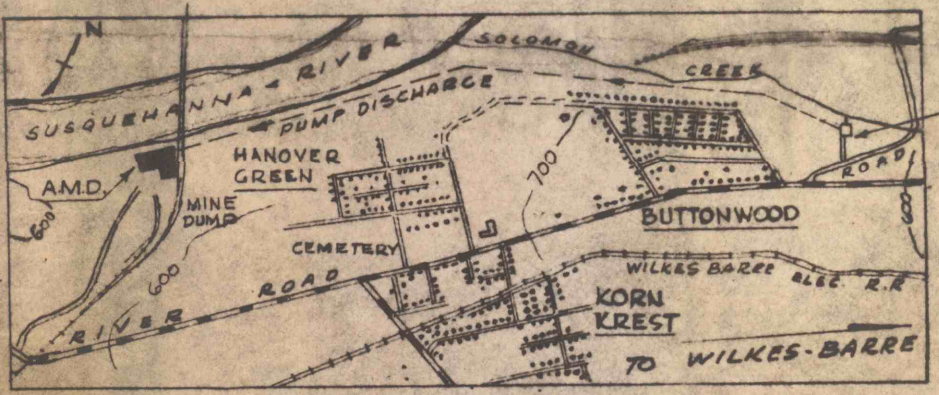

KEY PLAN
 SCALE 1" = 24000'

BUTTONWOOD OUTFALL
 NEW PUMP HOUSE

NOTE
 ALL INFORMATION HAS BEEN TAKEN FROM
 LOOMIS COLLIERY MINE MAP
 AREA HAS NOT BEEN SURVEYED

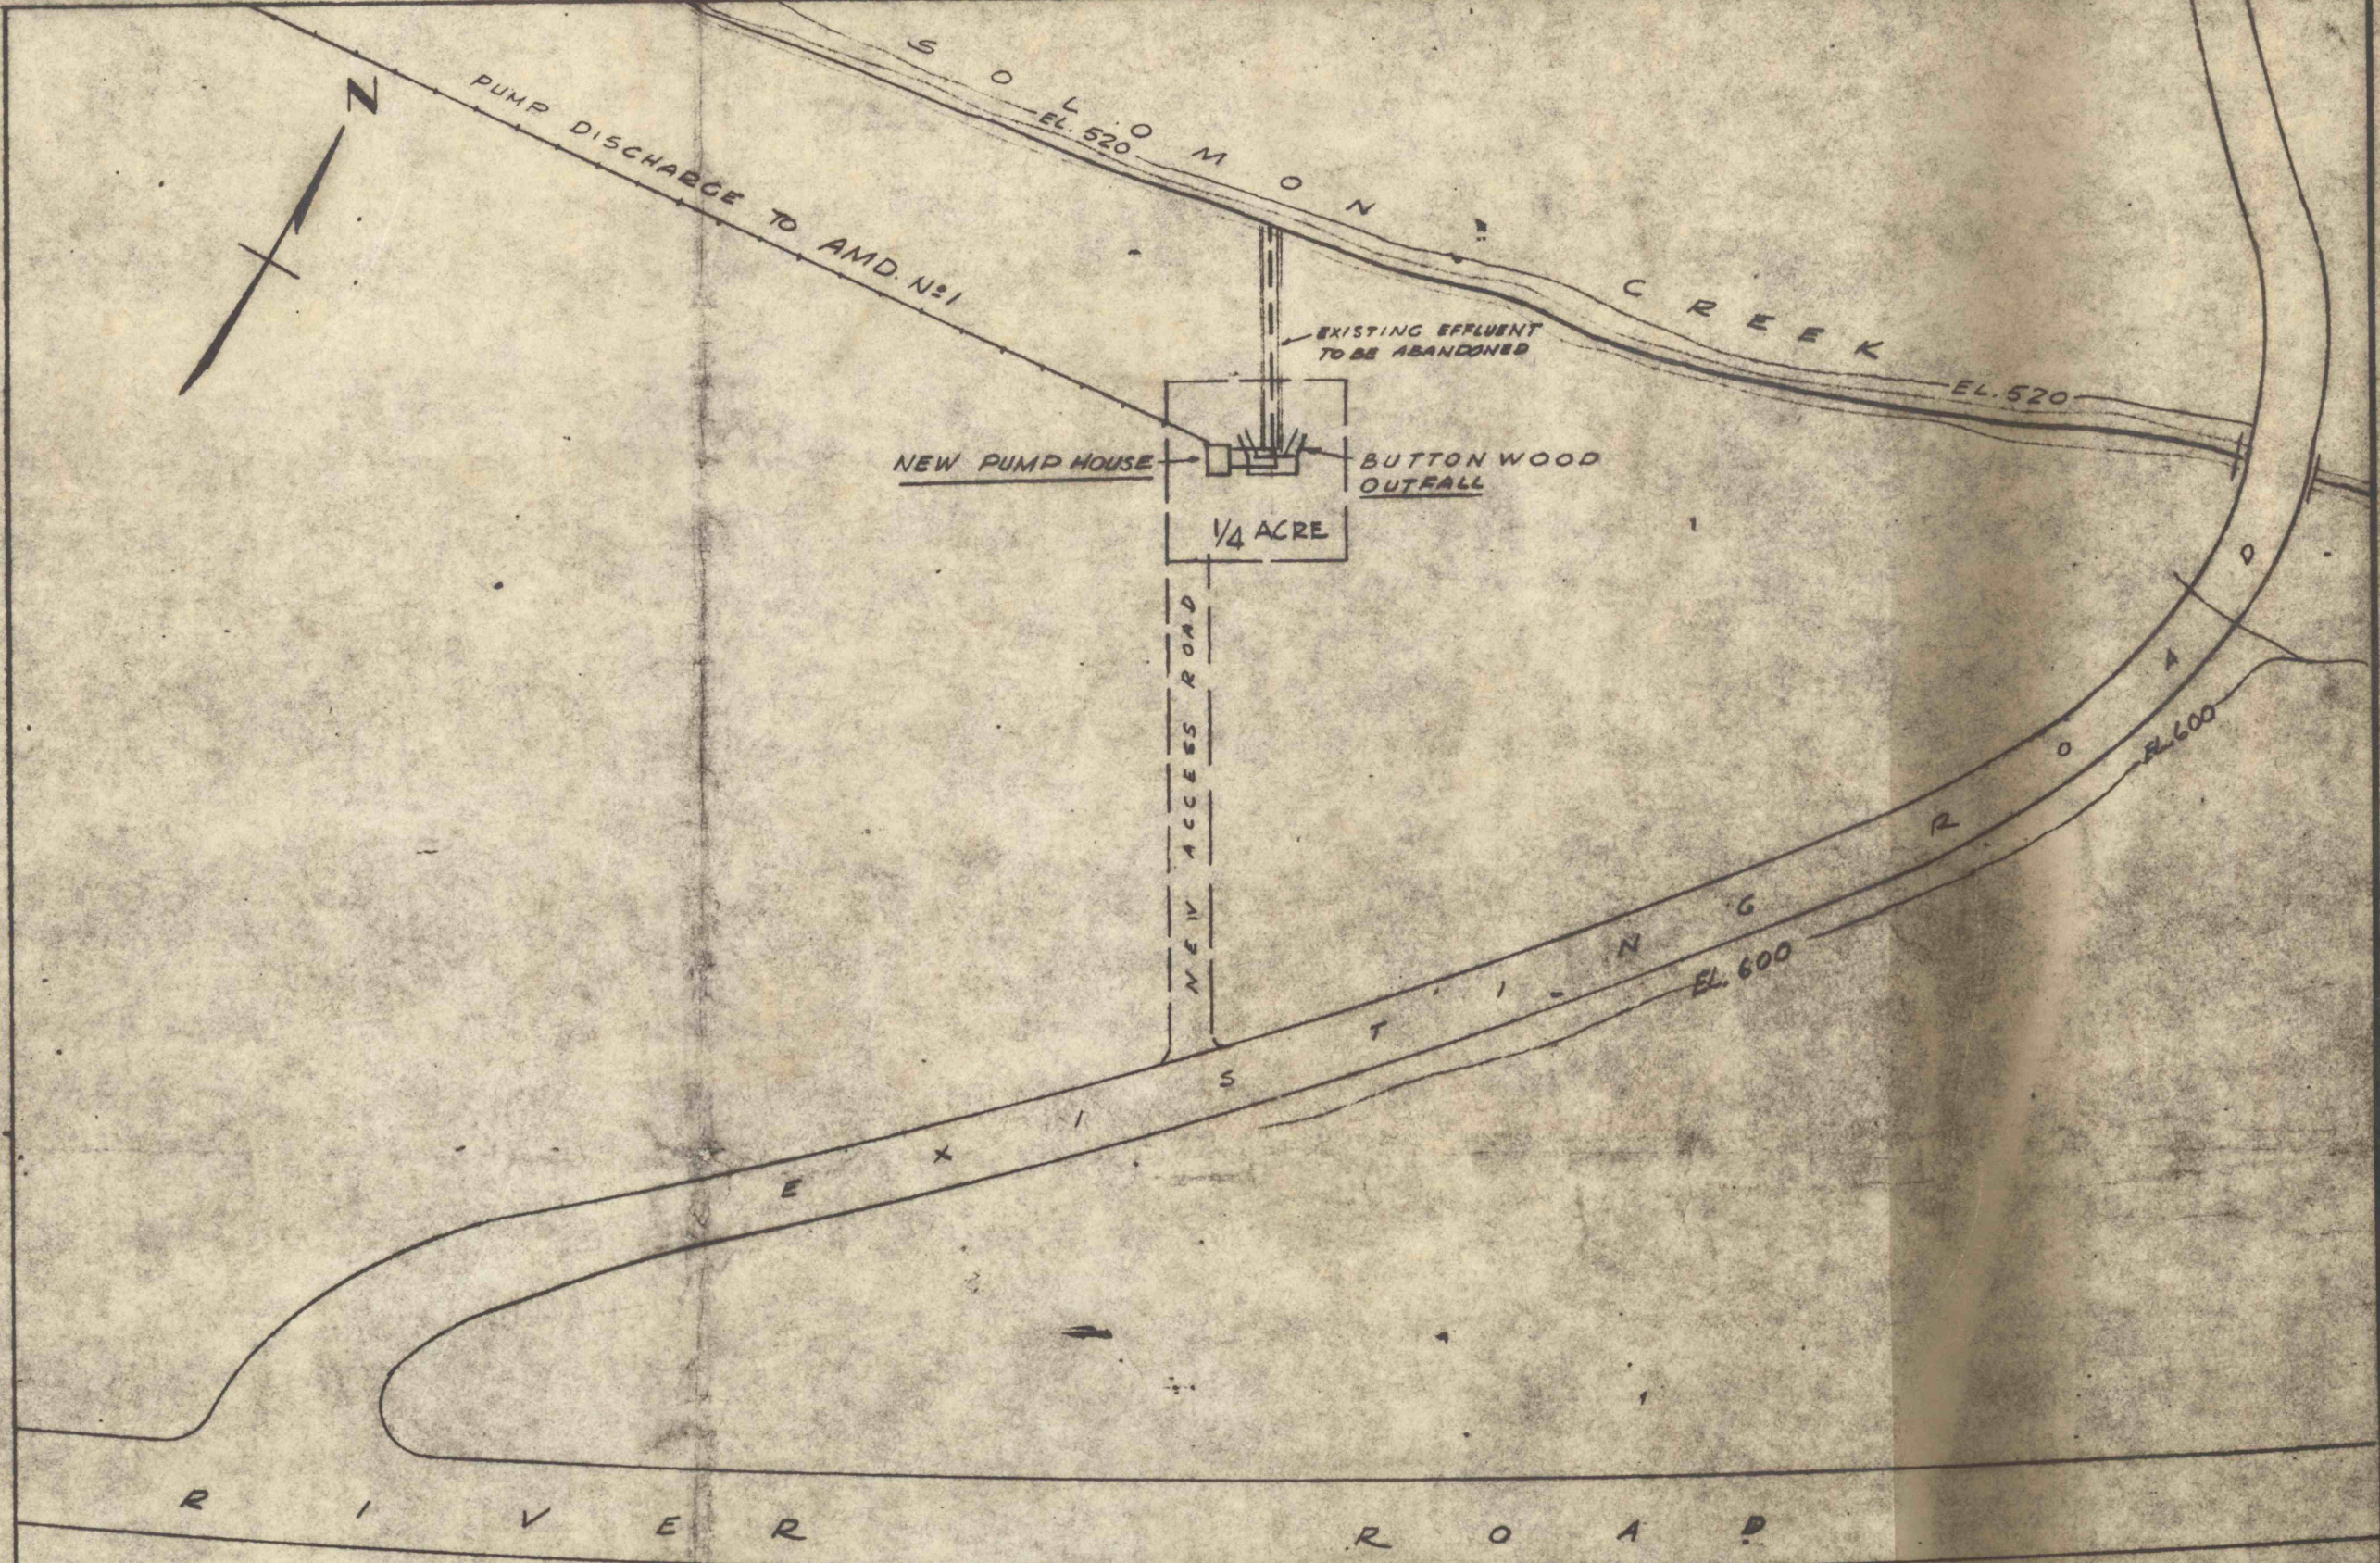

PLOT PLAN - BUTTONWOOD OUTFALL
 SCALE 1" = 100 FT.
 (Information taken from preliminary field data)

This document is the property of, and contains proprietary information owned by, the Westinghouse Electric Corporation and is made available to you under a confidential relationship and subject to the following understanding, conditions and restrictions: no permission is granted to publish, use, reproduce, transmit or disclose this document or any information contained therein without the express written permission of said department in advance.

SCALE 1" = 100 FT.

DEPT	AP	PR
M-1		
W-12		
MIE		
TOTAL		
DATE		

Westinghouse Electric Corporation
LAND REQUIREMENTS FOR AMD TREATMENT AND 30MW POWER PLANT

DRAWING NOT TO SCALE

SHEET NO. OF SHEETS

DESIGN	DATE
CHKD	DATE
L.O.	DATE
DATE	

STEAM DIVISION, LESFER, PA. U.S.A. H.T.D. 01 DEPT