


LEGEND

- PROPOSED STORM SYSTEM
- - - - EXISTING STORM SYSTEM
- ⊙ EXPLORATORY BOREHOLE

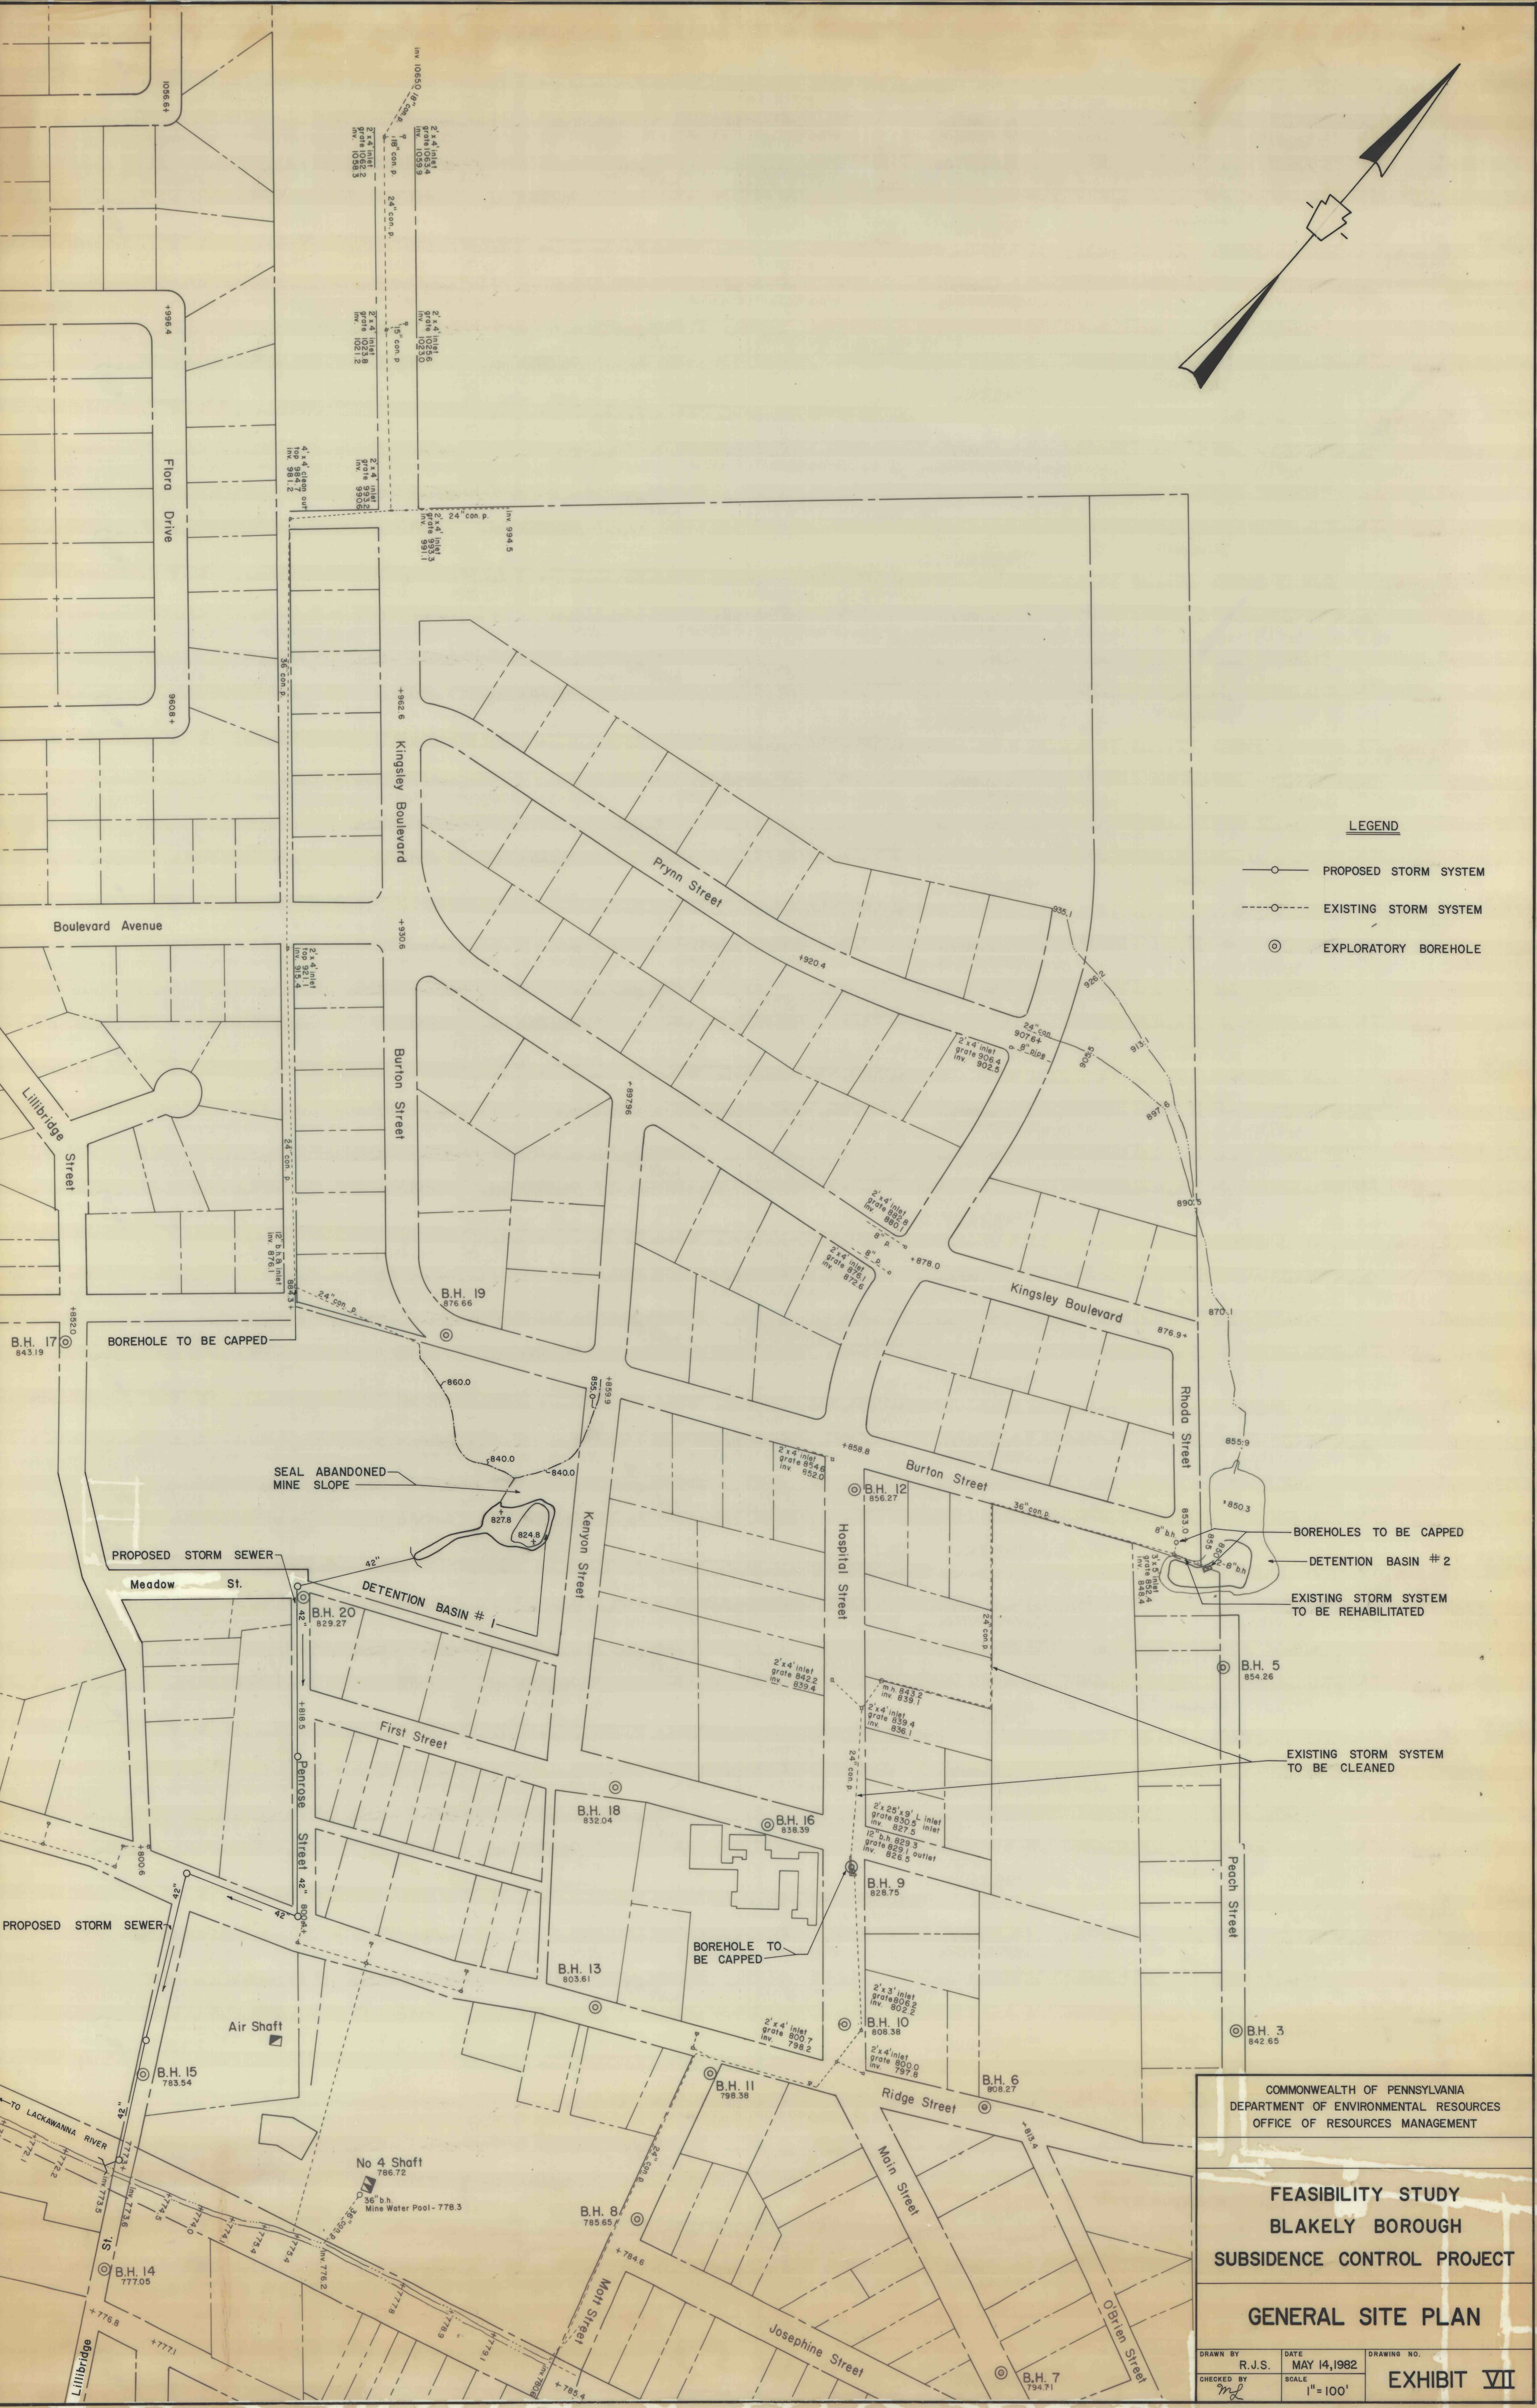

COMMONWEALTH OF PENNSYLVANIA
 DEPARTMENT OF ENVIRONMENTAL RESOURCES
 OFFICE OF RESOURCES MANAGEMENT

**FEASIBILITY STUDY
 BLAKELY BOROUGH
 SUBSIDENCE CONTROL PROJECT**

GENERAL SITE PLAN

DRAWN BY R.J.S.	DATE MAY 14, 1982	DRAWING NO.
CHECKED BY <i>md</i>	SCALE 1" = 100'	EXHIBIT VII