


- ⊙ Relocated and New Boreholes
- ⊙ Proposed Flushing Boreholes IA to I6A Inclusive
- ⊙ 38 Boreholes Drilled From Project SL 322 To Be Utilized For Monitoring And Flushing

LEGEND	
---	ELECTRIC LINE PENNA. POWER & LIGHT CO. 600 LARCH STREET SCRANTON, PENNA. 18503 TEL. (717) 342-8331
---	TELEPHONE LINE BELL TELEPHONE CO. 39 PUBLIC SQUARE WILKES-BARRE, PA. 18701 TEL. (717) 824-3513
---	SEWER LINE LACKA. RIVER BASIN SEWER AUTHORITY 101 BOULIVARD AVENUE DICKSON CITY, PA. 18519 TEL. (717) 489-7563
---	WATER LINE GAS LINE PENNA GAS & WATER CO. BRIDGE STREET SCRANTON, PENNA. 18503 TEL. (717) 342-3231

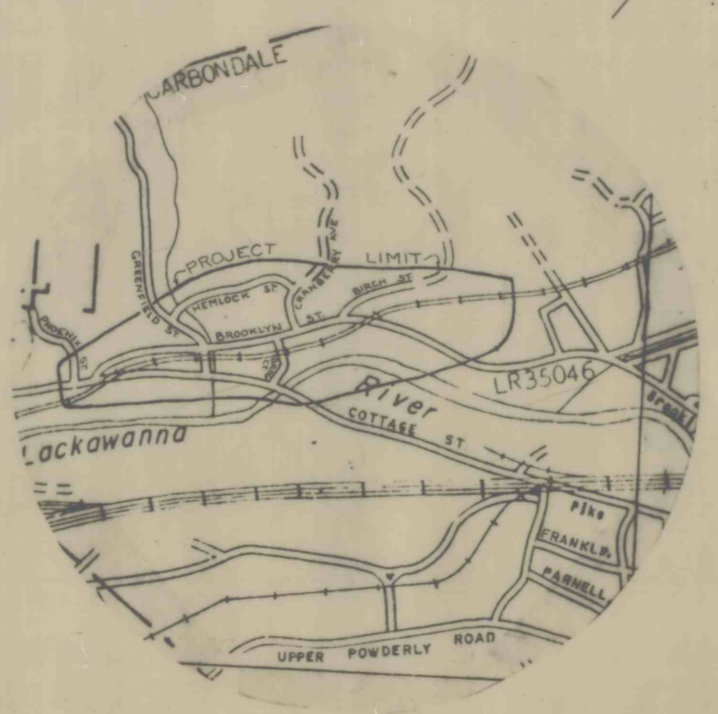

SITE PLAN  
SCALE - 1" = 1000'



LOCATION MAP  
SCALE - 1" = 9 miles

APPROVED  
*C. H. McConnell*  
C. H. McCONNELL, DEPUTY SECRETARY  
FOR RESOURCES MANAGEMENT  
DATE 4/10/78

NO.	DATE	REVISION	APPR.
SUBMITTED <i>Stephen P. Zanchek P.E.</i>			
APPROVED <i>Robert C. Sherman Jr.</i>			
APPROVED <i>Edbert E. Kyle</i>			
COMMONWEALTH OF PENNSYLVANIA DEPARTMENT OF ENVIRONMENTAL RESOURCES OFFICE OF RESOURCES MANAGEMENT			
CONTRACT NO. SL 468-101.I			
FILLING MINE VOIDS COTTAGE & BROOKLYN STREET AREA CITY OF CARBONDALE, LACK. CNTY, PA. ABANDONED POWDERLY COLLY SURFACE			
DRAWN BY	DATE	DRAWING NO.	
CHECKED BY	SCALE 1"=100'	1.1	