



- ⊙ Relocated and New Boreholes
- ⊙ Proposed Flushing Boreholes 1A to 16A Inclusive
- ⊙ 38 Boreholes Drilled From Project SL 322 To Be Utilized For Monitoring And Flushing

LEGEND

- ELECTRIC LINE
PENNA. POWER & LIGHT CO.
600 LARCH STREET
SCRANTON, PENNA. 18503
TEL. (717) 342-8331
- TELEPHONE LINE
BELL TELEPHONE CO.
39 PUBLIC SQUARE
WILKES-BARRE, PA. 18701
TEL. (717) 824-3513
- SEWER LINE
LACKA. RIVER BASIN
SEWER AUTHORITY
101 BOULIVARD AVENUE
DICKSON CITY, PA.
18519
TEL. (717) 489-7563
- WATER LINE
GAS LINE
PENNA GAS & WATER CO.
BRIDGE STREET
SCRANTON, PENNA. 18503
TEL. (717) 342-3231

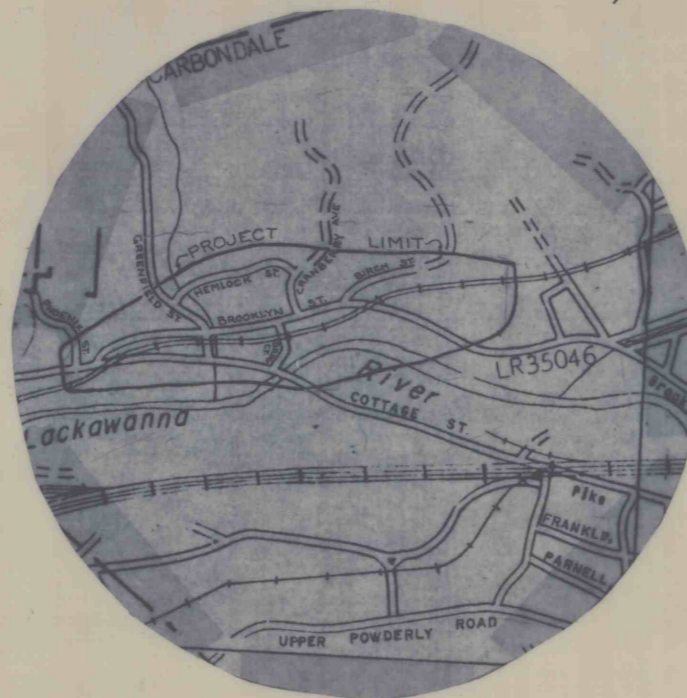

SITE PLAN
SCALE - 1" = 1000'

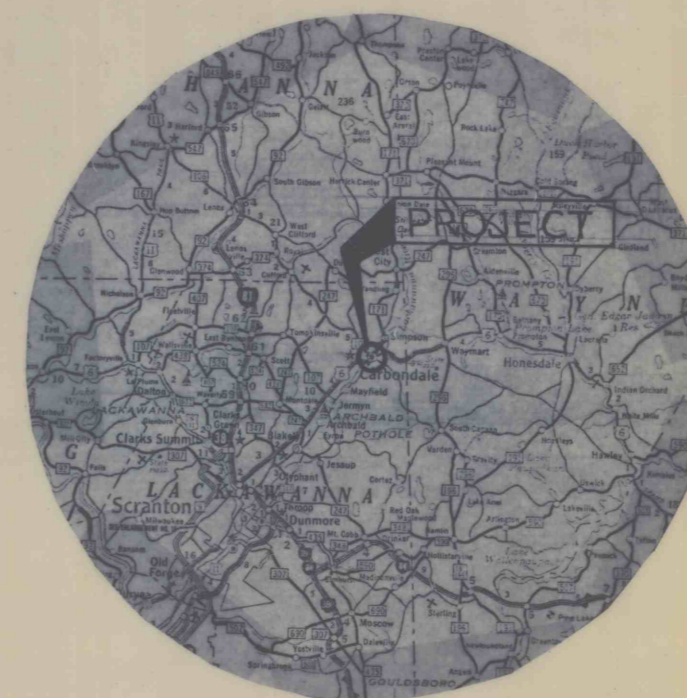

LOCATION MAP
SCALE - 1" = 9 miles

1.	1/11/80	AS BUILT PLANS	⊙	
NO.	DATE	REVISION	APPR.	
SUBMITTED				
APPROVED				
APPROVED				
COMMONWEALTH OF PENNSYLVANIA DEPARTMENT OF ENVIRONMENTAL RESOURCES OFFICE OF RESOURCES MANAGEMENT				
SL 468				
FILLING MINE VOIDS				
COTTAGE & BROOKLYN STREET AREA CITY OF CARBONDALE, LACK. CNTY, PA. ABANDONED POWDERLY COLLY SURFACE				
DRAWN BY	DATE	DRAWING NO.		
CHECKED BY	SCALE 1"=100'	1.1		