


Match Line to Sheet I.I "B"




LEGEND	
	ELECTRIC LINE PENNA. POWER & LIGHT CO. 600 LARCH STREET SCRANTON, PENNA. 18503 TEL. (717) 342-8331
	TELEPHONE LINE BELL TELEPHONE CO. 39 PUBLIC SQUARE WILKES-BARRE, PA. 18701 TEL. (717) 824-3513
	SEWER LINE LACKAWANNA RIVER BASIN SEWER AUTHORITY 101 BOULIVARD AVE. DICKSON CITY, PA. 18519 TEL. (717) 489-7563
	WATER LINE GAS LINE PENNA GAS & WATER CO. BRIDGE STREET SCRANTON, PENNA. 18503 TEL. (717) 342-3231
ASSIGNED PG & W SERIAL NO NM-105	

PROJECT AREA

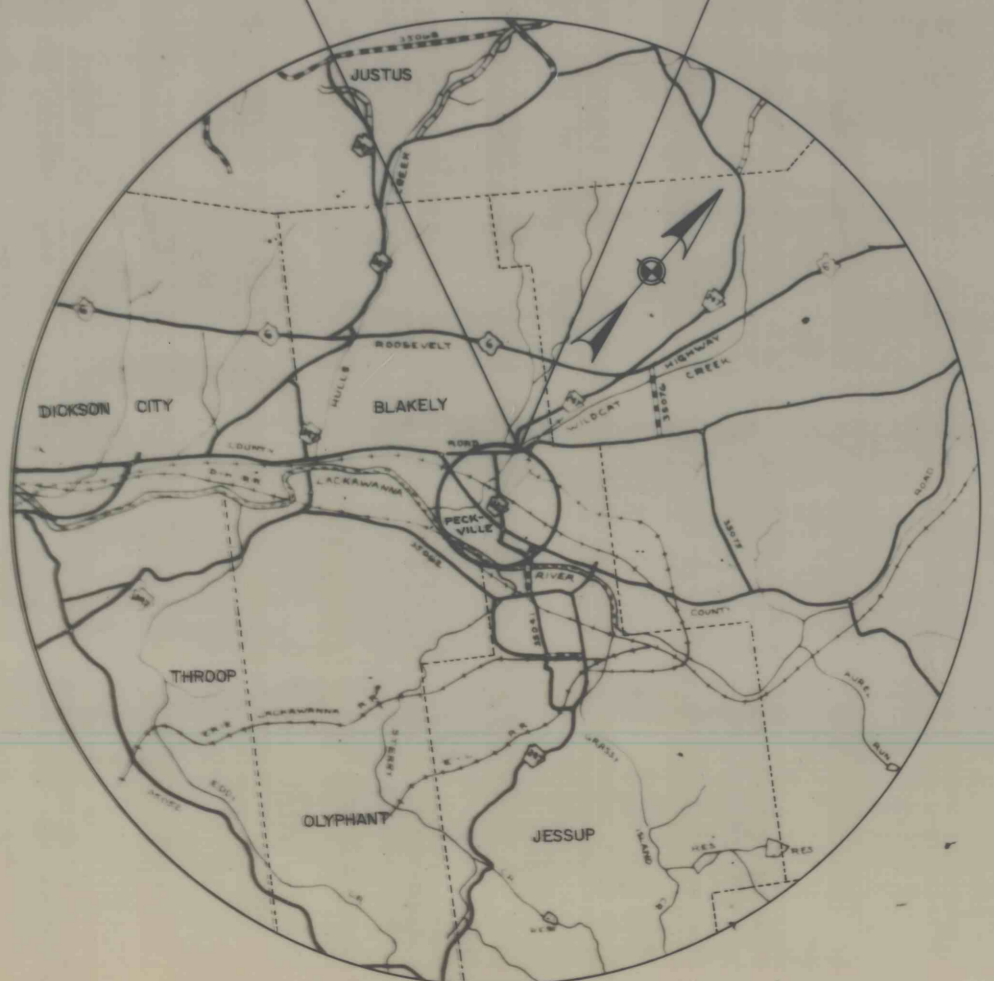

LOCATION MAP

PROJECT AREA

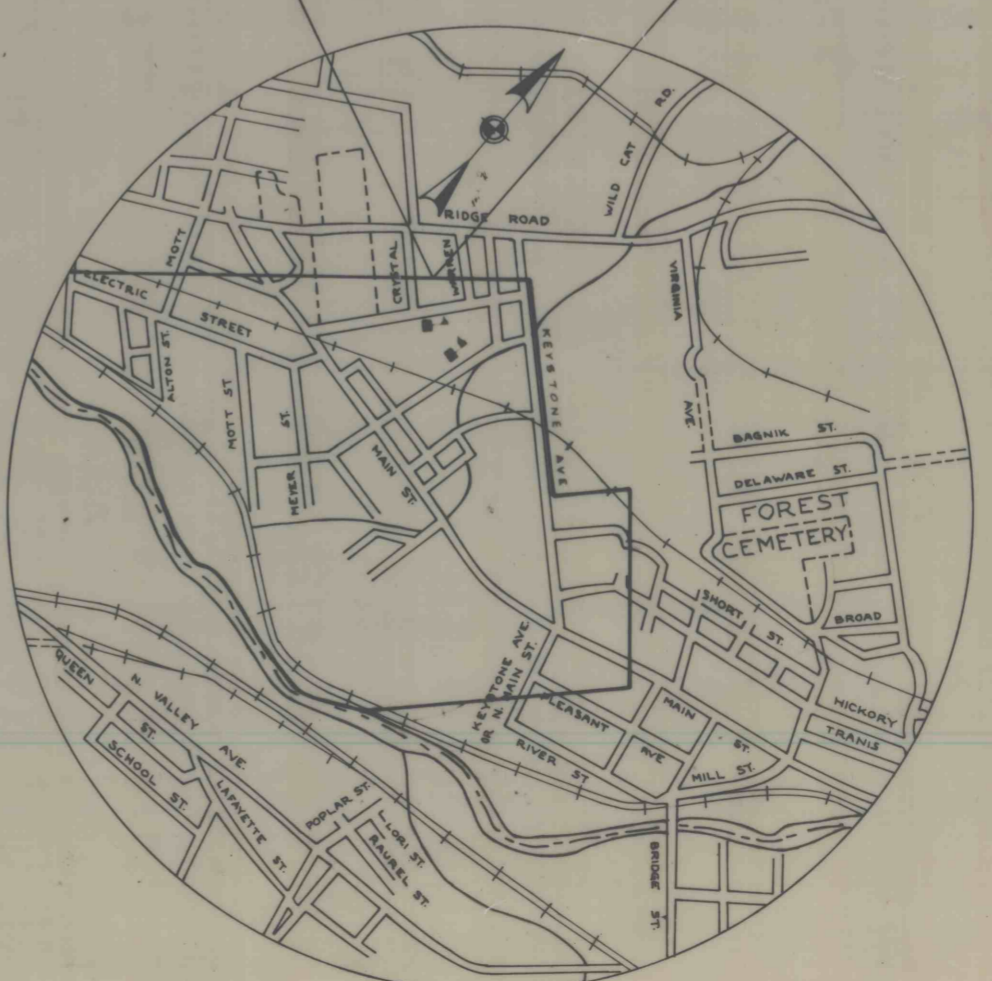

SITE PLAN

NO	DATE	REVISION	APPR

SUBMITTED *Stephen P. Zanchek P.E.*
 APPROVED _____
 APPROVED _____



COMMONWEALTH OF PENNSYLVANIA
 DEPARTMENT OF ENVIRONMENTAL RESOURCES
 OFFICE OF RESOURCES MANAGEMENT

PROJECT NO. SL-463-101.1
FILLING MINE VOIDS

ACADEMY, LACKAWANNA RIVER, &
 KEYSTONE AVENUE — BLAKELY BORO
 LACKAWANNA COUNTY PENNSYLVANIA

ABANDONED TEMPLE COAL CO.
 LACKAWANNA COLLIERY
 SURFACE

DRAWN BY	DATE	DRAWING NO
CHECKED BY	JAN. 78	I.I "A"
	SCALE	1"=100'