


**SYMBOLS**  
 □ 220V FLOOD LIGHT-MODULASE  
 □ DOUBLE 110V RECEPTACLE  
 ○ 110 250W BULB

CONDUIT	SERVICE	SIZE	CONDUCTORS
A	MOTOR LEADS	3"	(3) #30 NY
B	CONTROLS	3"	(5) #12 FOR HP SWITCH (5) #12 FOR OIL PUMP (5) #12 FOR CONTROLS
C	110/220V PANEL	2"	(4) #1 (4 WIRE 208Y)
D	O.S. PUMP	3/4"	(3) #12
E	O.L. PUMP	3/4"	(3) #12
F	PROTEMP BEZEL	3/4"	(2) #12
G	TOP "	3/4"	(4) #12
H	SPACE HEATER	3/4"	(3) #12
J	PRESSURE SW	1/2"	(2) #12
K	LOW WATER SW	1"	(5) #12
L	SPARK BOND SW	1/2"	(2) #12 (LOCATE IN FIELD)*
M	110V LIGHTS	1/2"	(4) #8

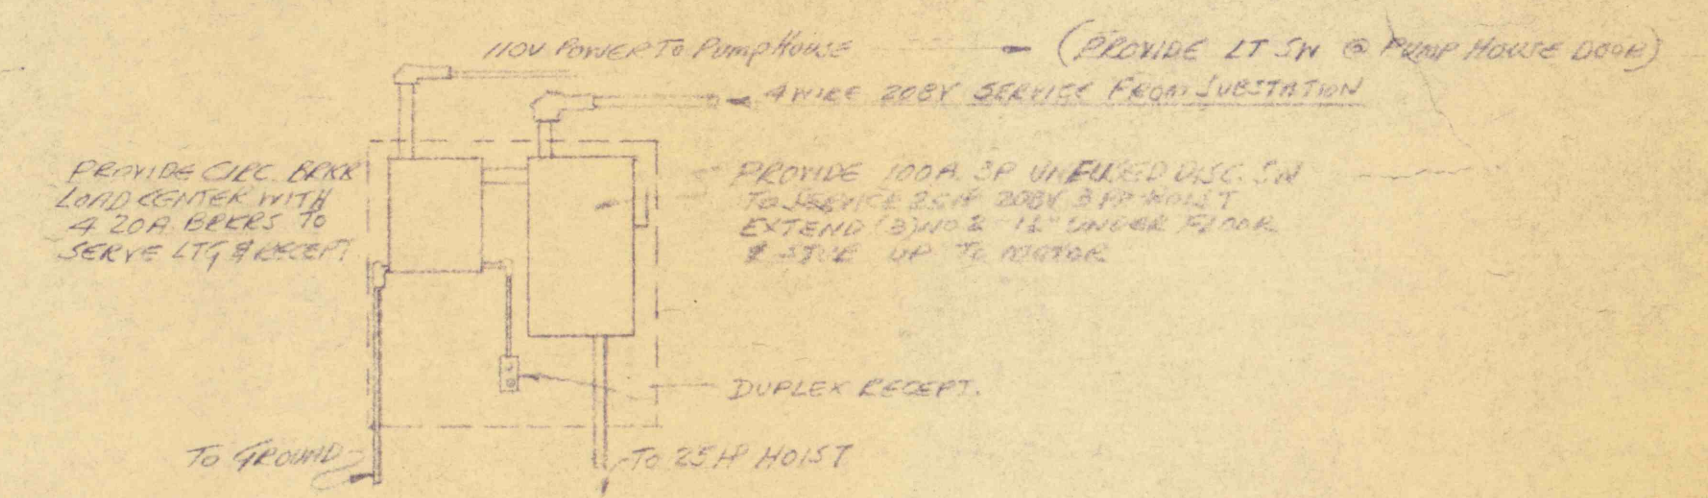

HOIST HOUSE BACK BOARD

\*X - IF CONDUIT (2) 3/4" W/ 2 #12 FOR TOWER LAMP THIS CONDUIT TO BE HEAVILY COATED WITH ANTI-RUST BEFORE BEING BURIED - INSTALL IN RAINY GRADE

SECTION A-A

ELECTRICAL LAYOUT  
 INSTALLATION OF 300 HP DEEPWELL PUMP  
 FORGE SHOPE GLEN HILL PROPERTY - NEWBURGH TN  
 JUSQUEHANNIA ANTHRACITE LNS  
 SCALE 3/4" = 1'-0"  
 AUGUST 29, 1969