
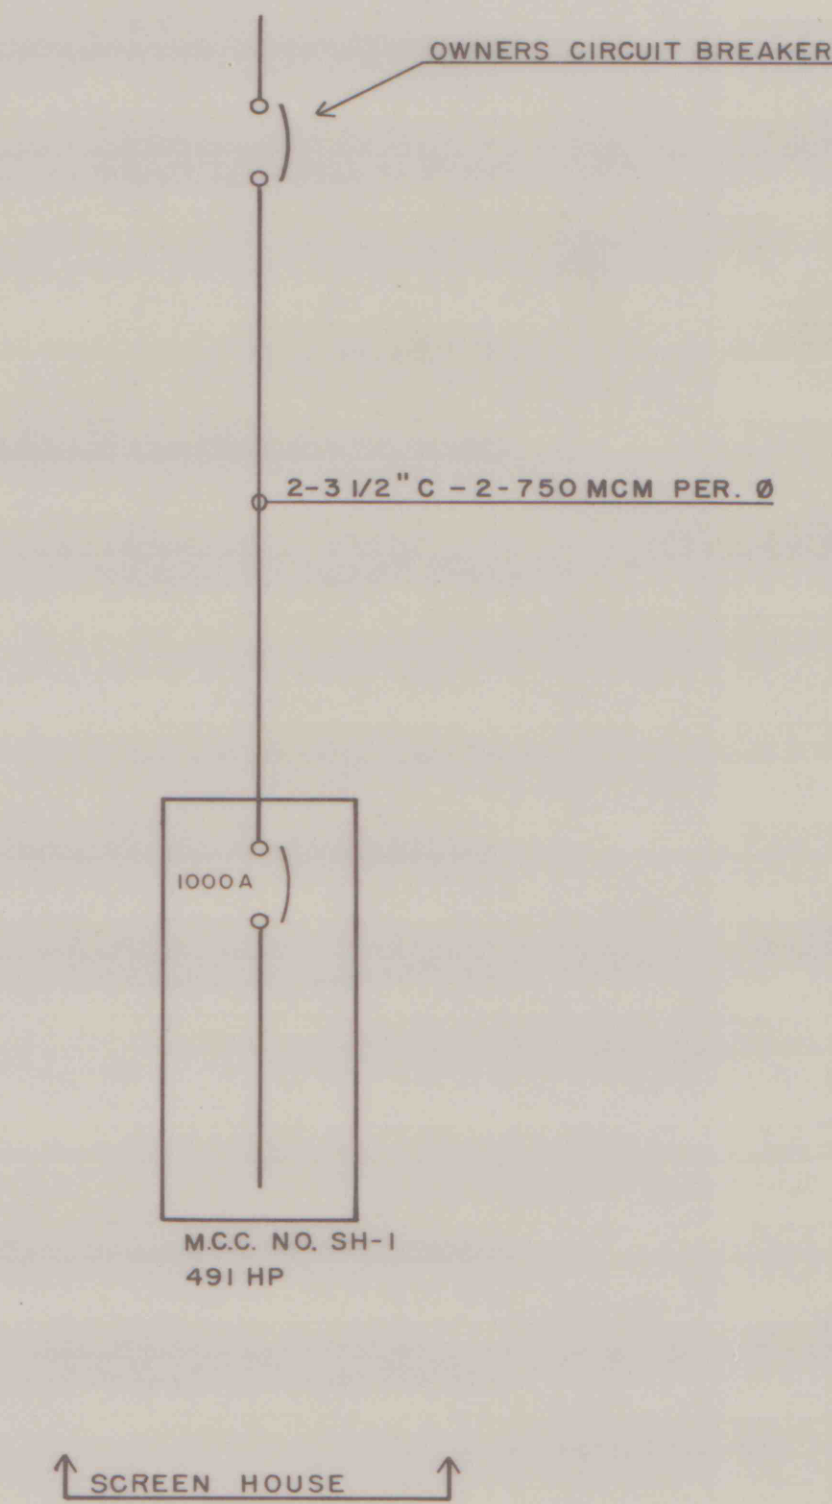


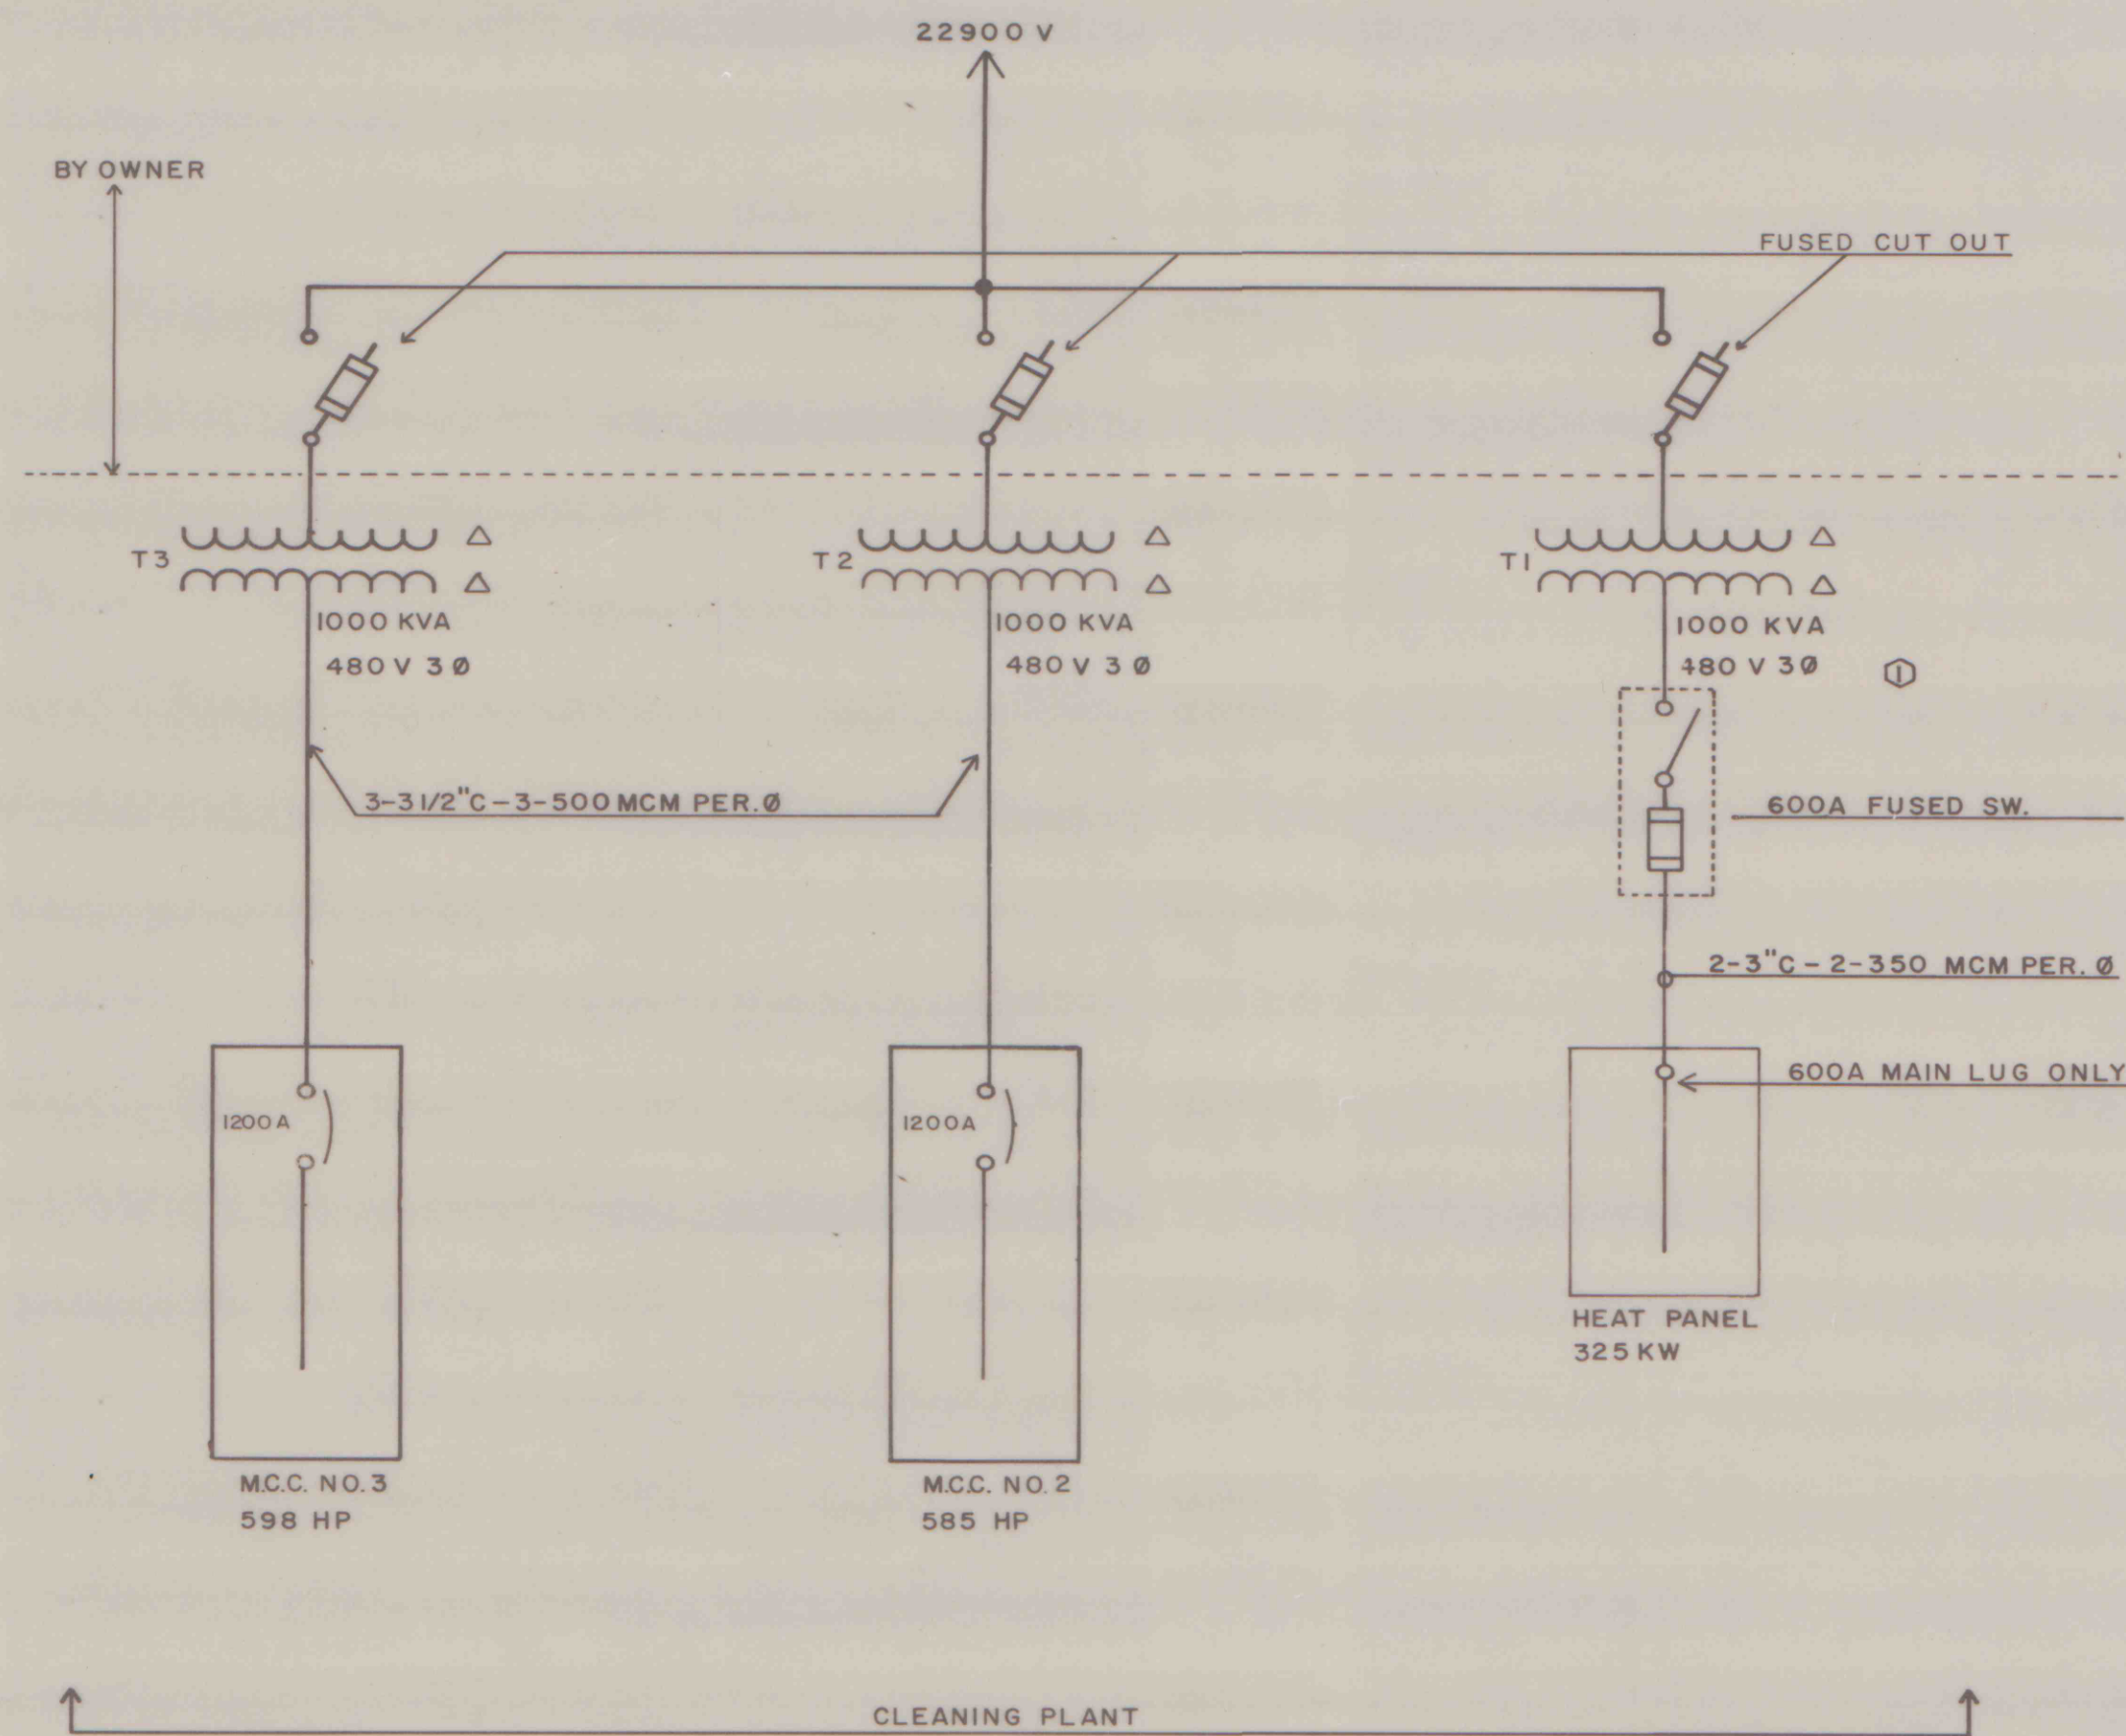

		CHANGED T1 TO 1000 KVA & UPDATE		①	3/22/82	JK
DWG. NO.	REFERENCE			NO.	DATE	BY
				REVISIONS		
BLAIR ELECTRIC SERVICE CO.						
BELLWOOD, PENNSYLVANIA						
R & P COAL CO.—KEYSTONE PLANT						
POWER ONE-LINE DIAGRAMS						
DRAWN JK		DATE 12/16/81		ORDER NO. W 7478		
CHECKED		DATE		SCALE 1		
APPROVED		DATE		DWG. NO. E-1		