
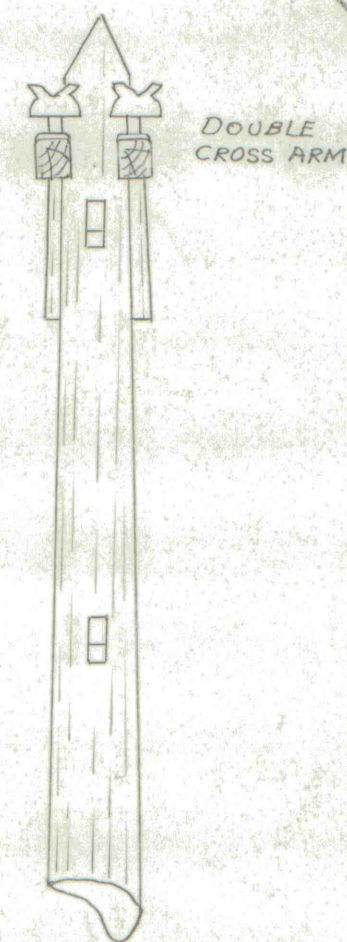
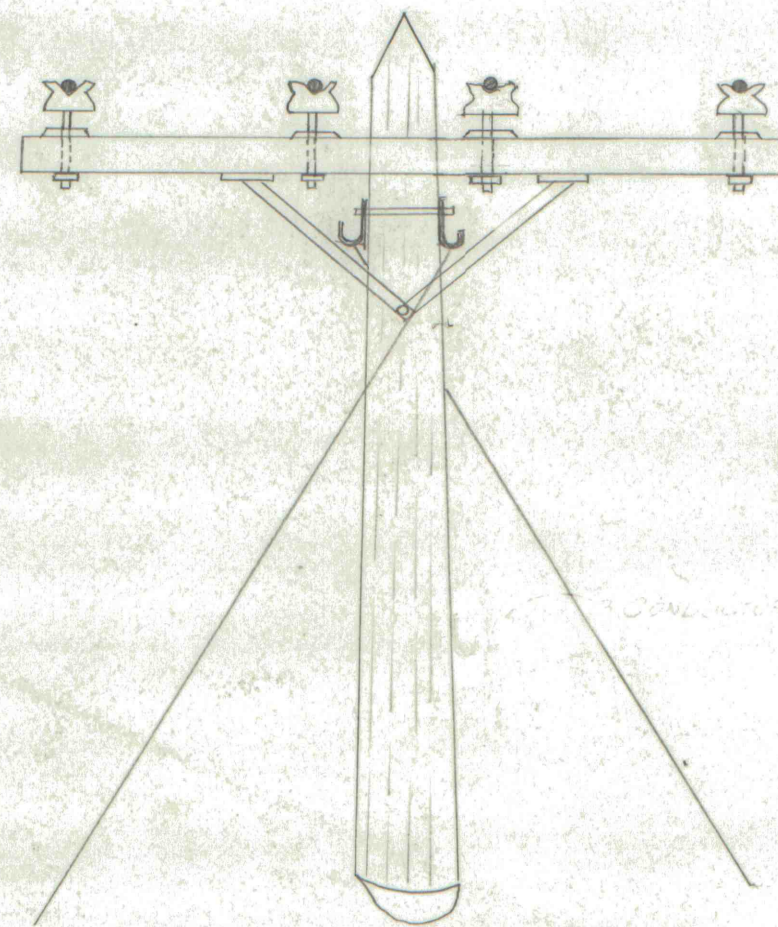


9599-67

SECTION A-A
NOT TO SCALE

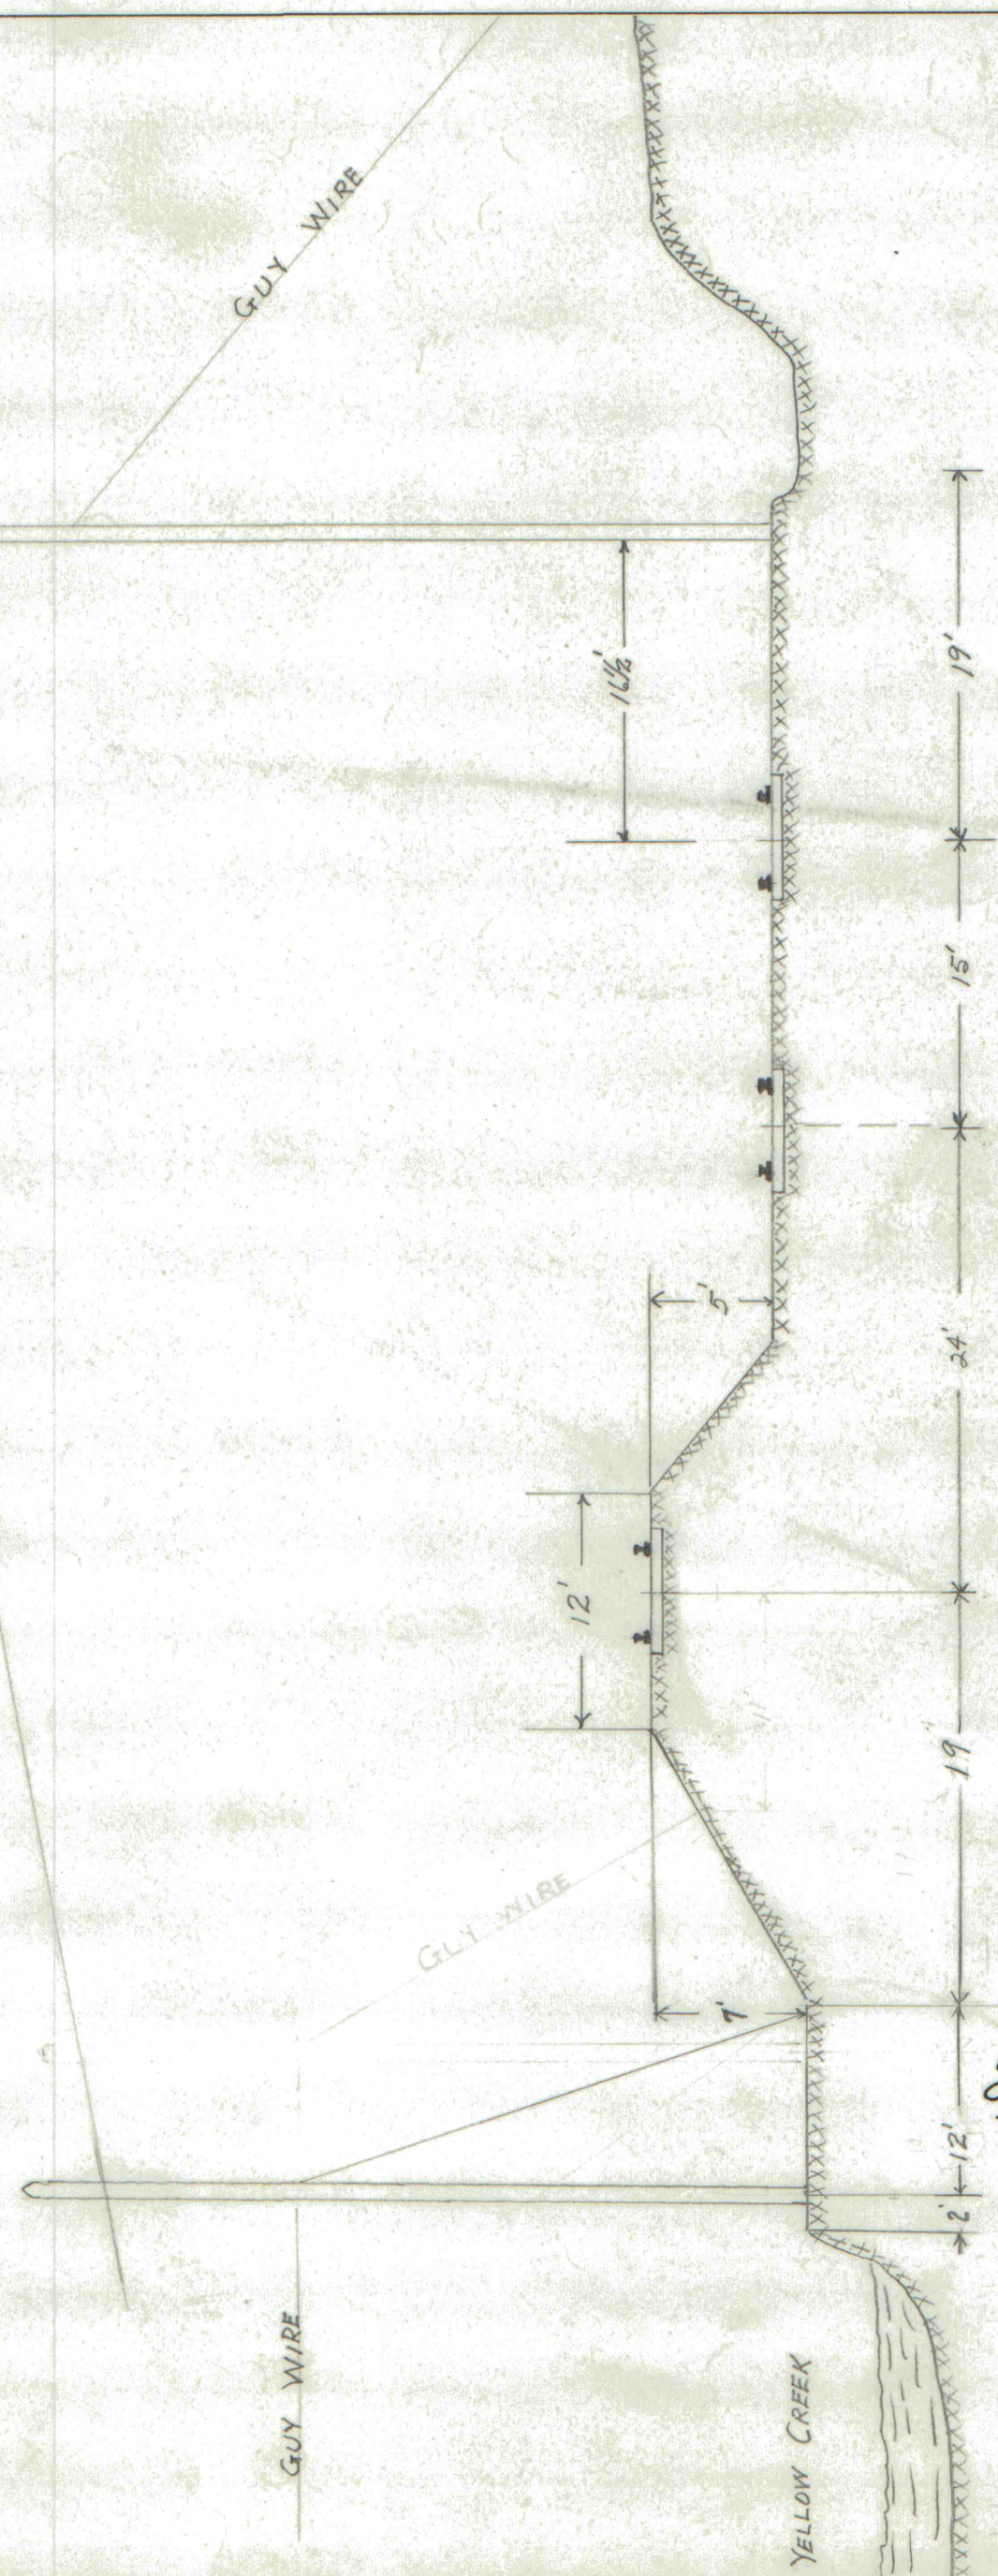

SPECIFICATIONS

POTENTIAL
CONDUCTORS
TIES

440 VOLTS
4/0 COPPER
COPPER

ROCHESTER & PITTSBURGH COAL CO.


PLAN AND PROFILE
OF

PROPOSED TRANSMISSION LINE CROSSING.
P.R.R. - INDIANA BR.
CENTER TWP. INDIANA CO.

SCALE: AS SHOWN

AUGUST 19, 1964

PLAN
PROPOSED
TRANSMISSION LINE
CROSSING
SCALE 1" = 100'

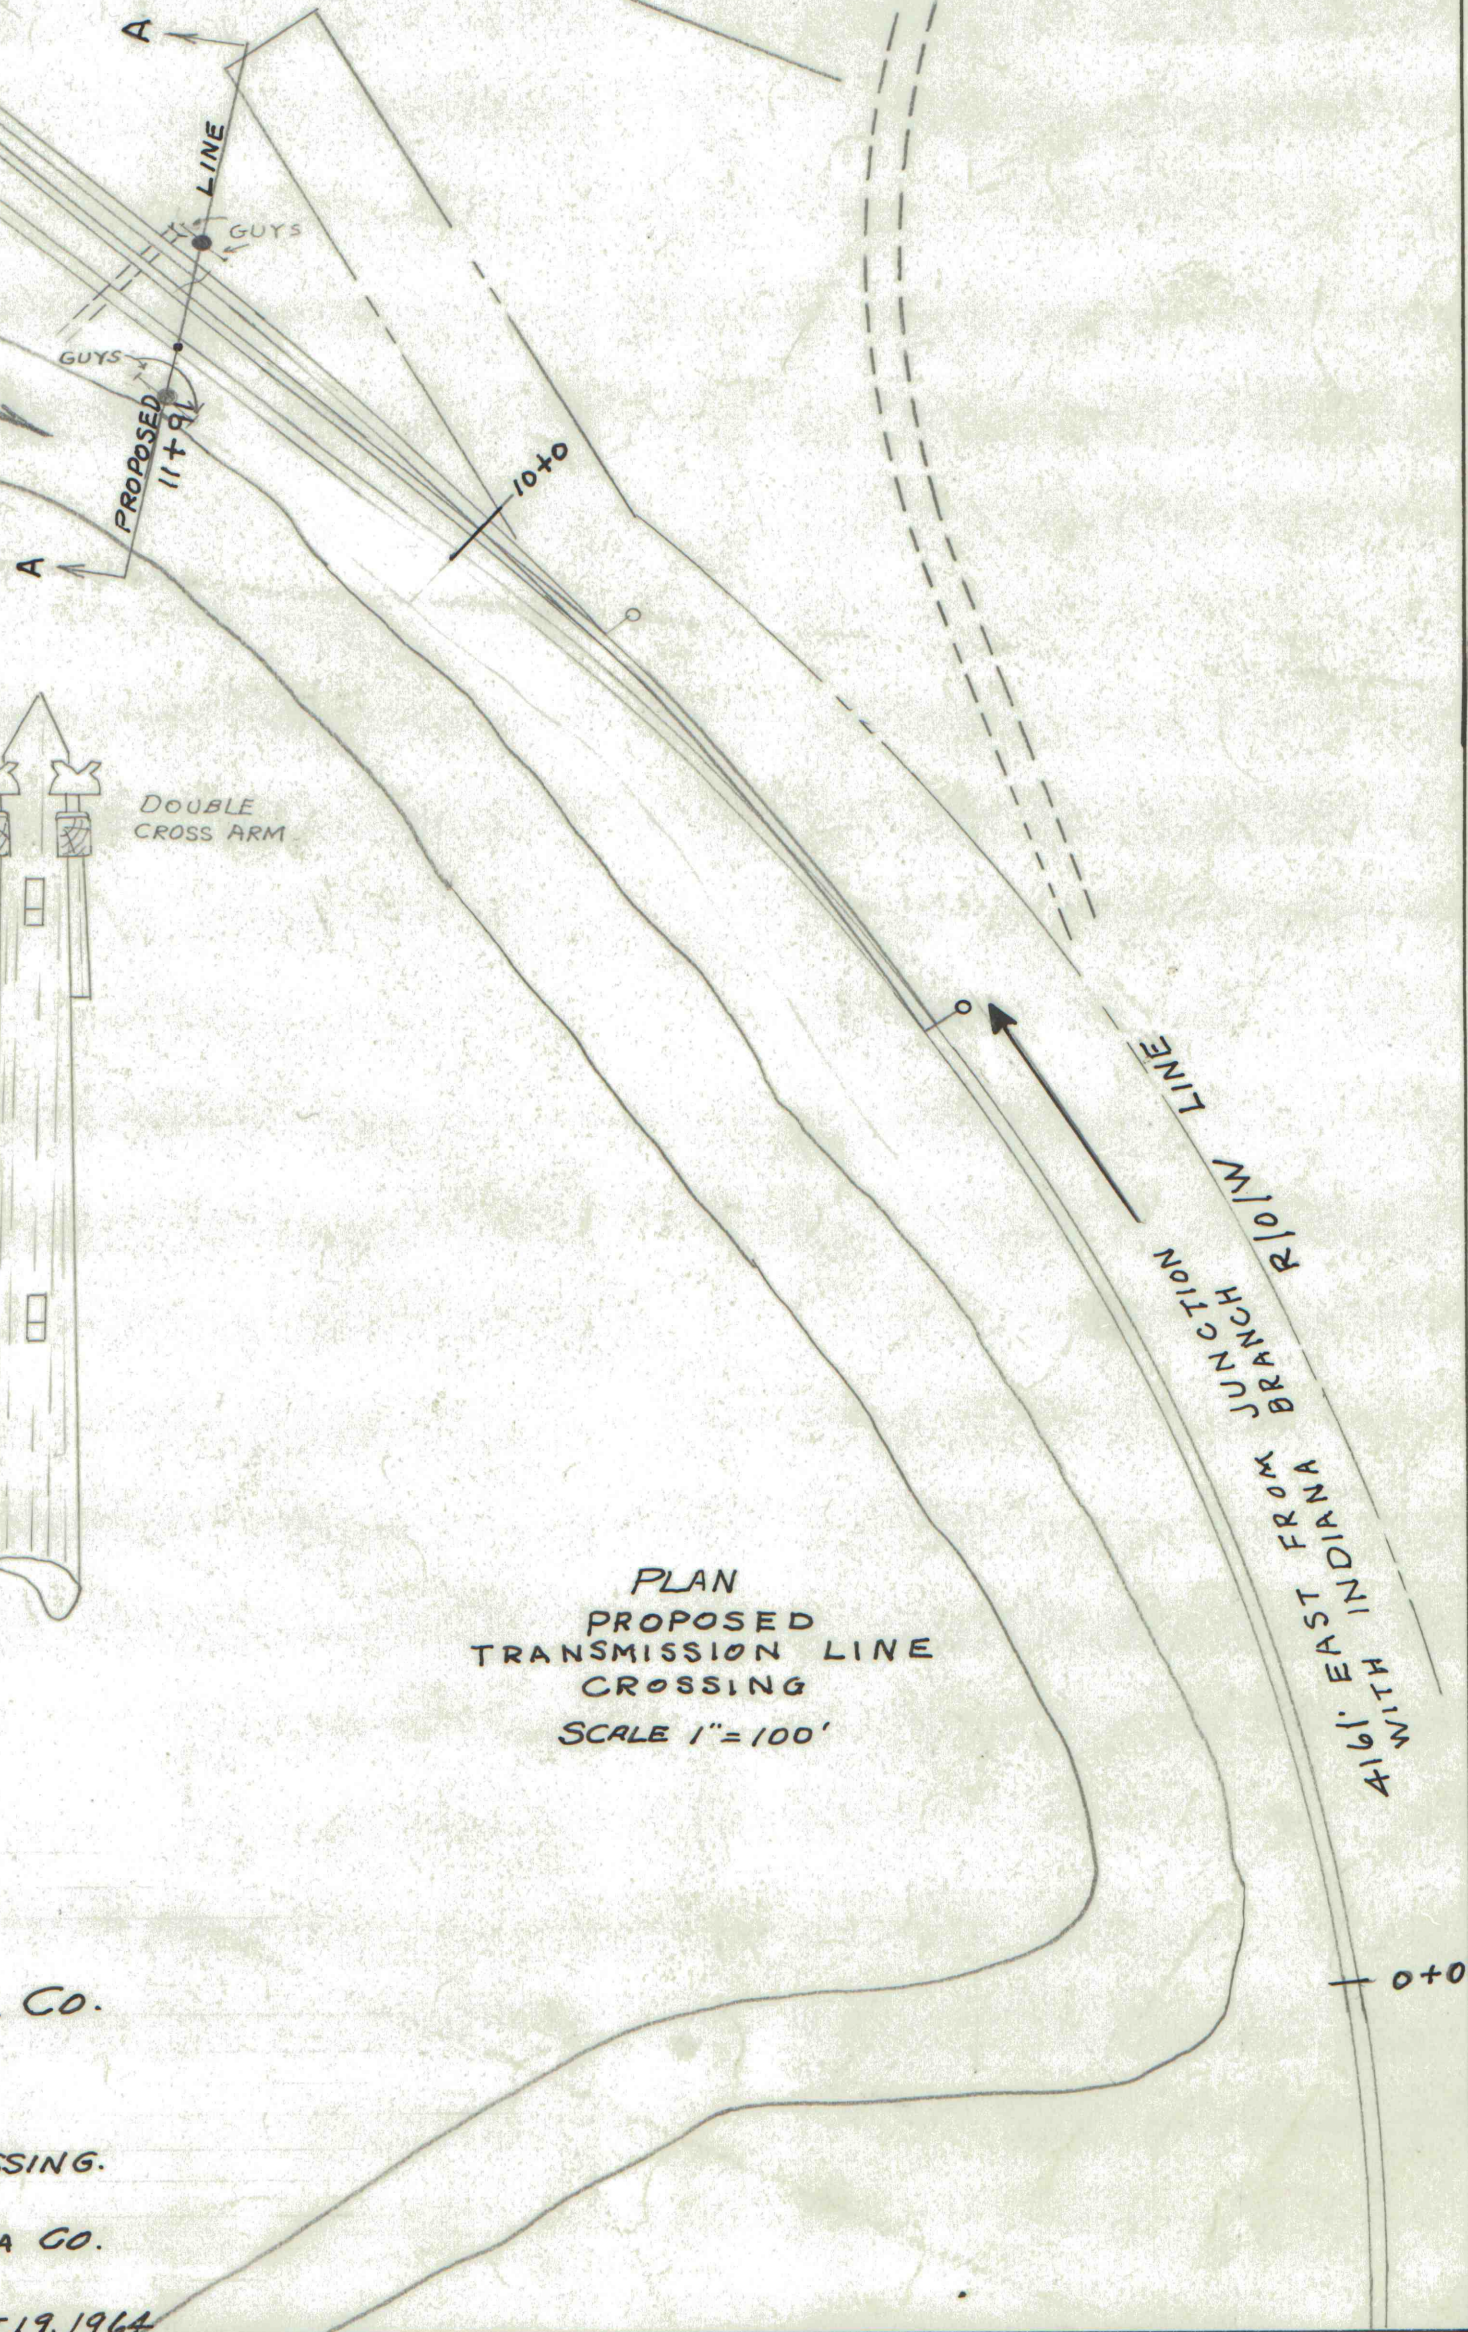

9599-67