
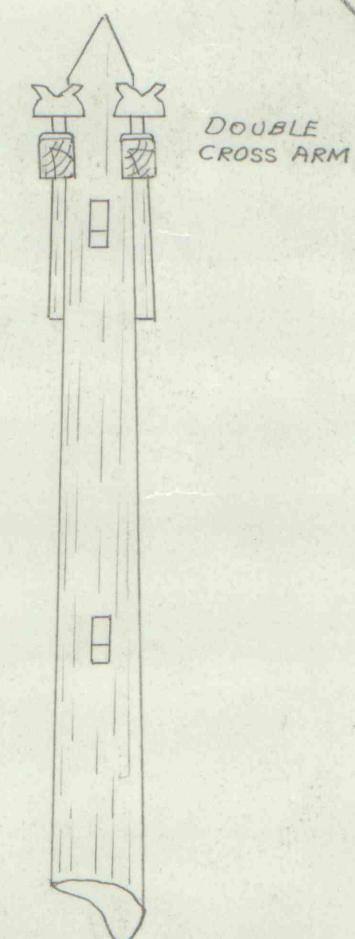
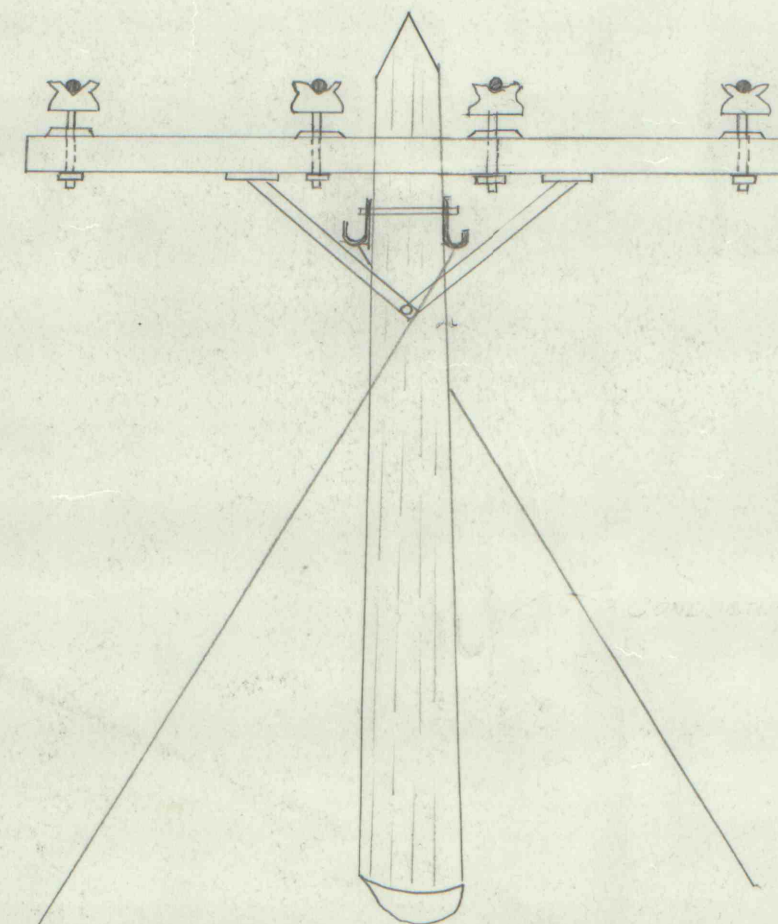


9599-67

SECTION A-A
NOT TO SCALE

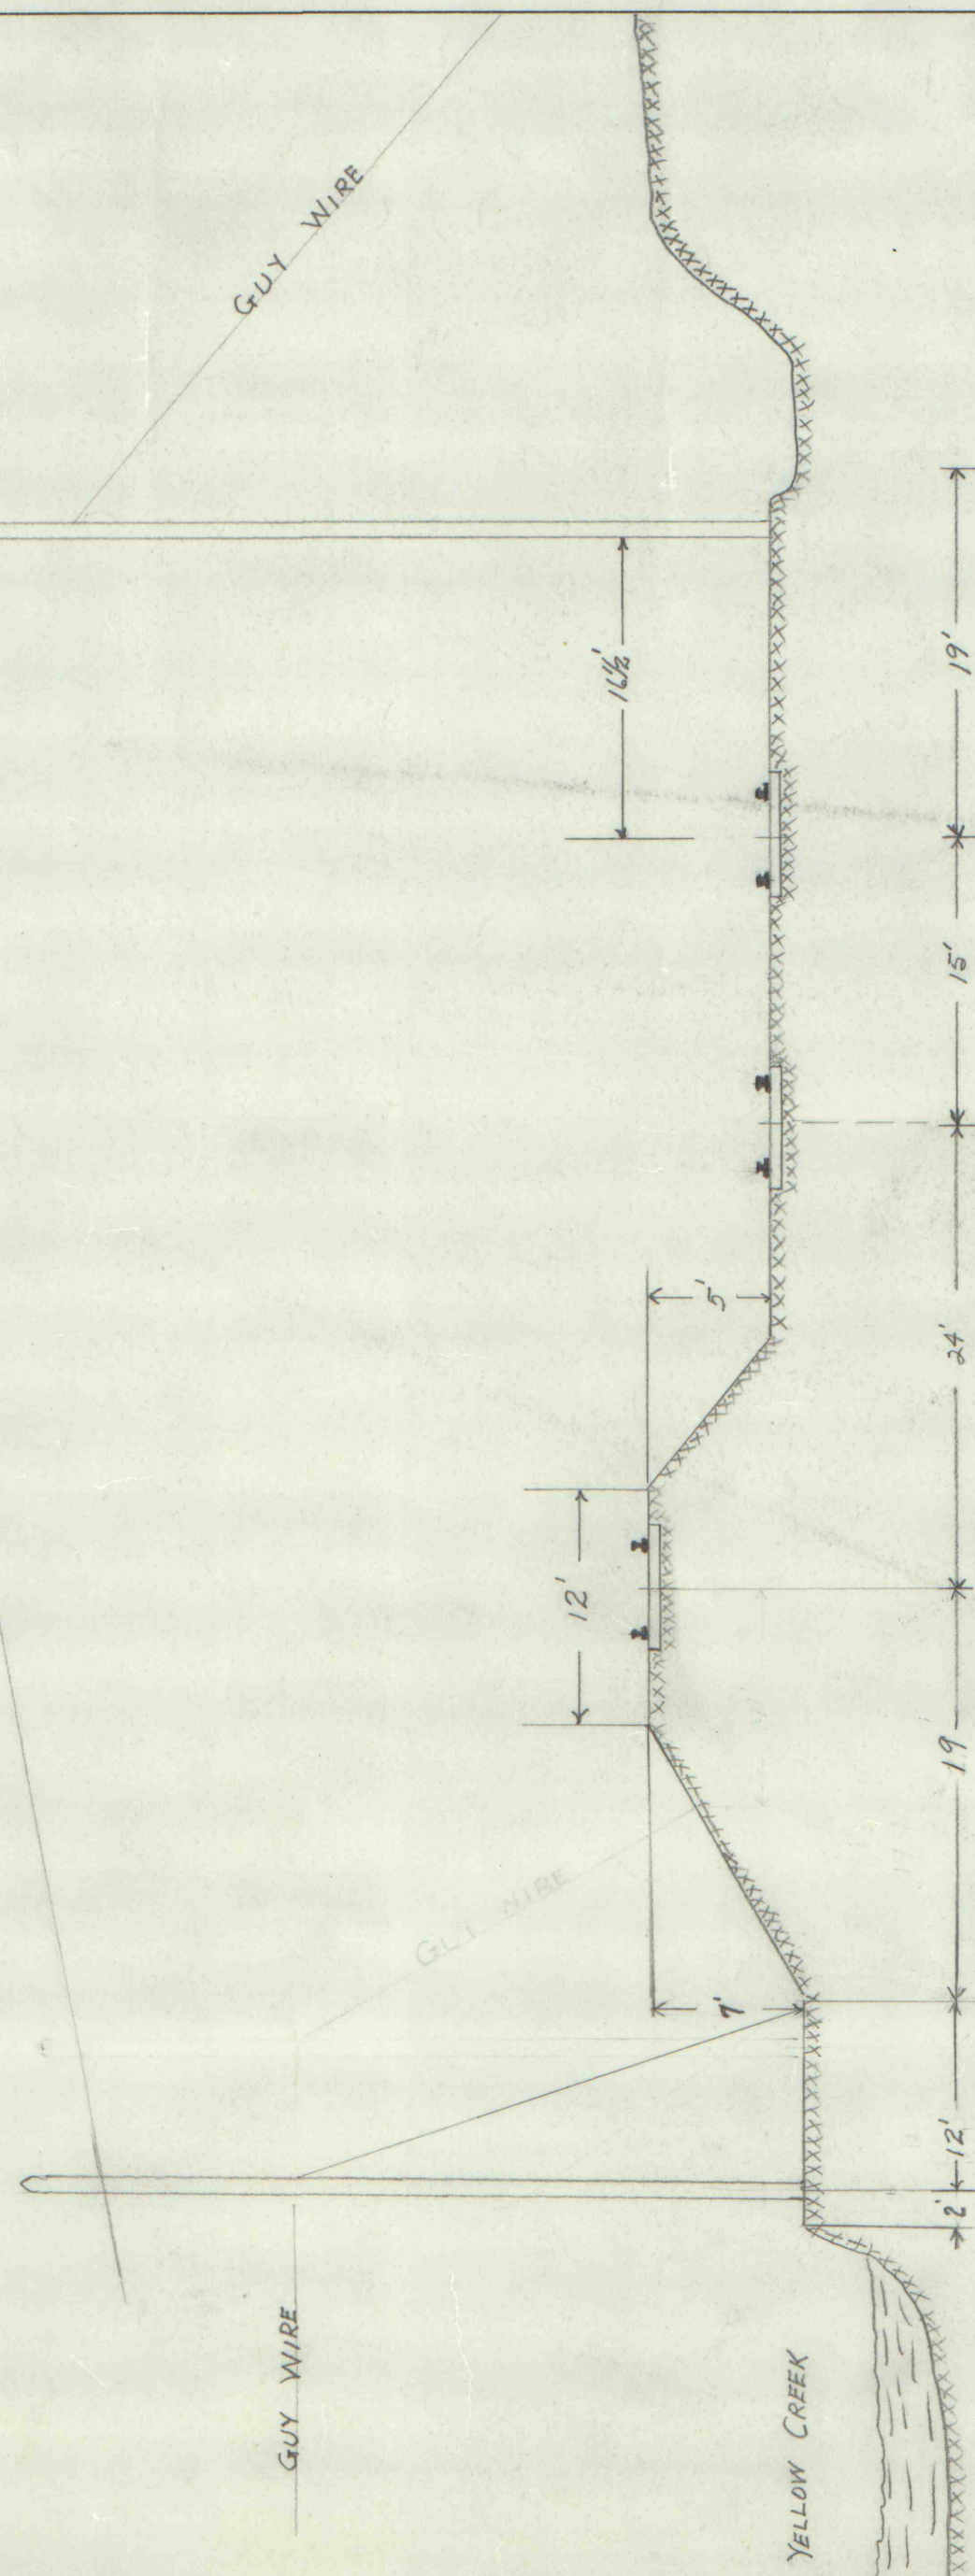


SPECIFICATIONS

POTENTIAL CONDUCTORS TIES
440 VOLTS
4/0 COPPER
COPPER

ROCHESTER & PITTSBURGH COAL CO.
PLAN AND PROFILE
OF
PROPOSED TRANSMISSION LINE CROSSING.
P.R.R. - INDIANA BR.
CENTER TWP. INDIANA CO.
SCALE: AS SHOWN
AUGUST 19, 1964

PLAN
PROPOSED
TRANSMISSION LINE
CROSSING
SCALE 1" = 100'

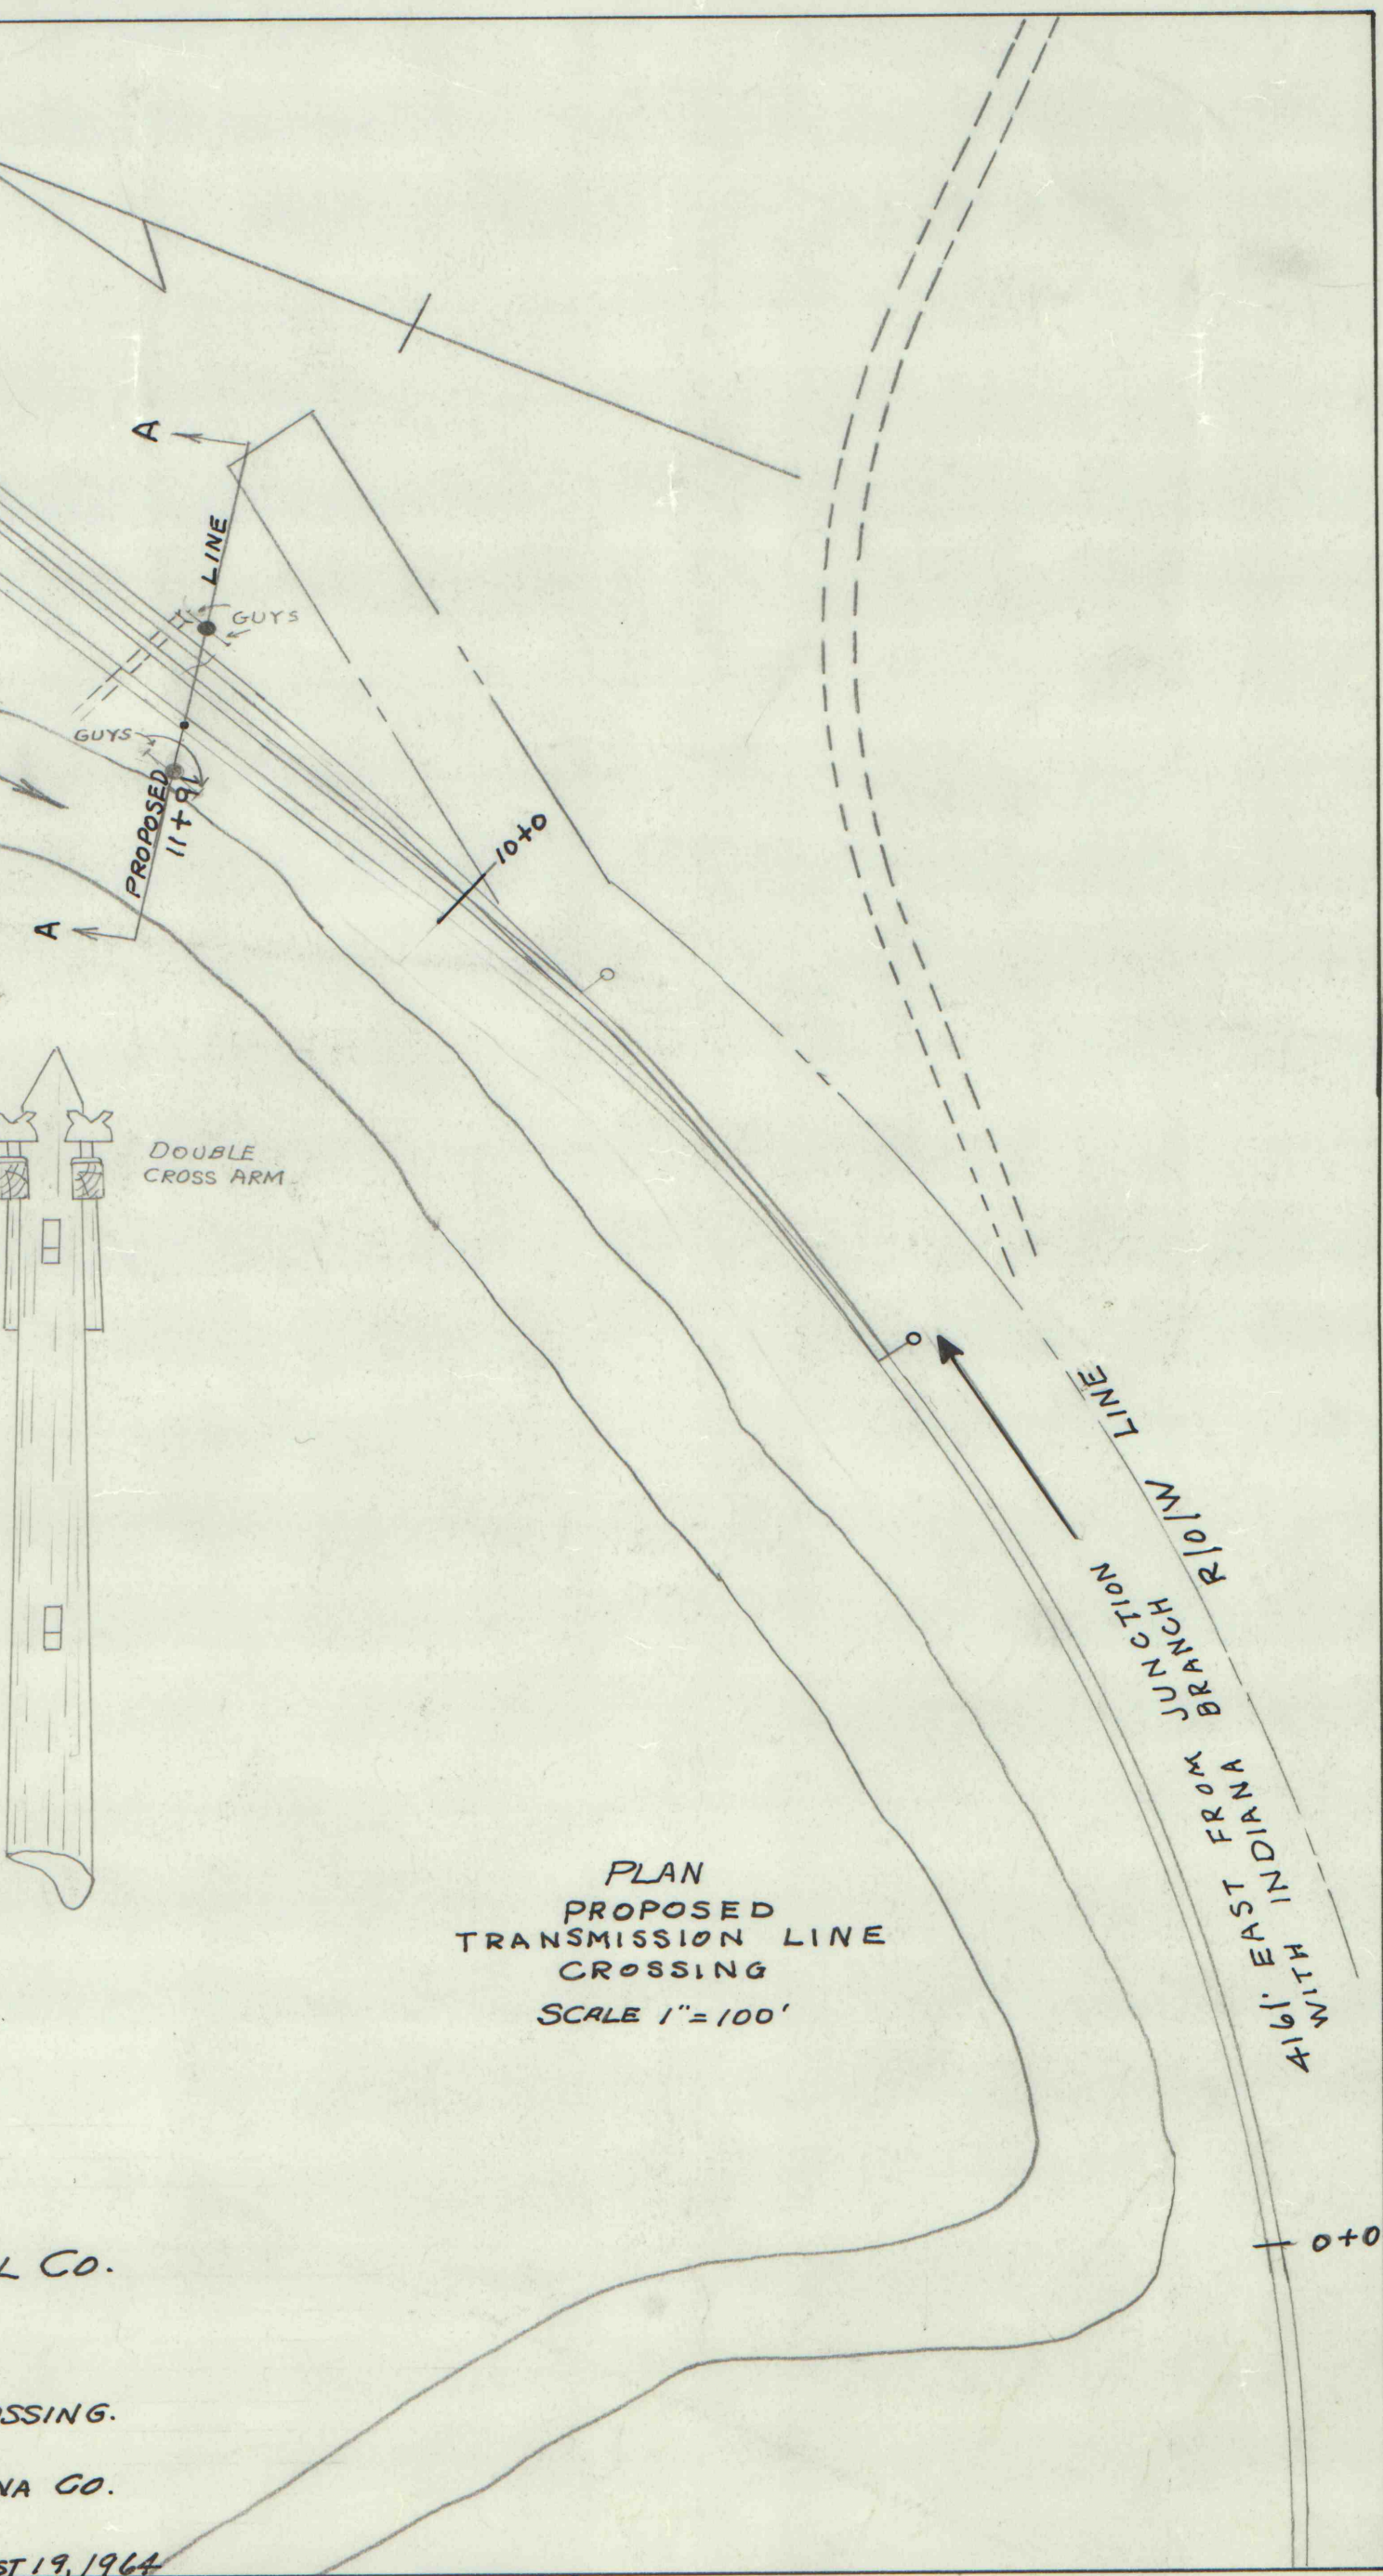

IMAPS 10077

9599-67