


S.M.Co.
FOUNDATION PLAN

FOR
200 K.W. M.-G. SET. - R.D.&E.Co.
DYNAMO #2825 A.C. MOTOR #870

Number. 714
Date. Aug. 8-'25
Scale. $\frac{3}{4} = 1'$
Drawn by. P.O.

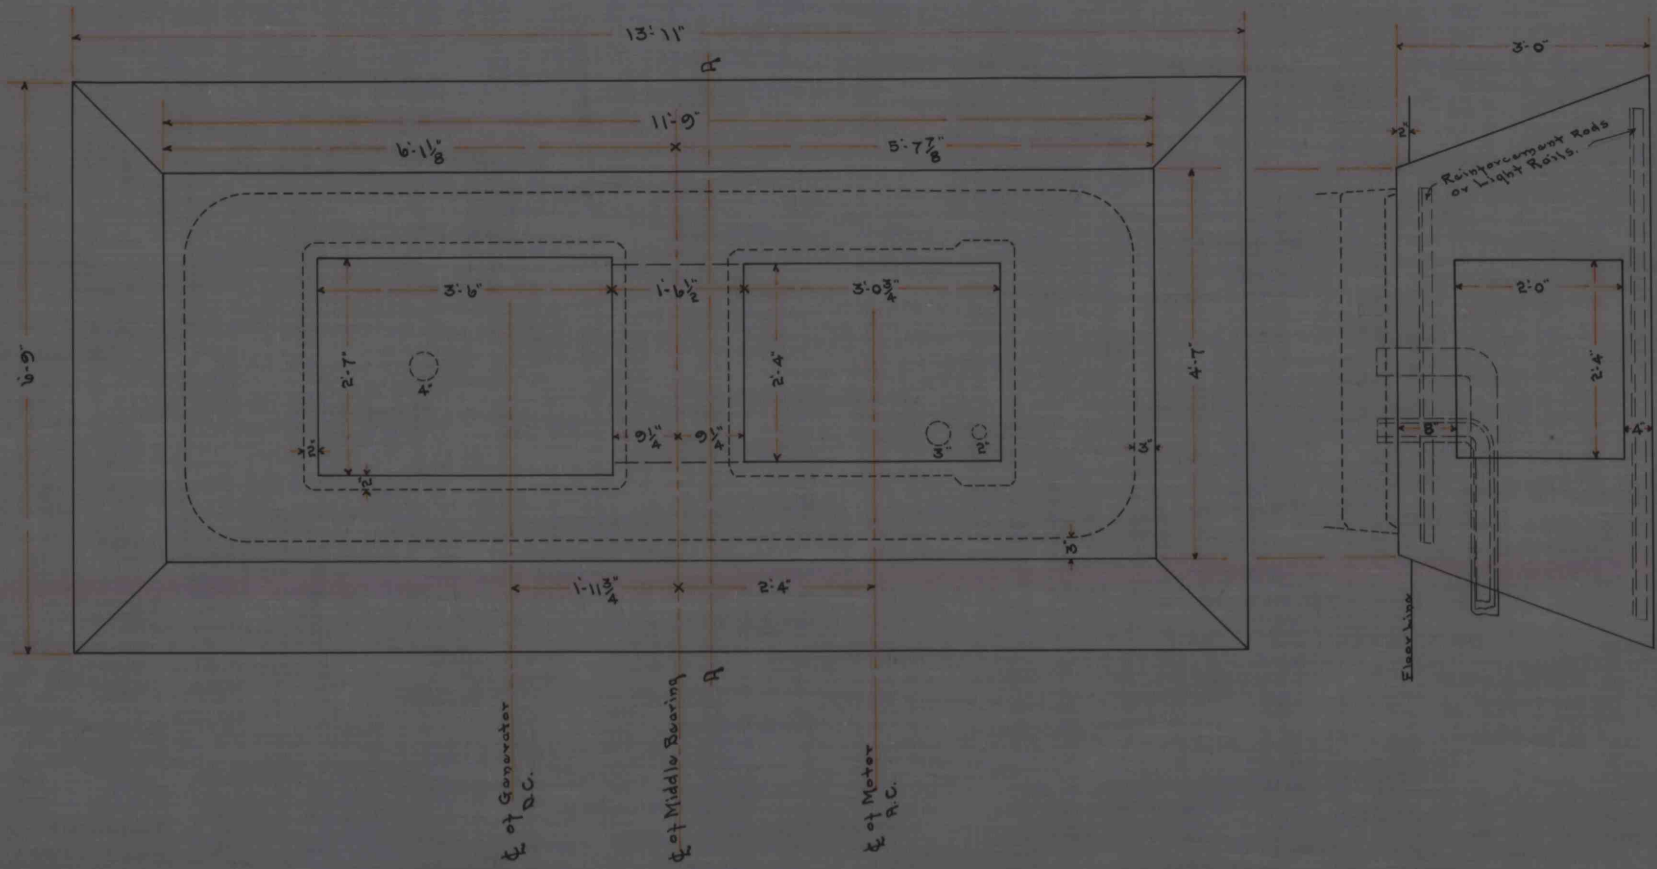

— Foundation Plan —