


PLUMBING PLAN

BATH HOUSE & OFFICE BUILDING
FOR
HELVETIA COAL CO.
INDIANA, PA. 15701

WILSON CONSTRUCTION CO., INC.
GENERAL CONTRACTORS
1780 GOUCHER STREET
JOHNSTOWN, PENNSYLVANIA 15905

PROJECT NO. 43-1070 DRAWN BY J.C. SHEET NO. P-1
DATE 4-25-71 CHECKED BY

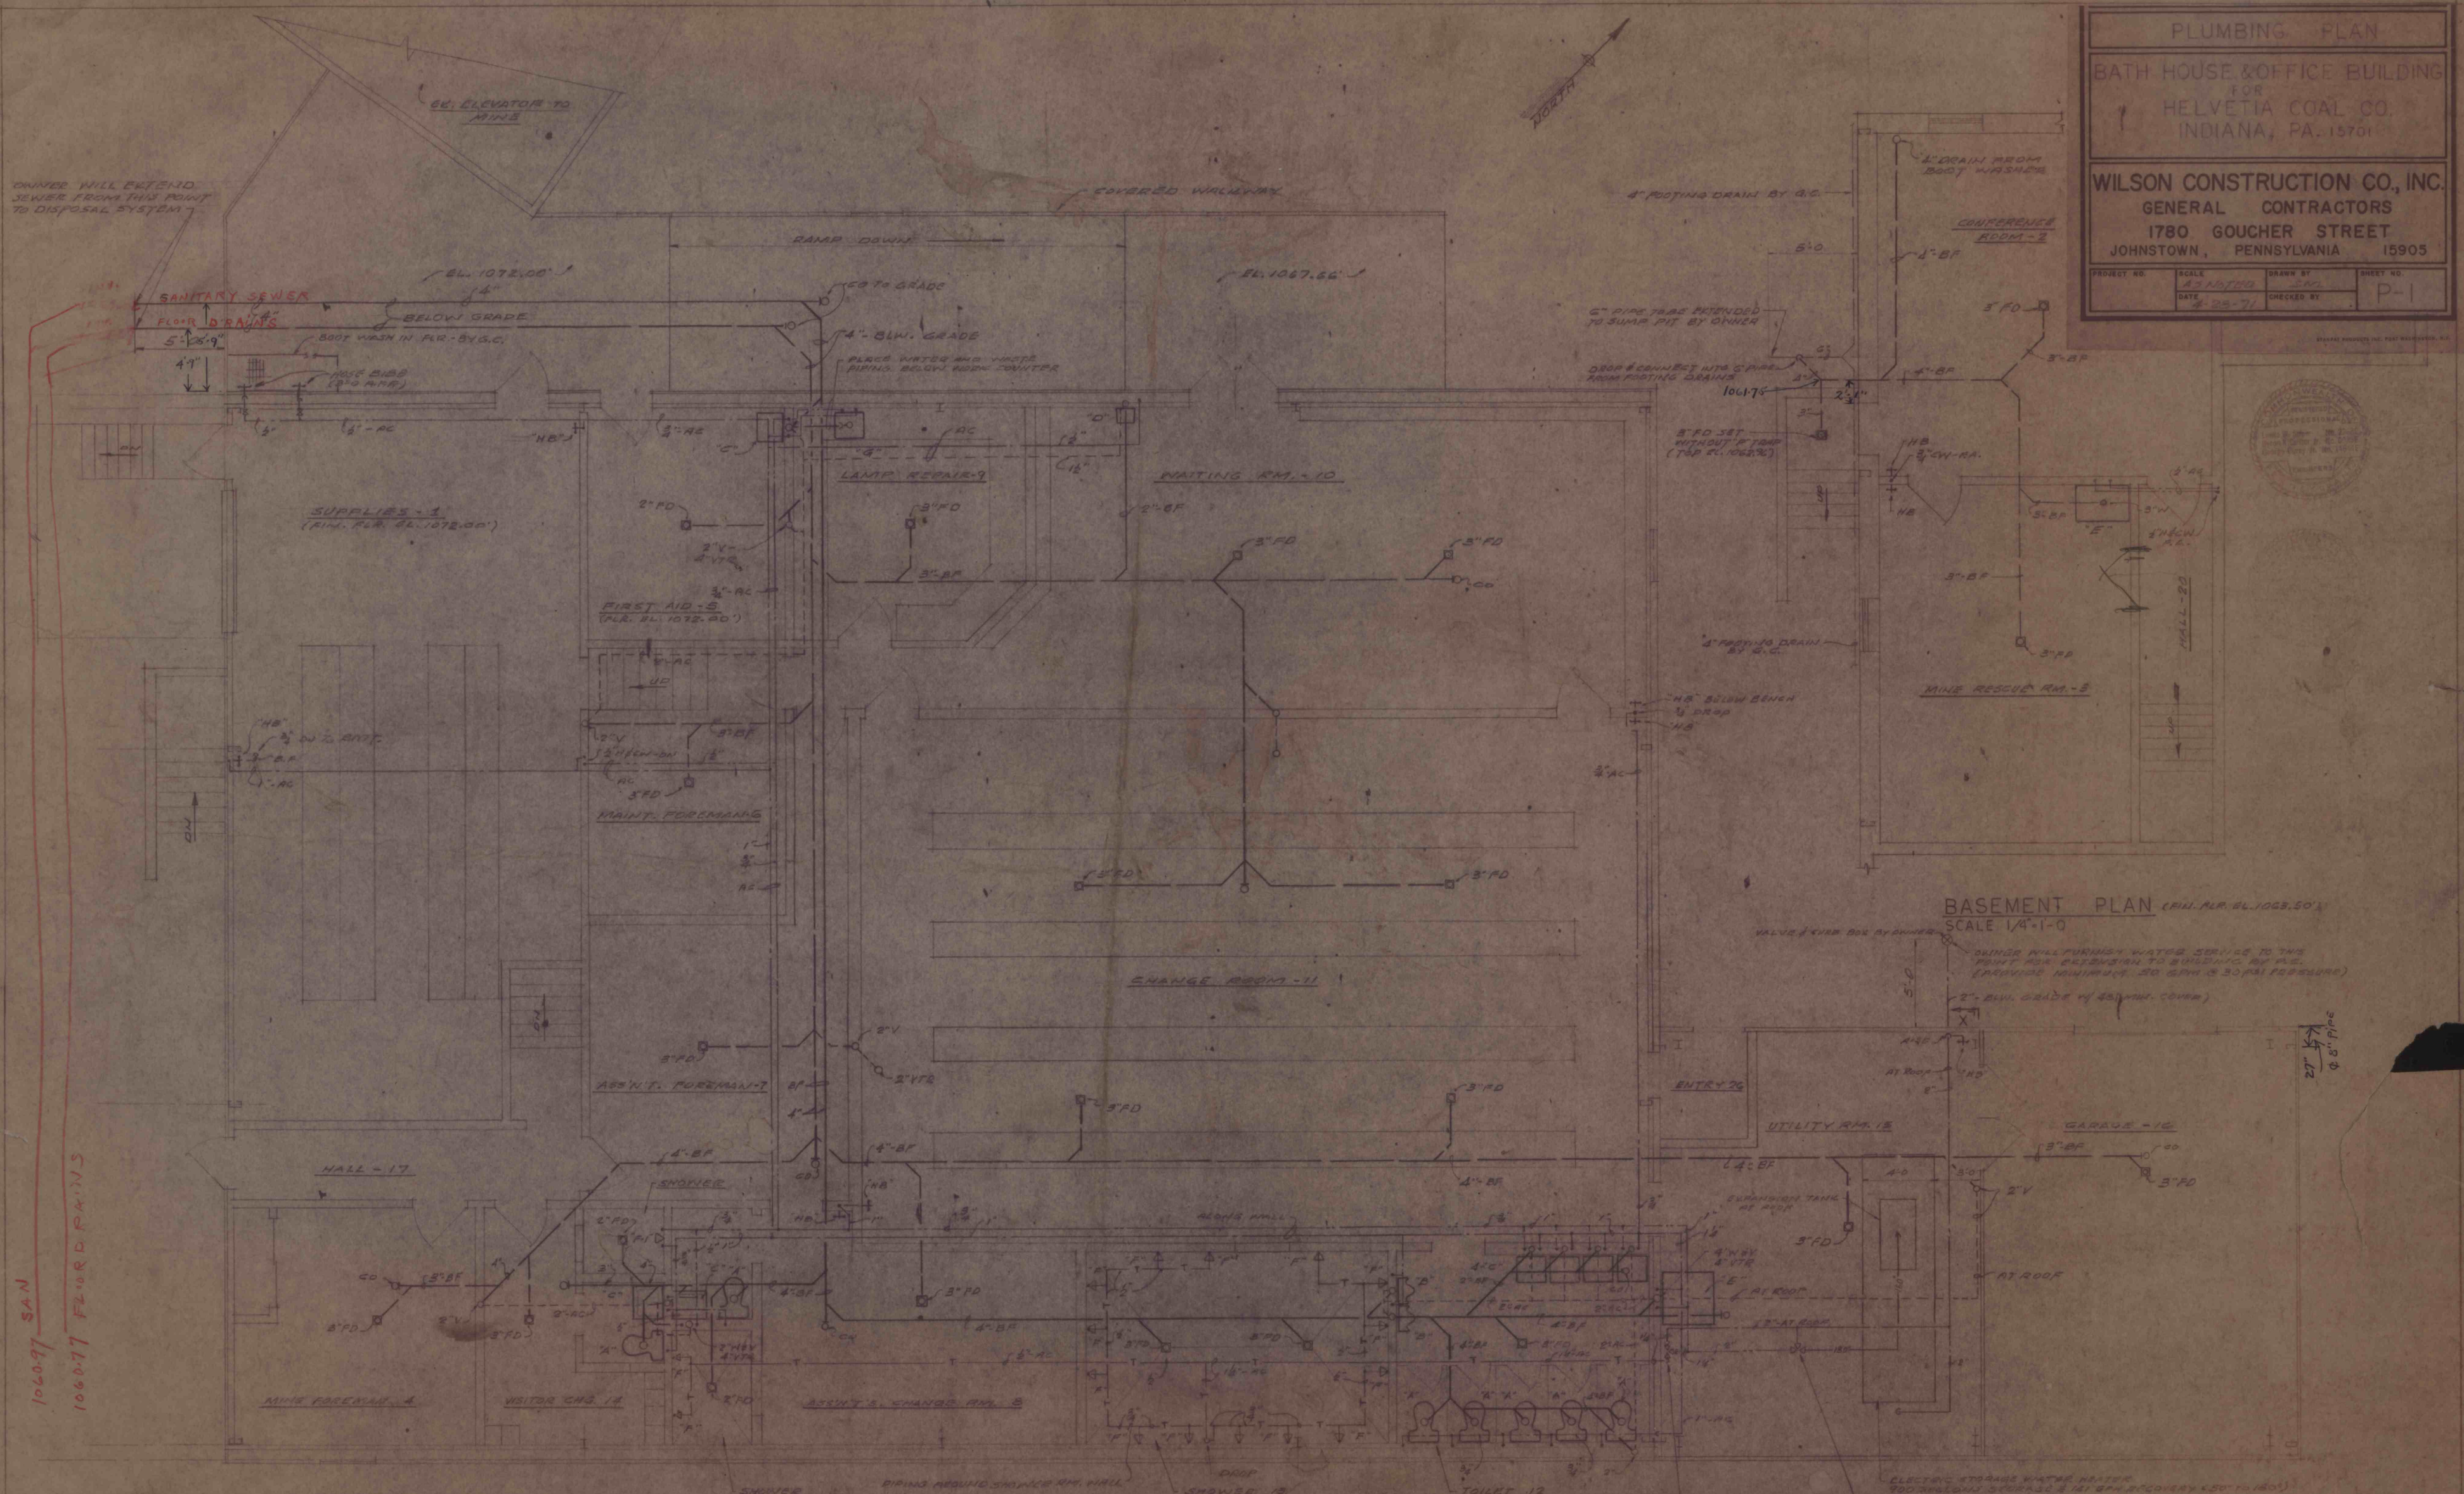

FIXTURE LIST

TYPE	DESCRIPTION	SIZE	LOCATION
A	WATER CLOSET	4" W	2nd fl
B	URINAL	8" W	3rd fl
C	LAVATORY	12" W	5" H
D	WATER COOLER	12" W	5" H
E	SERVICE SINK	2" W	5" H
F	GANG SHOWER UNIT	5" W	5" H
G	STALL SHOWER UNIT	6" W	5" H
H	COUNTER SINK	12" W	5" H

MAIN FLOOR PLAN (FIN. FLOOR EL. 1067.66" UNLESS NOTED)
SCALE 1/4"=1'-0"

BASEMENT PLAN (FIN. FLOOR EL. 1063.50")
SCALE 1/4"=1'-0"

IMAPS # 15194