


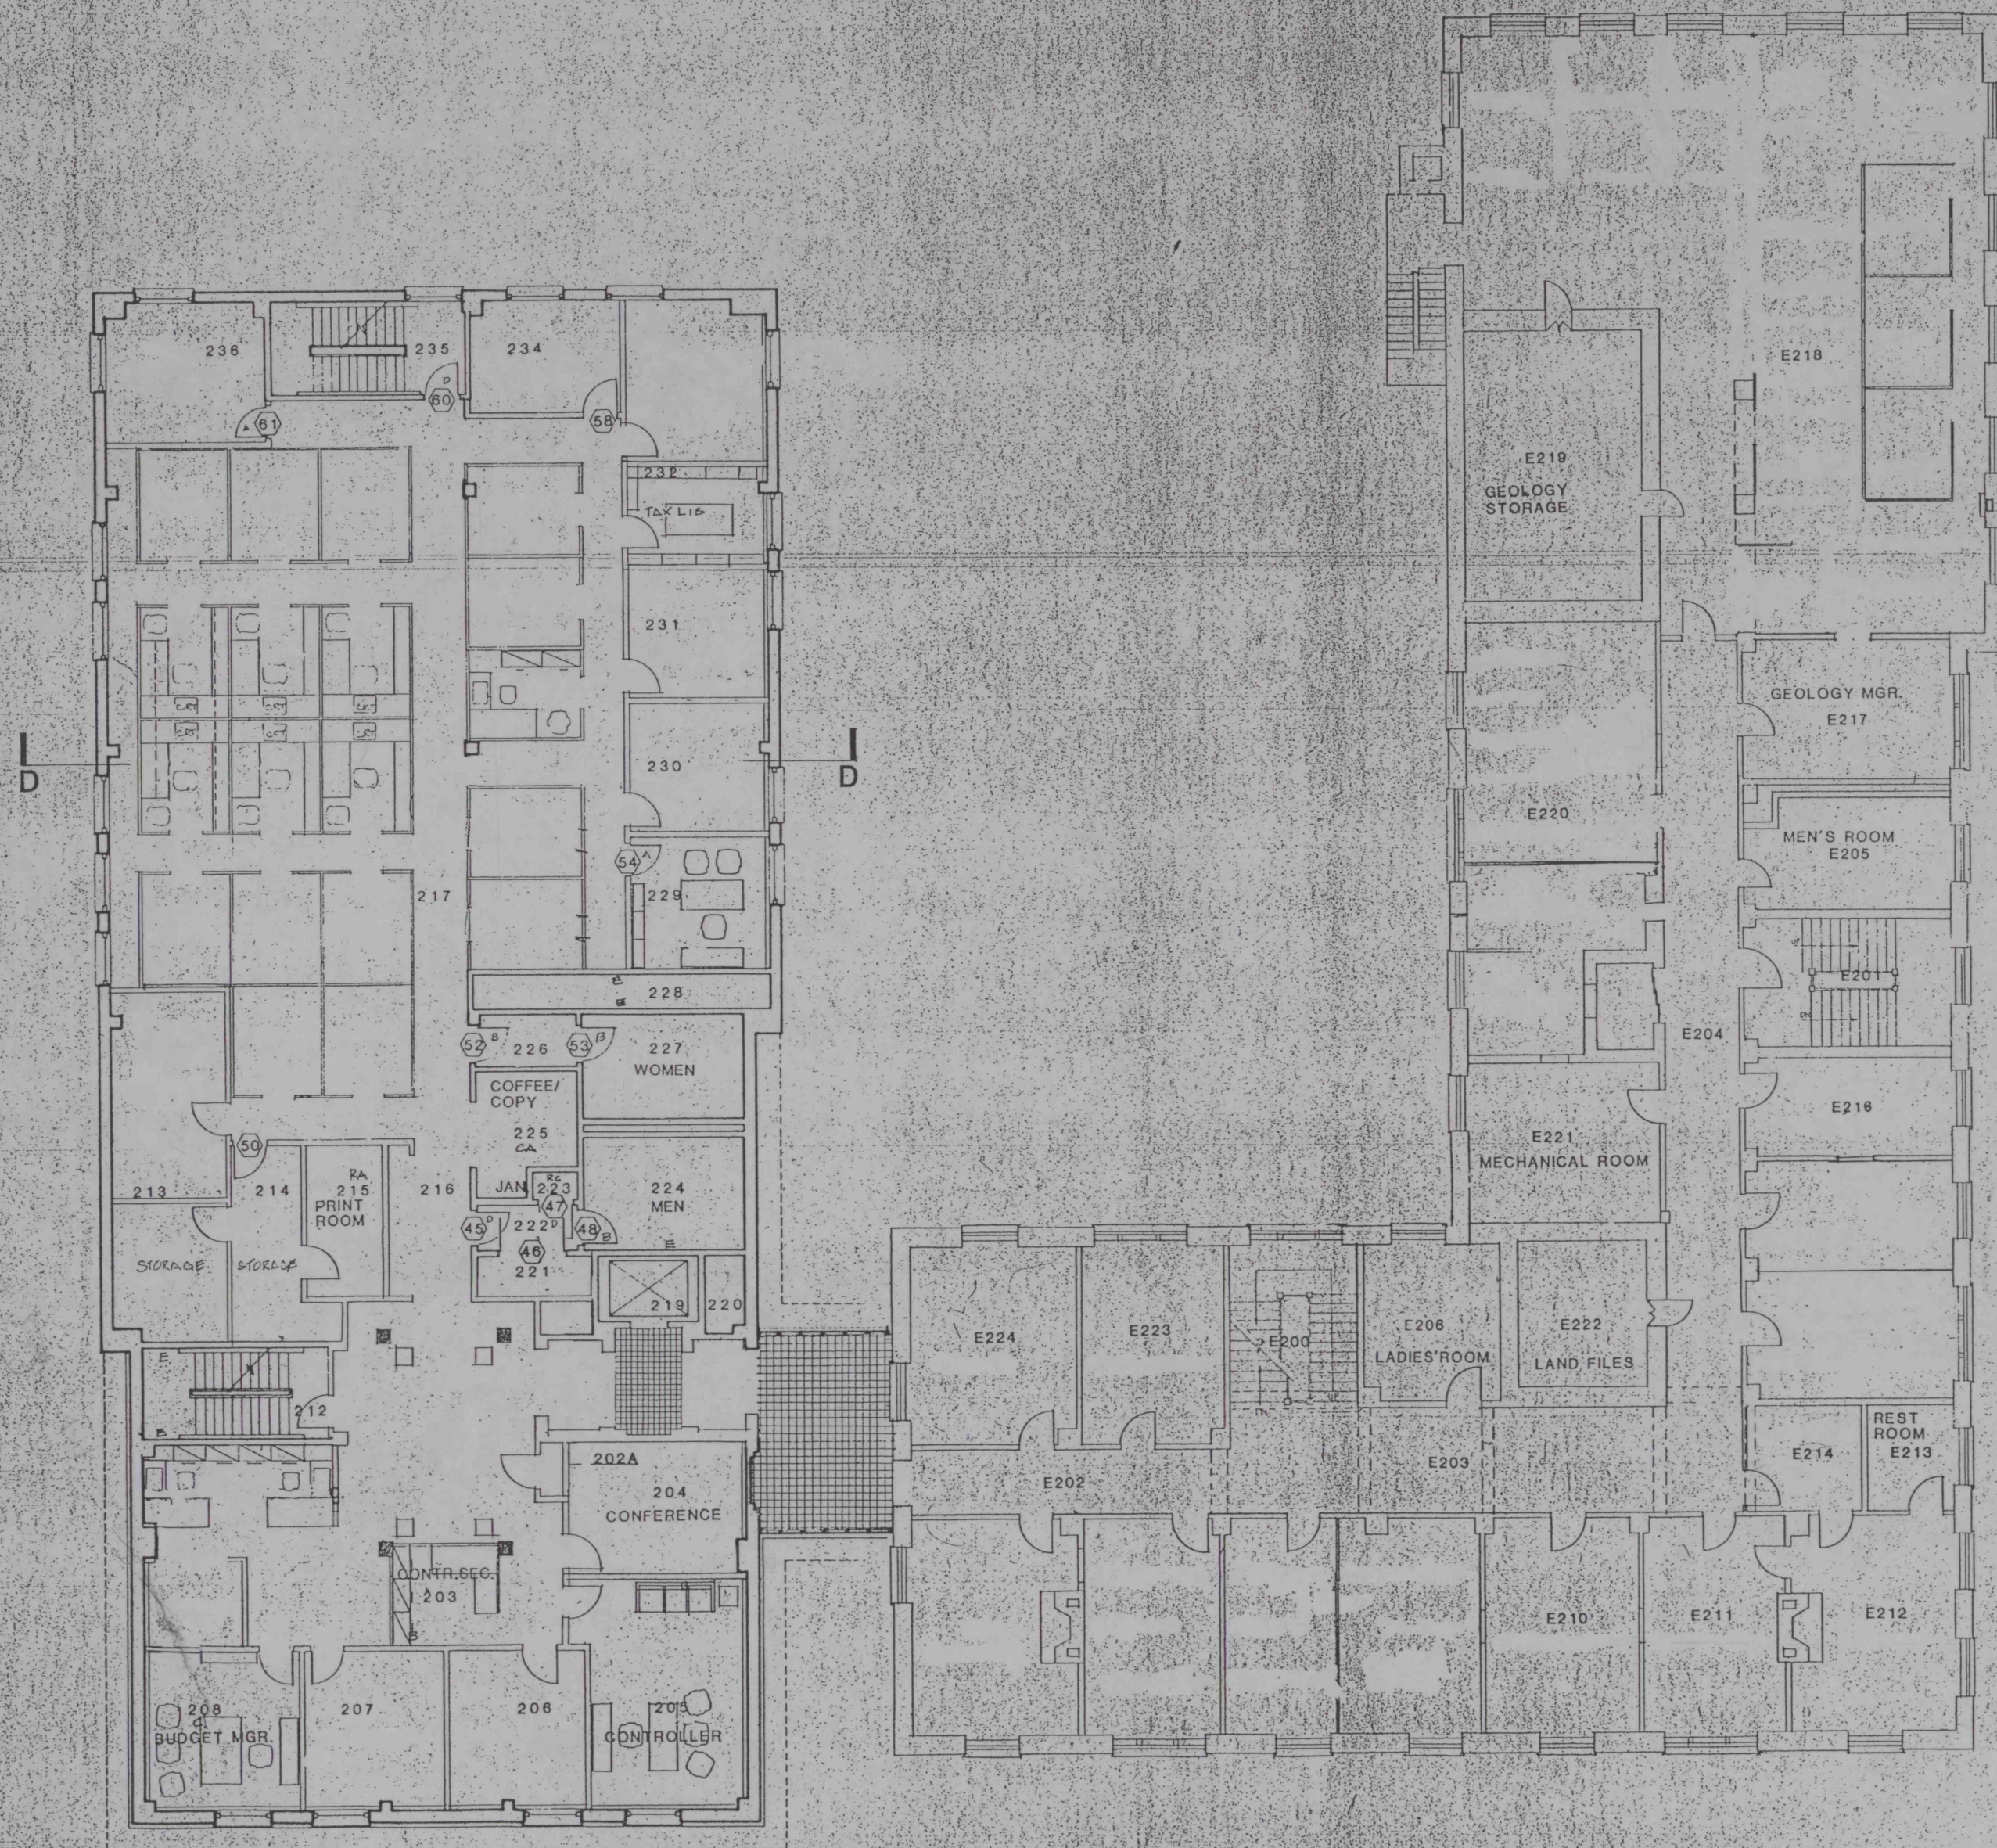

Transpace Incorporated
Design Group
Programming & Facility
Interior Architectural Design
Pittsburgh and West Virginia
Teresa Orlando & Michael Deane

Bohlin Powell Larkin Cywinski
Architects Planners Engineers
Wilkes-Barre Pittsburgh Philadelphia

DEC. 2 1983

NUMBER DATE REVISIONS

PROJECT

Rochester & Pittsburgh
COAL COMPANY
FOUNDED 1881

HEADQUARTERS ADDITION

DRAWING TITLE
SECOND FLOOR PLAN

DRAWN BY/CHECKED BY DATE

SCALE 1/8"=1'-0" DRAWING NO.

PROJECT NO. 1052 DD-3

83-204

JMAPS#16723

12336-125