


- LEGEND
- ⊕ DUPLEX RECEPTACLE, HUBBEL CR20
 - ⊕³ GROUND FAULT INTERRUPTER, RECEPTACLE, 20 AMP
 - ⊕⁰ ISOLATED GROUND RECEPTACLE

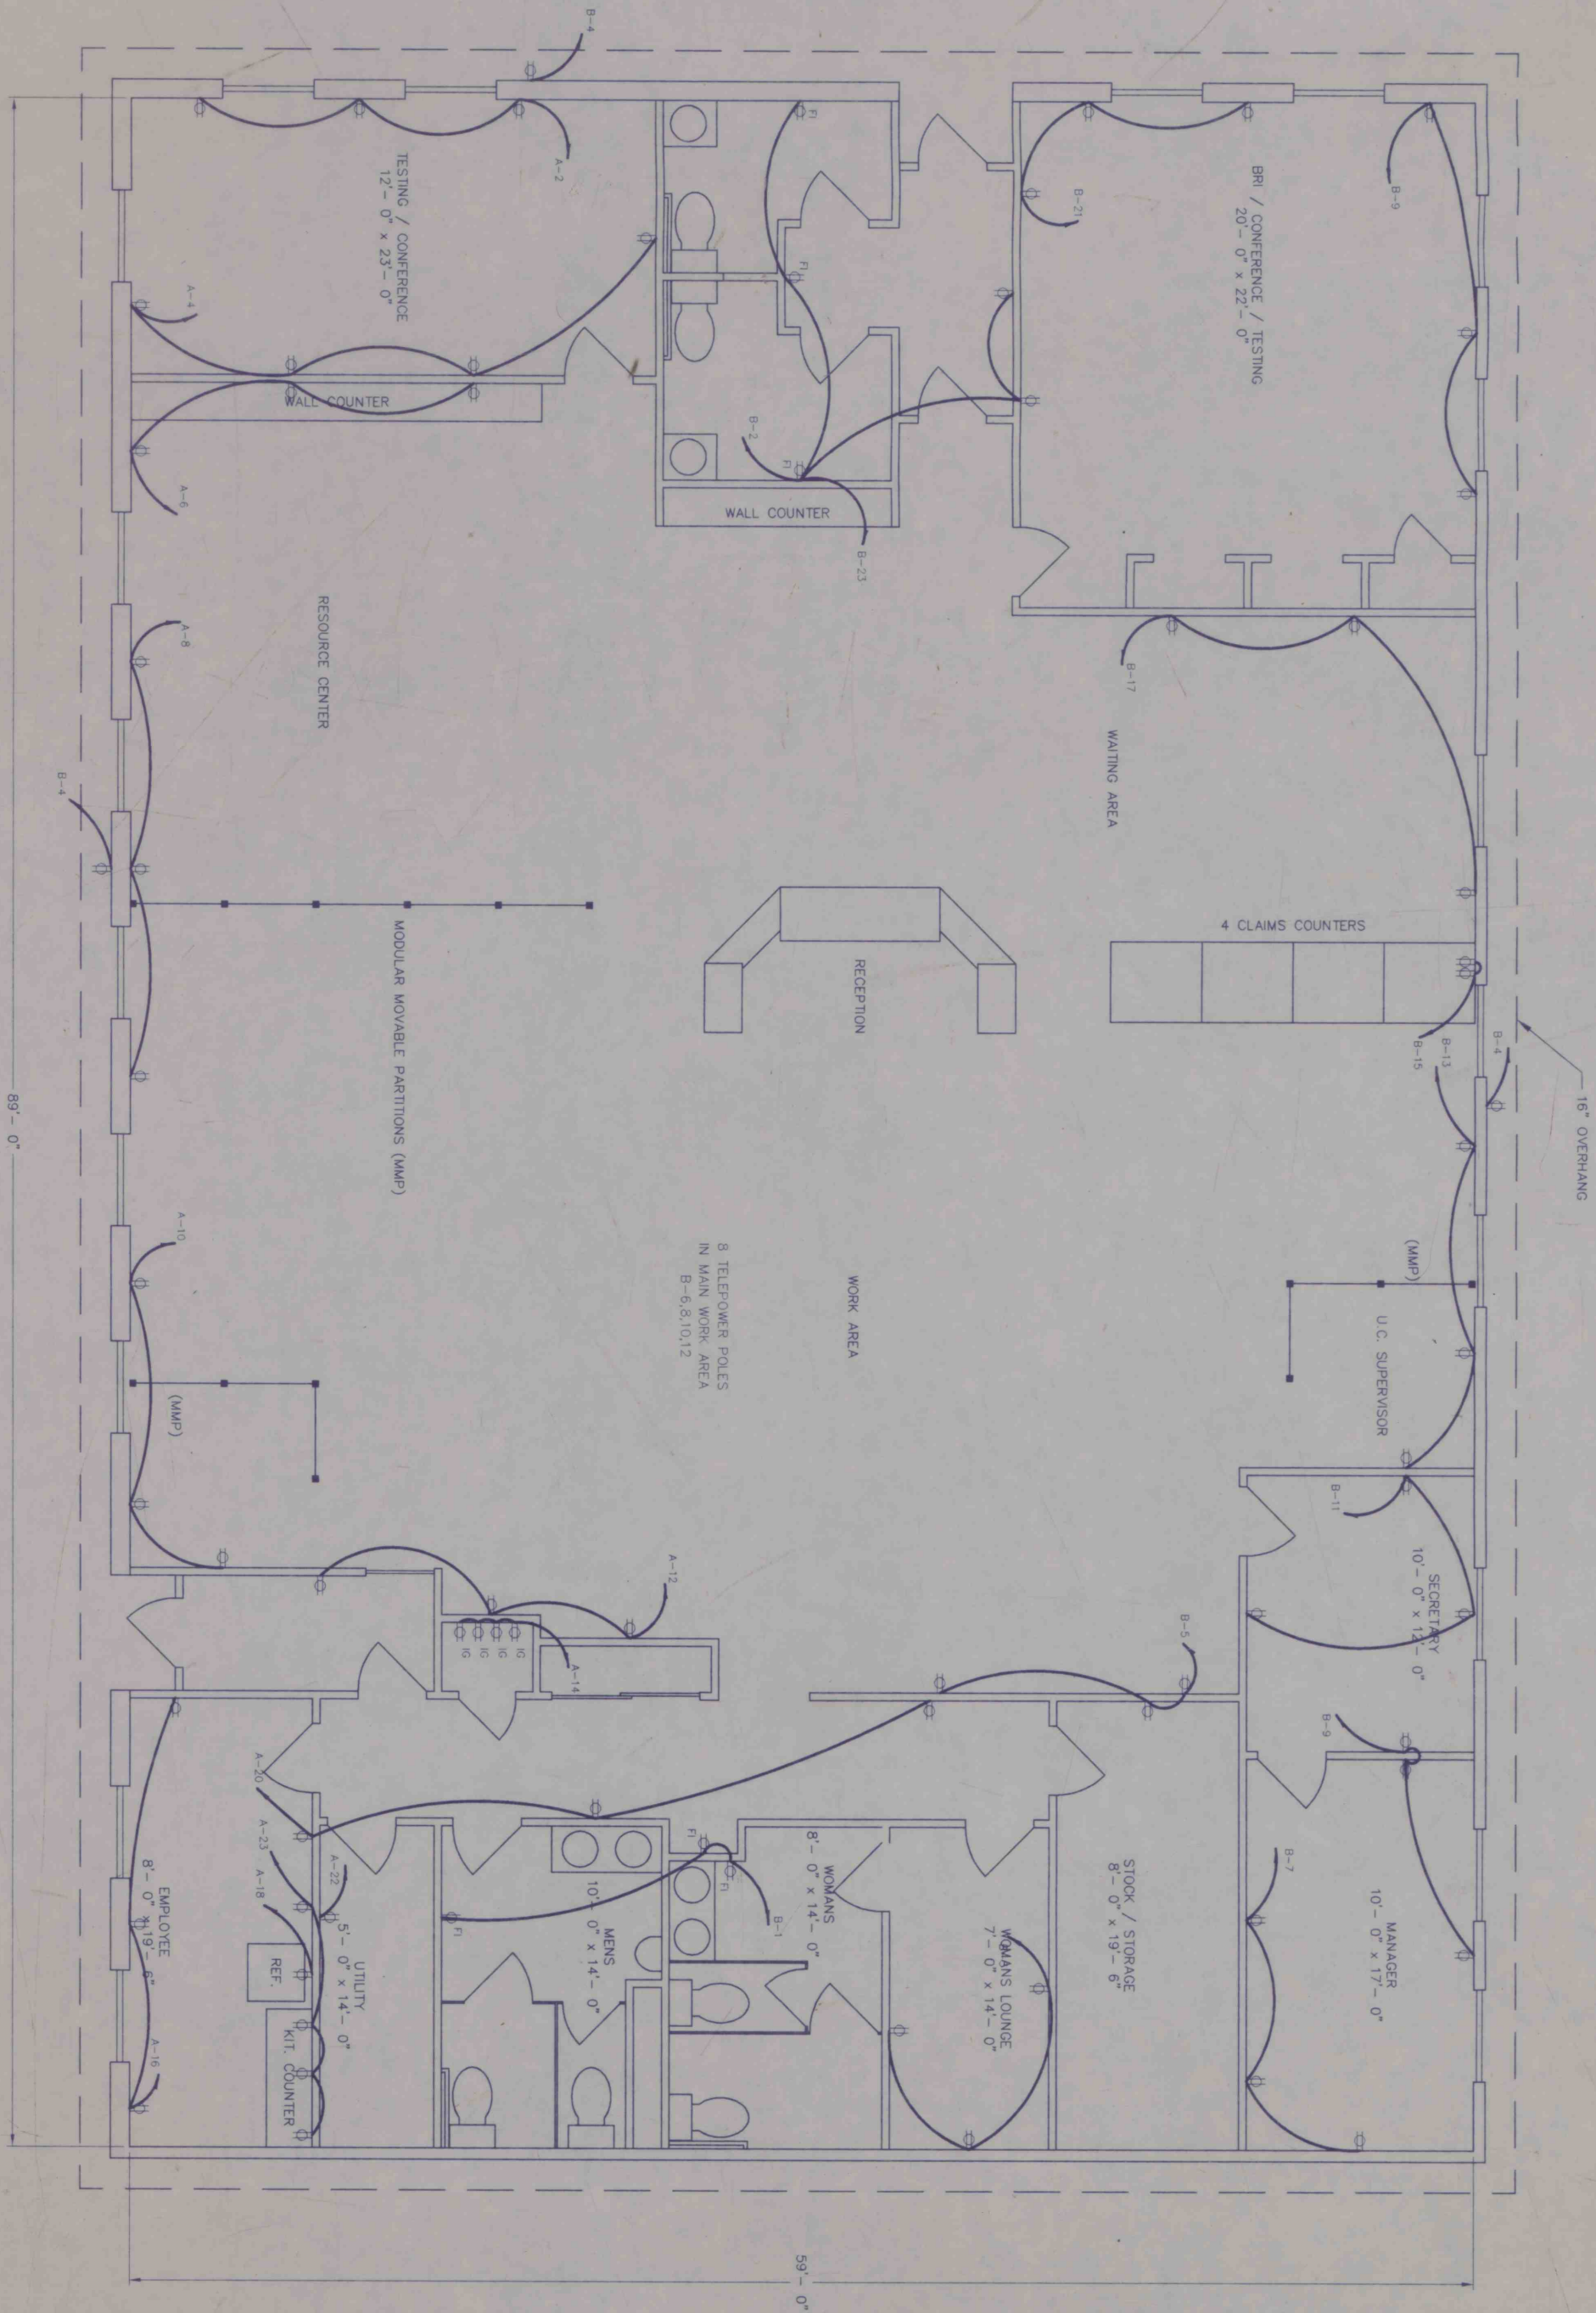

JOB CENTER
602 EAST MAHONING STREET
ELECTRICAL LAYOUT PLAN
PUNXSUTAWNEY PA.

APPROVED: _____
DATE: _____
APPROVED: _____
DATE: _____
APPROVED: _____ ENGINEER
REG. NO. _____ DATE: _____

SEAL

 LEE - SIMPSON ASSOCIATES, INC. CONSULTING ENGINEERS 205 WEST WEBER AVE. DUBOIS, PA. 16801 (814) 371-7750		REVISIONS 9-24-93 BY M.R.D. DRAWN BY M.R.D. CHECKED BY S.K. DATE 6-29-93 SCALE 1/4" = 1'-0"		FAX NO. (814) 371-8864 DISK NO. ? FILE NO. 89313001
---	--	---	--	---

SHEET

E24

OF 7 SHEETS