


LEGEND

- EMERGENCY LIGHT UNIT, DUAL LITE DL-4
- REMOTE HEAD, DUAL LITE INTERIOR-REMP-16v, EXTERIOR-EX-05
- EXIT SIGN, DUAL LITE EXCALIBUR CWRNB-DC-6v
- 2 HEAD W.P. FLOOD WITH PHOTO EYE

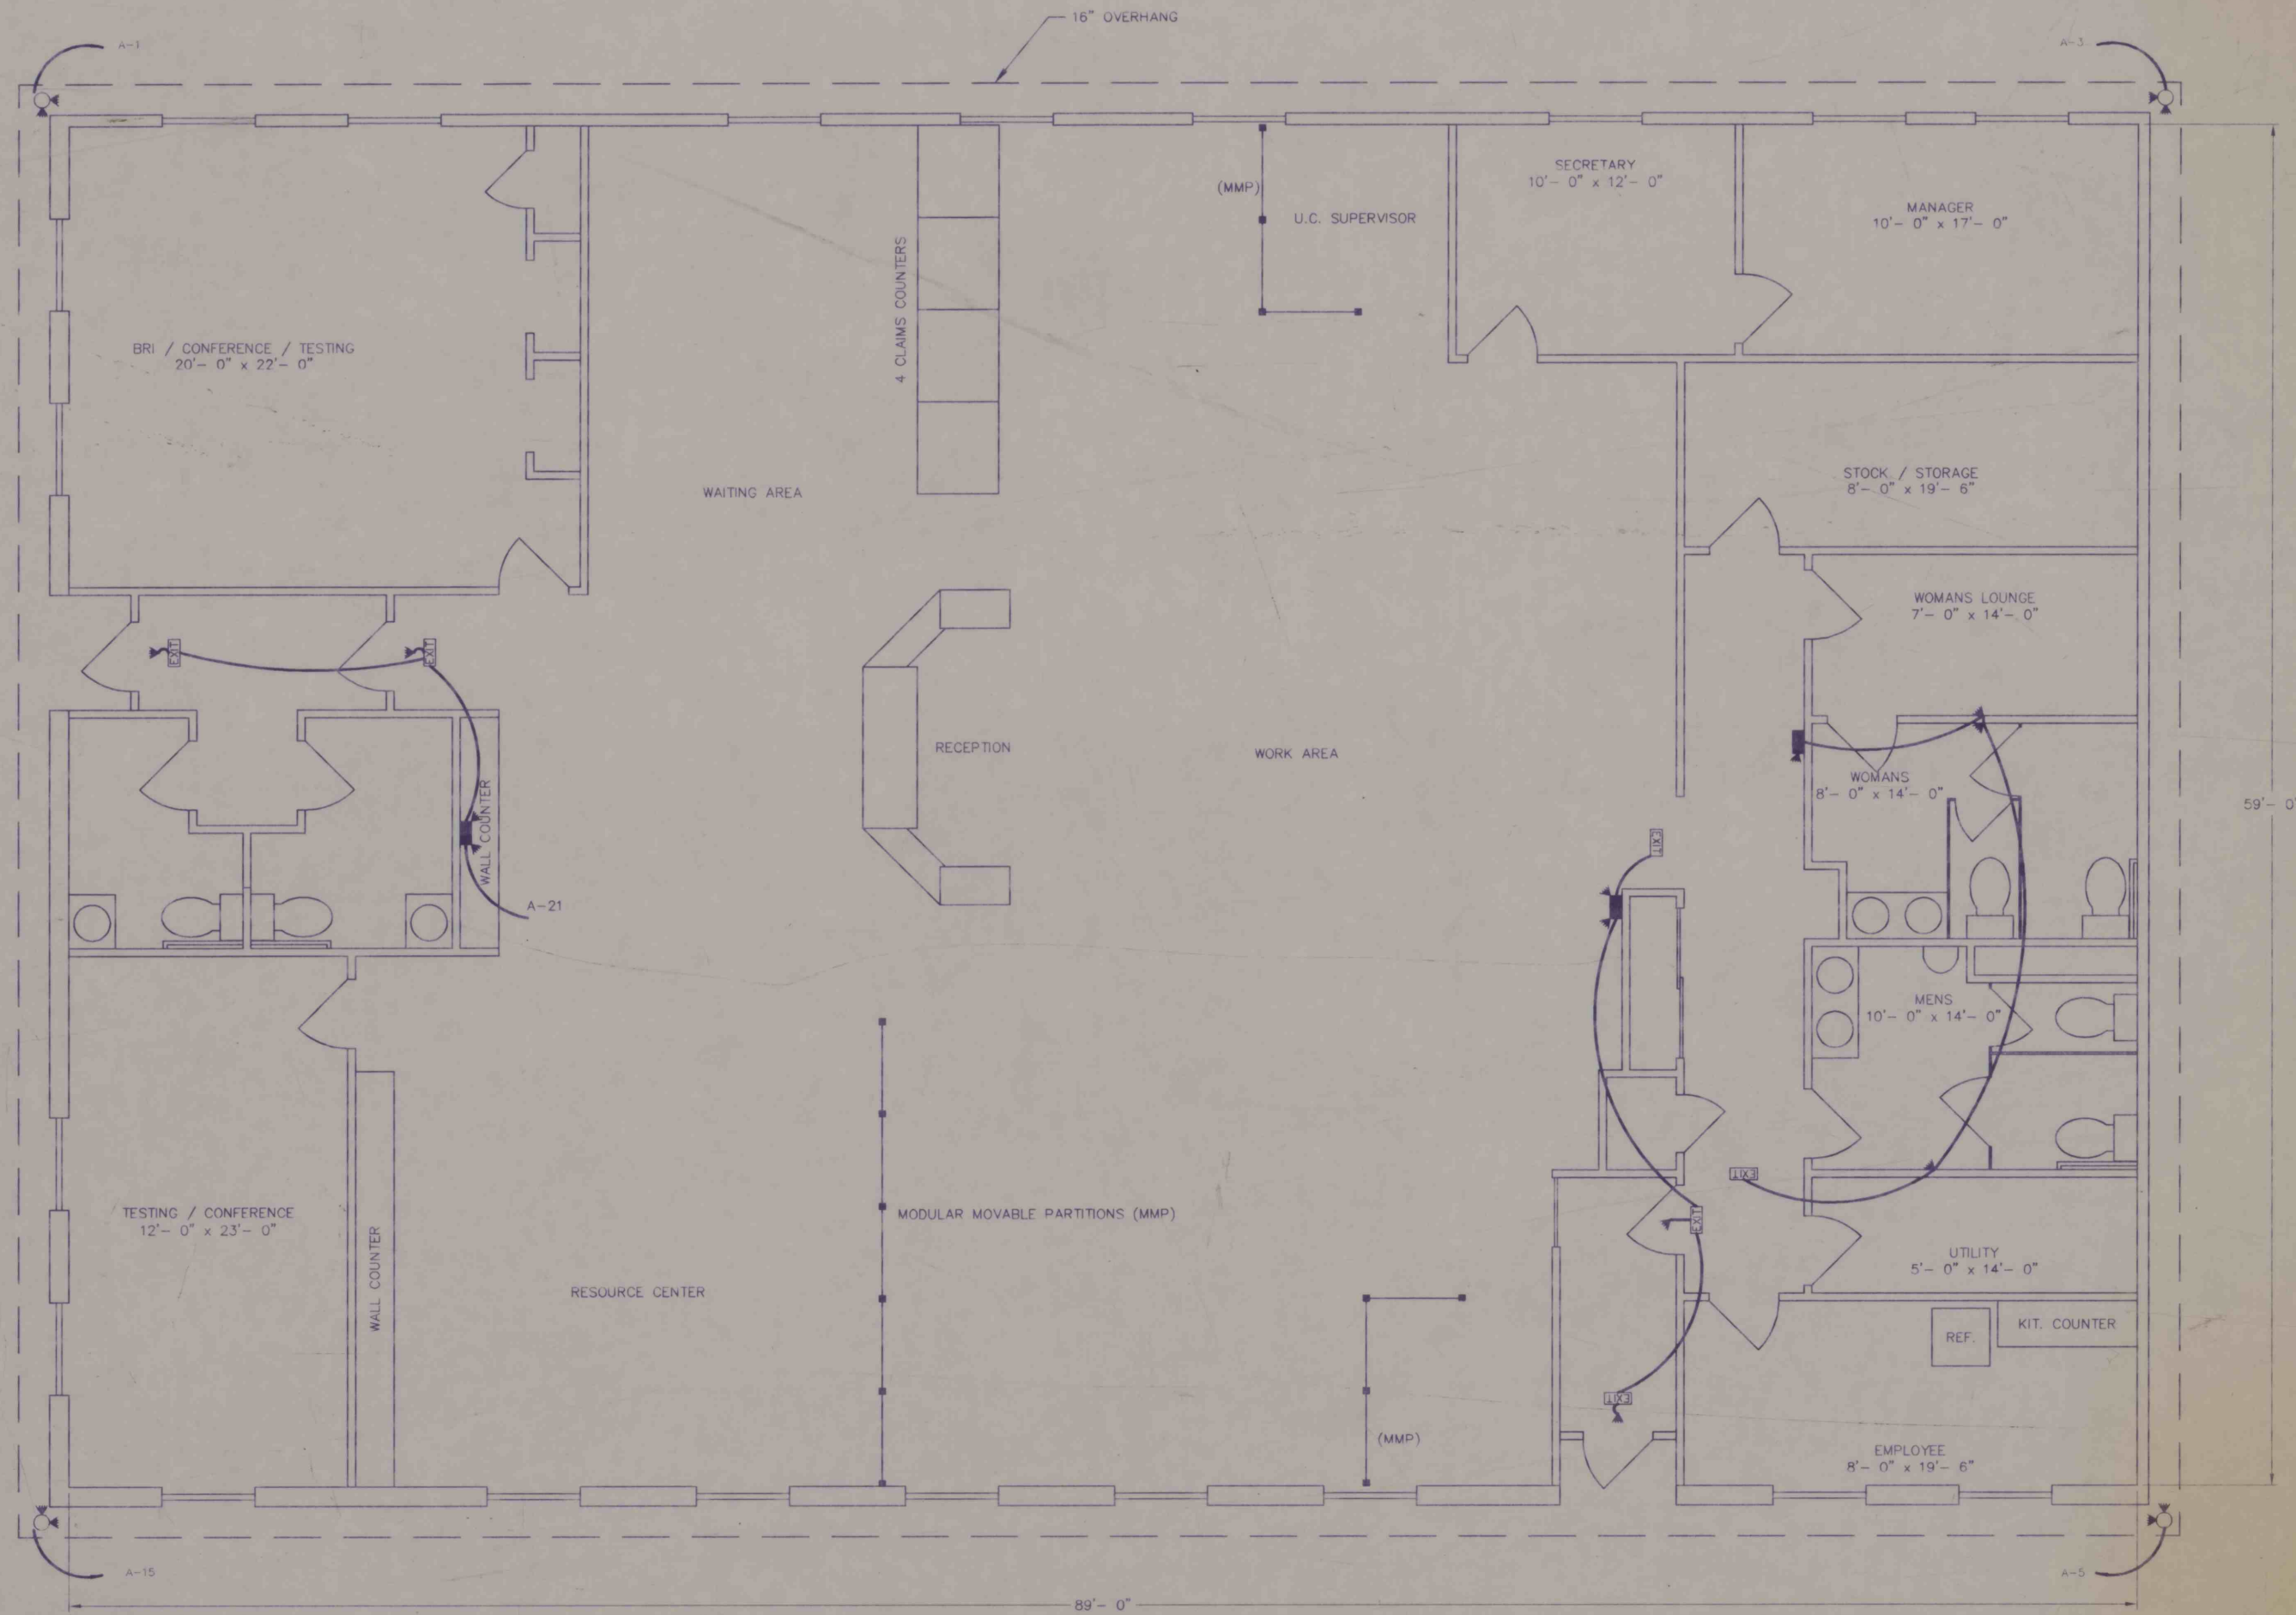

LEE - SIMPSON ASSOCIATES, INC.
CONSULTING ENGINEERS
203 WEST WILSON AVE
DUNELPA, PA 15031 (610) 971-7750

BY	DATE	BY	DATE
DESIGNED BY	M.P.D.	CHECKED BY	S.K.
DATE	6-29-93	DATE	6-29-93
SCALE	1/4" = 1' - 0"	FILE NO.	89313001

APPROVED:	DATE:
APPROVED:	DATE:
APPROVED:	DATE:
APPROVED:	DATE:

JOB CENTER
602 EAST MAHONING STREET
EMERGENCY / PERIMETER LIGHTING PLAN
PUNXSUTAWNEY PA.