


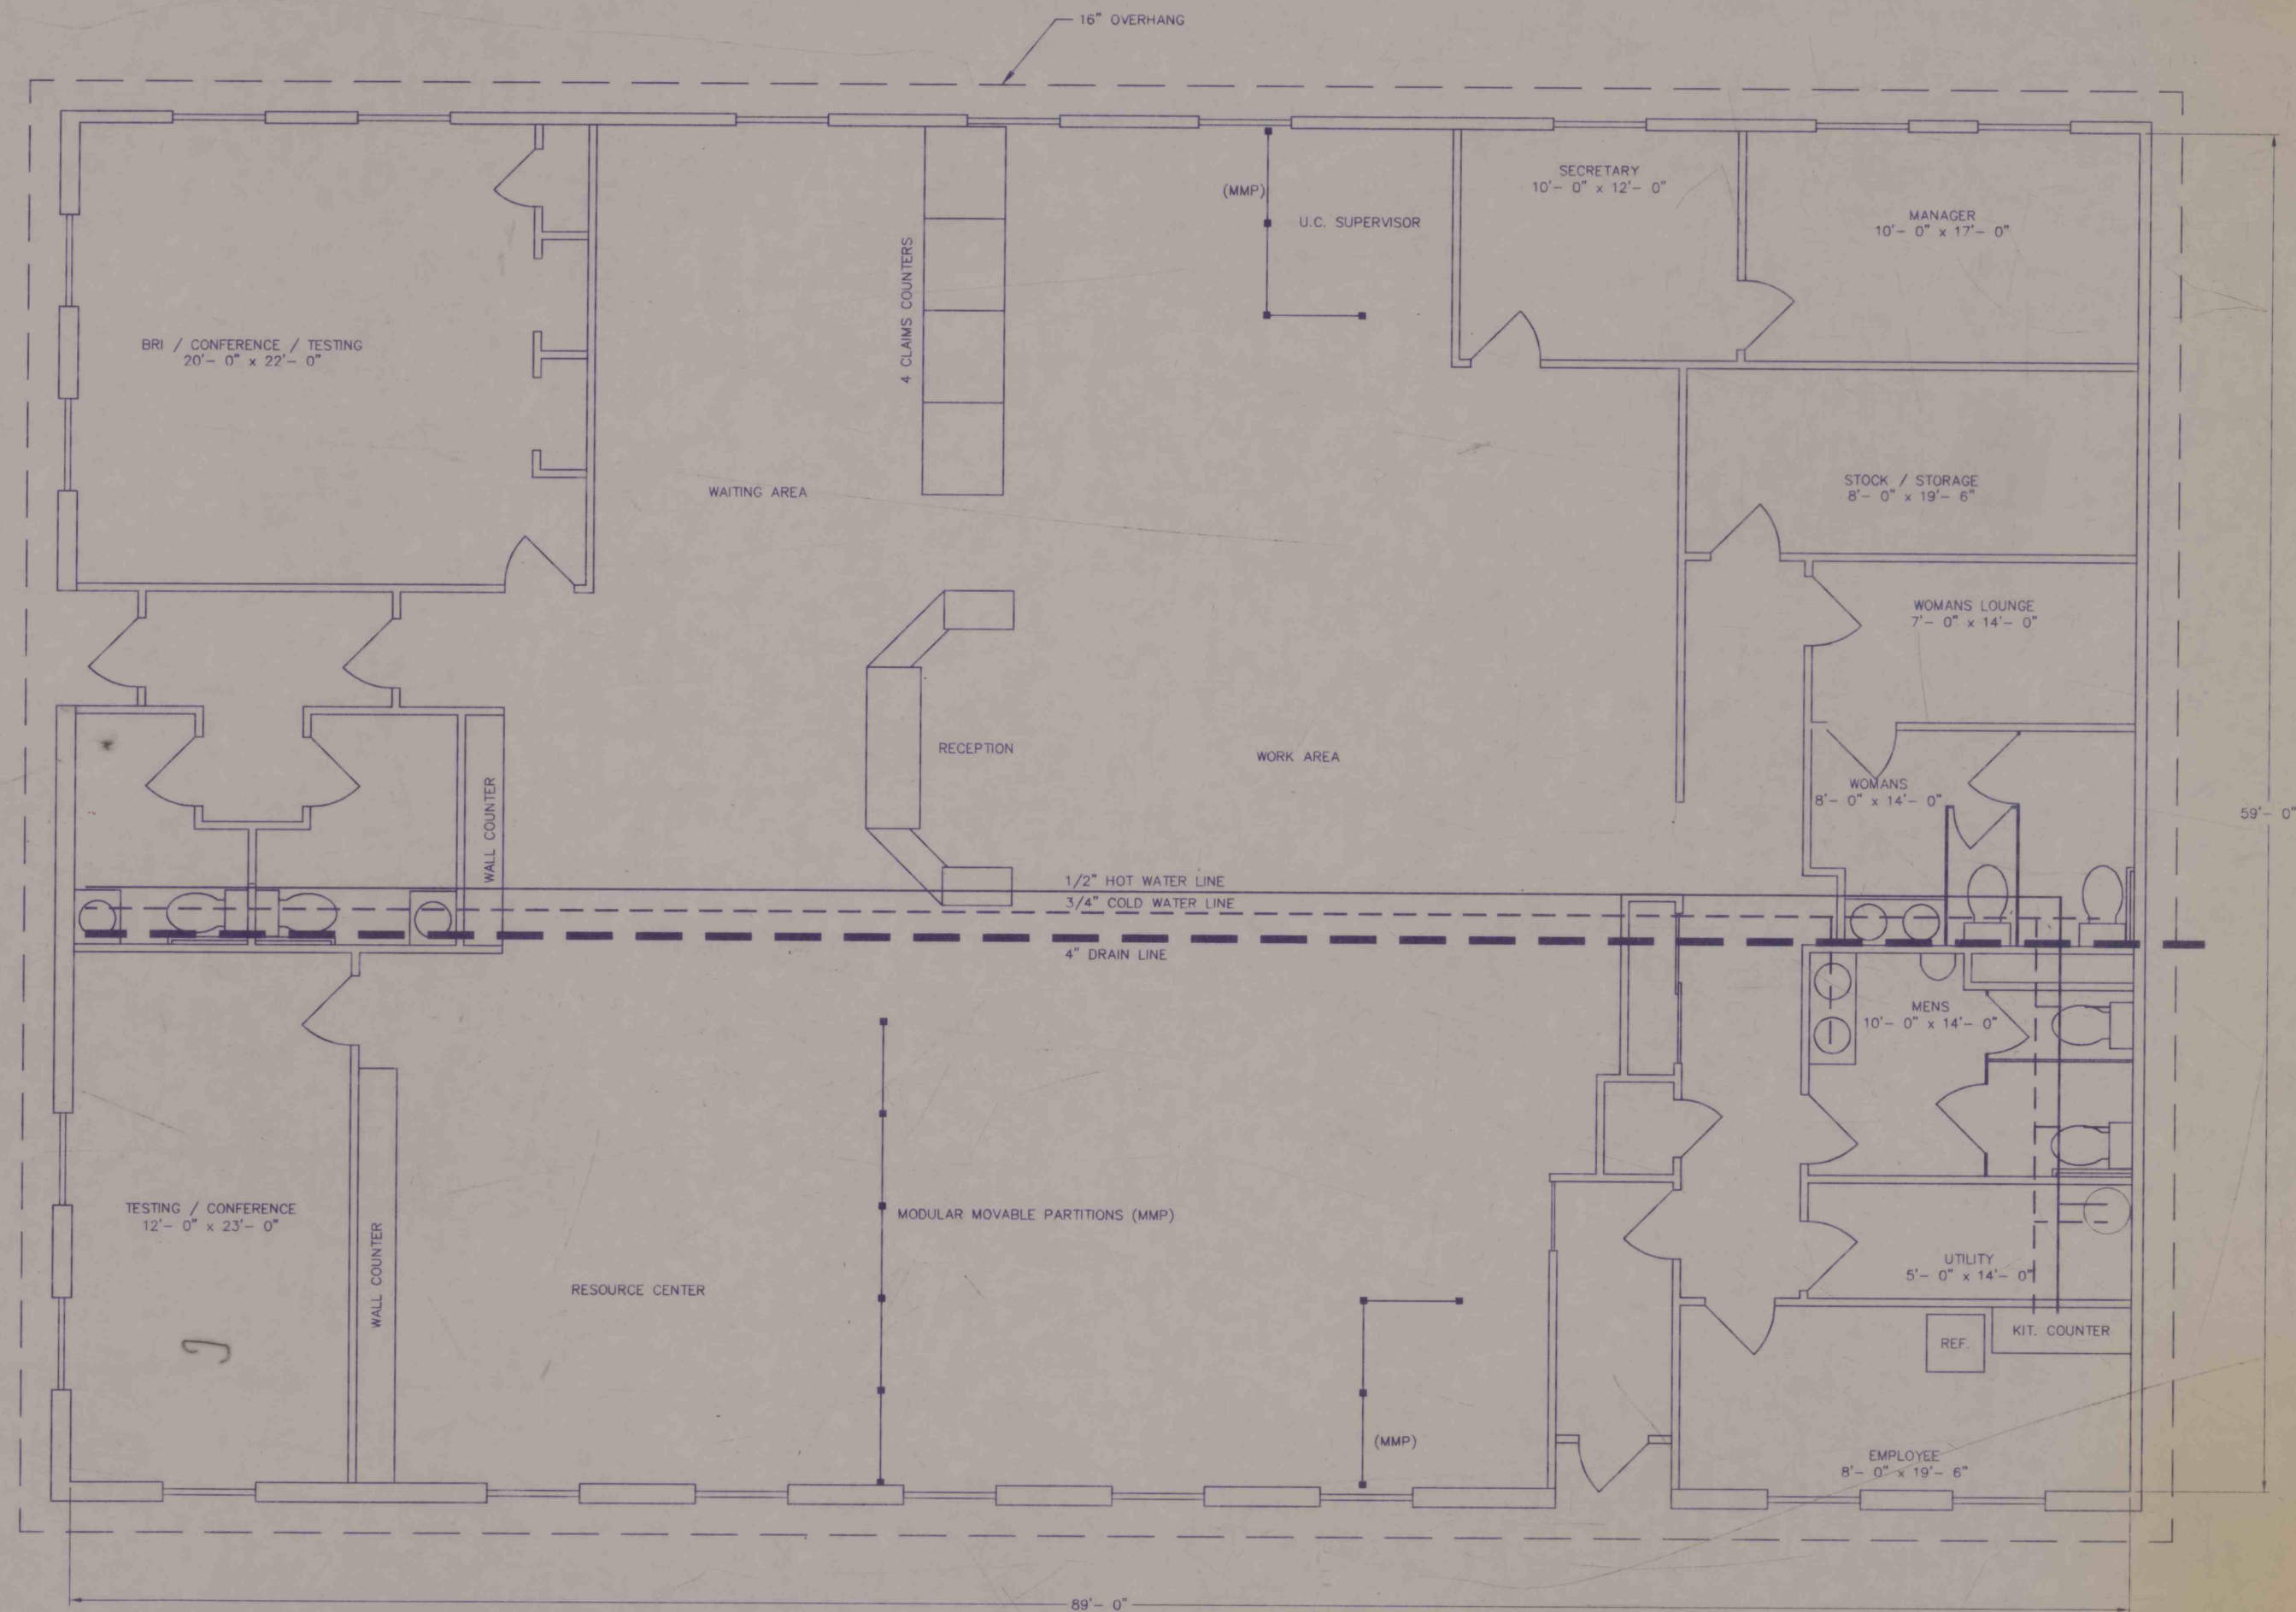

LEE - SIMPSON ASSOCIATES, INC.
 CIVIL ENGINEERS
 203 WEST WEBER AVE.
 DUNES, PA. 15501
 (412) 771-7750



PERSONS

BY: _____
 CHECKED BY: S.K.
 DATE: 6-29-93
 SCALE: 1/4" = 1' - 0"

DISK NO. 2
 FILE NO. 89313001

SEAL

APPROVED: _____
 DATE: _____

APPROVED: _____
 DATE: _____

APPROVED: _____
 REG. NO. _____ DATE: _____

ENGINEER

PLUMBING PLAN

PUNXSUTAWNEY PA.

602 EAST MAHONING STREET

JOB CENTER

SHEET

P1

OF 7 SHEETS